


ADDITION TO: PETTIT RESIDENCE

2639 DE RUBERTIS DRIVE
MADISON, OHIO 44057

DRAWING INDEX	
GENERAL	
AA	TITLE SHEET / SITE PLAN
ARCHITECTURAL	
A0	HOUSE DEMOLITION PLAN
A1	FOUNDATION PLANS
A2	FLOOR PLANS
A3	ROOF PLANS
A4	HOUSE EXTERIOR ELEVATIONS
A5	GARAGE & CARPORT EXTERIOR ELEVATIONS
A6	INTERIOR ELEVATIONS
A7	WALL SECTIONS
ELECTRICAL	
E1	ELECTRICAL PLANS

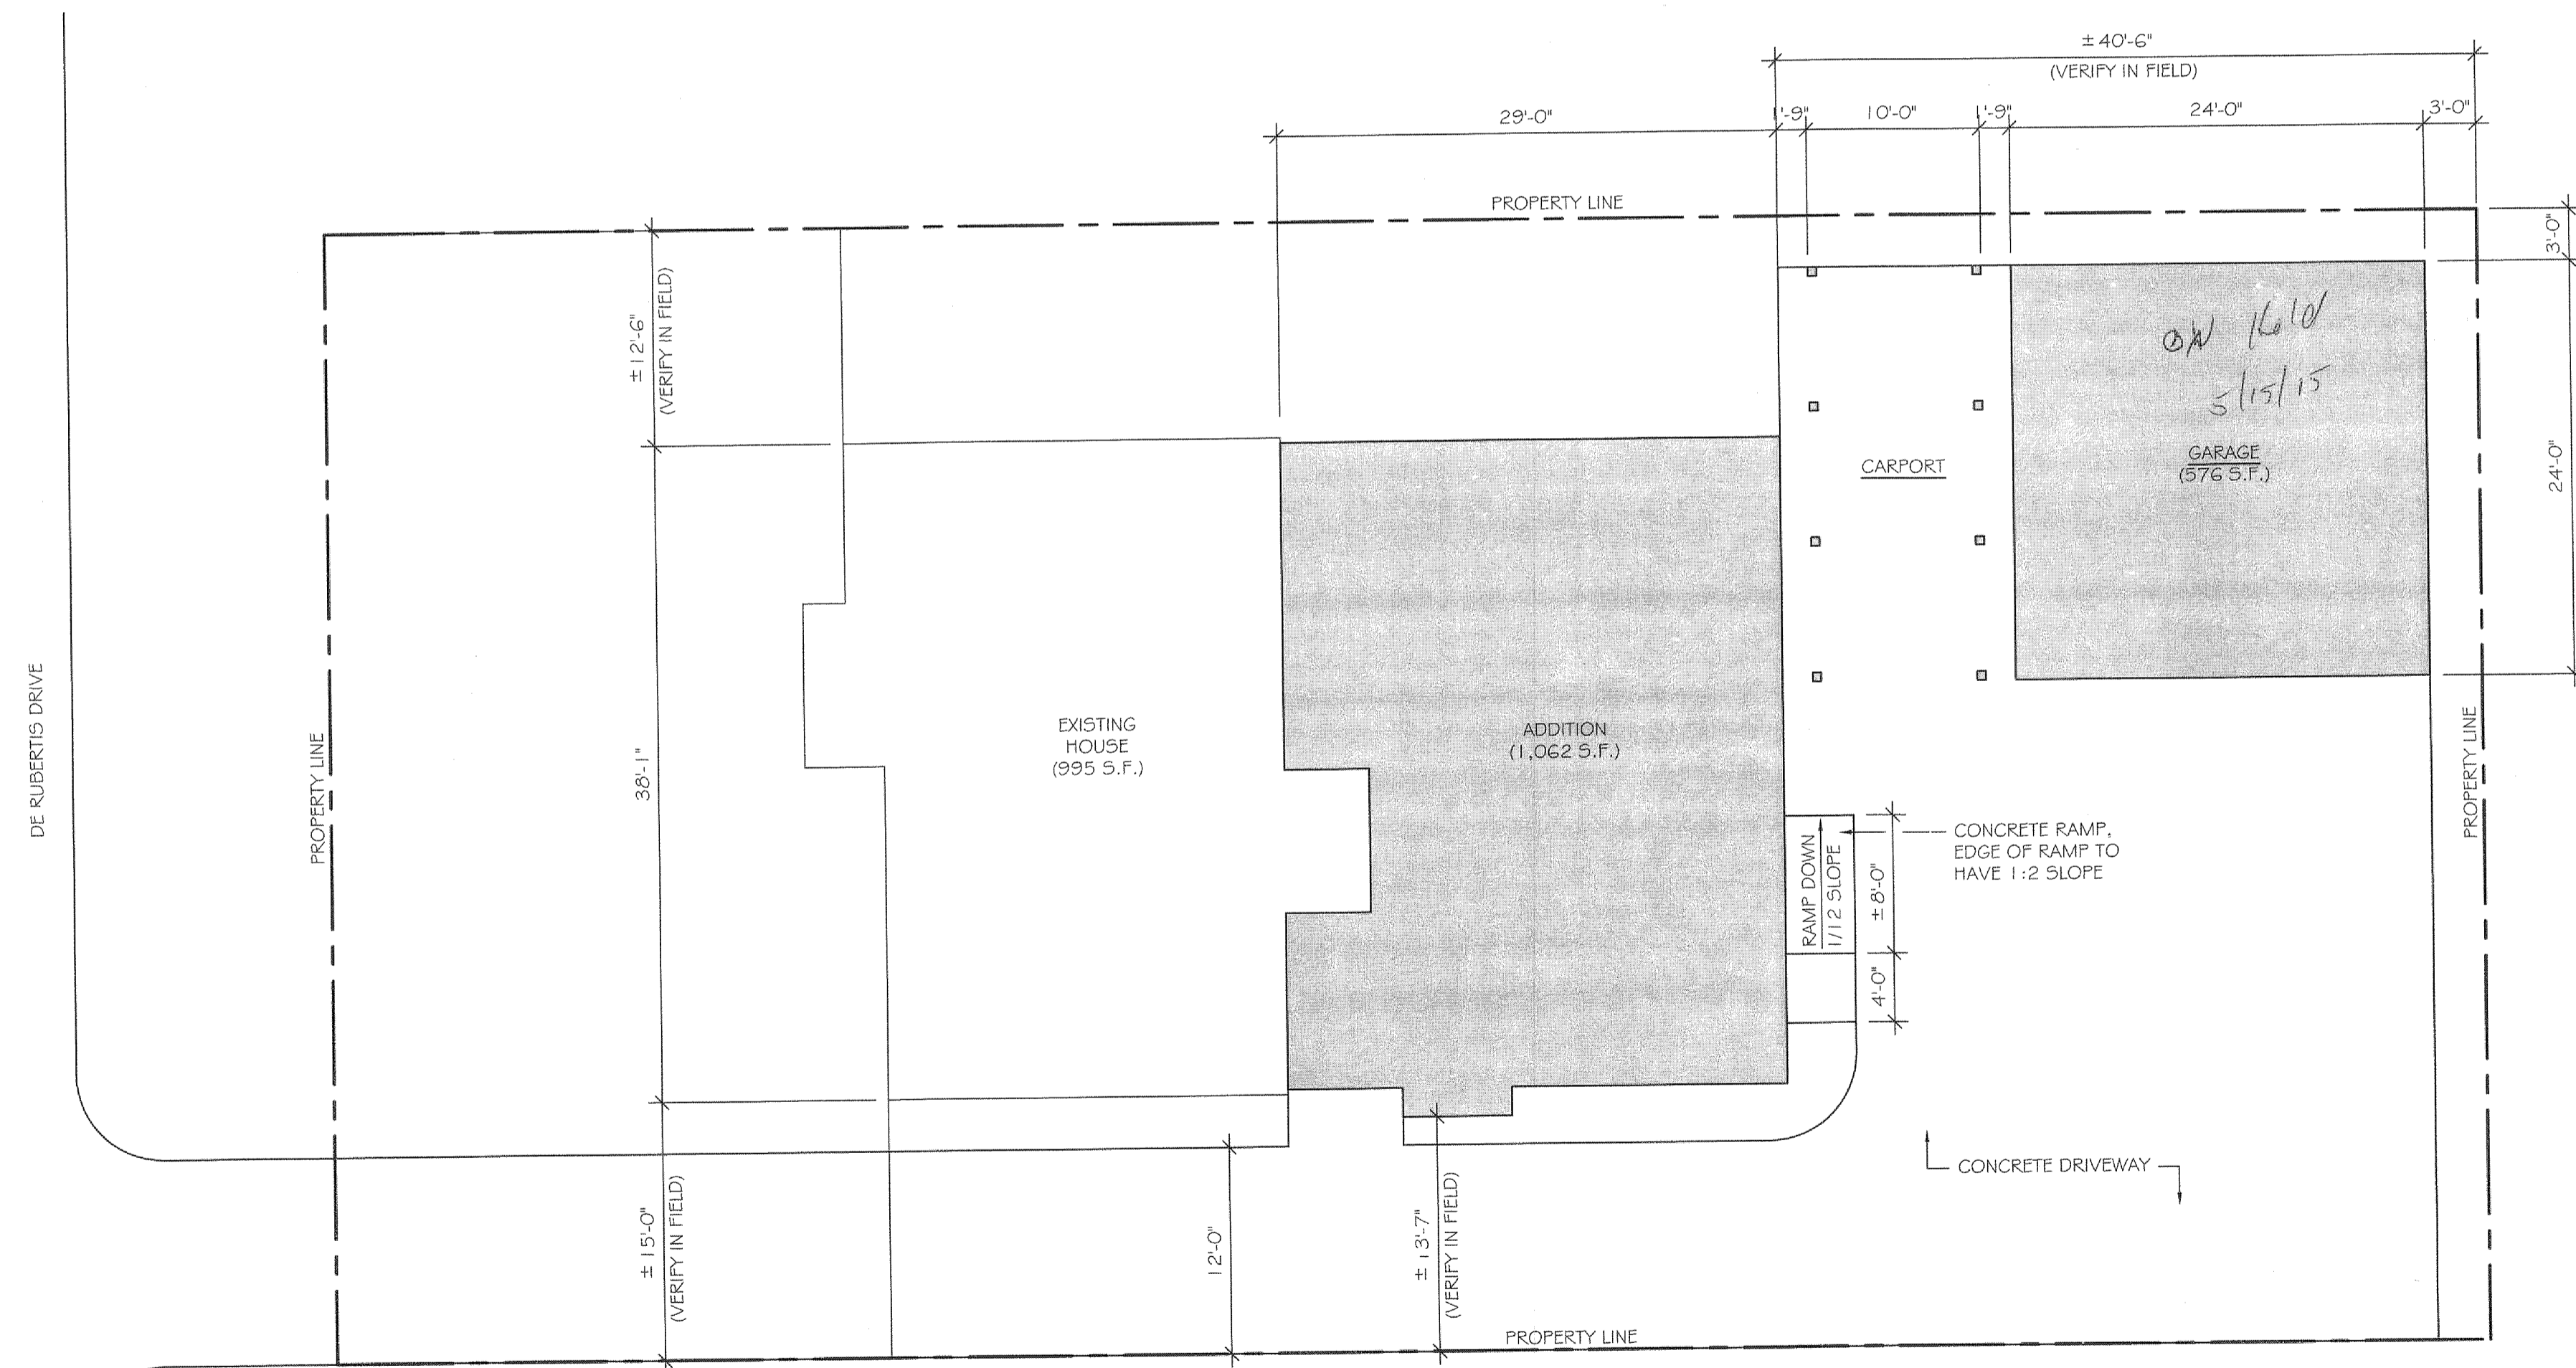

SITE PLAN
SCALE: 1/8" = 1'-0" IN

#2399

BY _____
DATE _____
APPROVED
MADISON TOWNSHIP ZONING
APPROVED
MADISON TOWNSHIP ZONING
DATE 5/15/15
BY SFK Z15-4200
Master Management Plan
Approved as shown and noted
JAMES R. GILLS, P.E.
County Drainage Engineer
By GH Date 5/21/15

ADDITION TO:
PETTIT RESIDENCE
2639 DE RUBERTIS DRIVE
MADISON, OHIO 44057

6650 SOUTH RIVER ROAD
GENEVA, OHIO 44024

J GERGER
ARCHITECTS LLC
JAMES R. GILLS, P.E.
JAMES R. GILLS, P.E.
COUNTY DRAINAGE ENGINEER
EMAIL: JGERGER@ARDOR.COM

AA

Date 3-27-15
Issue For Bid