


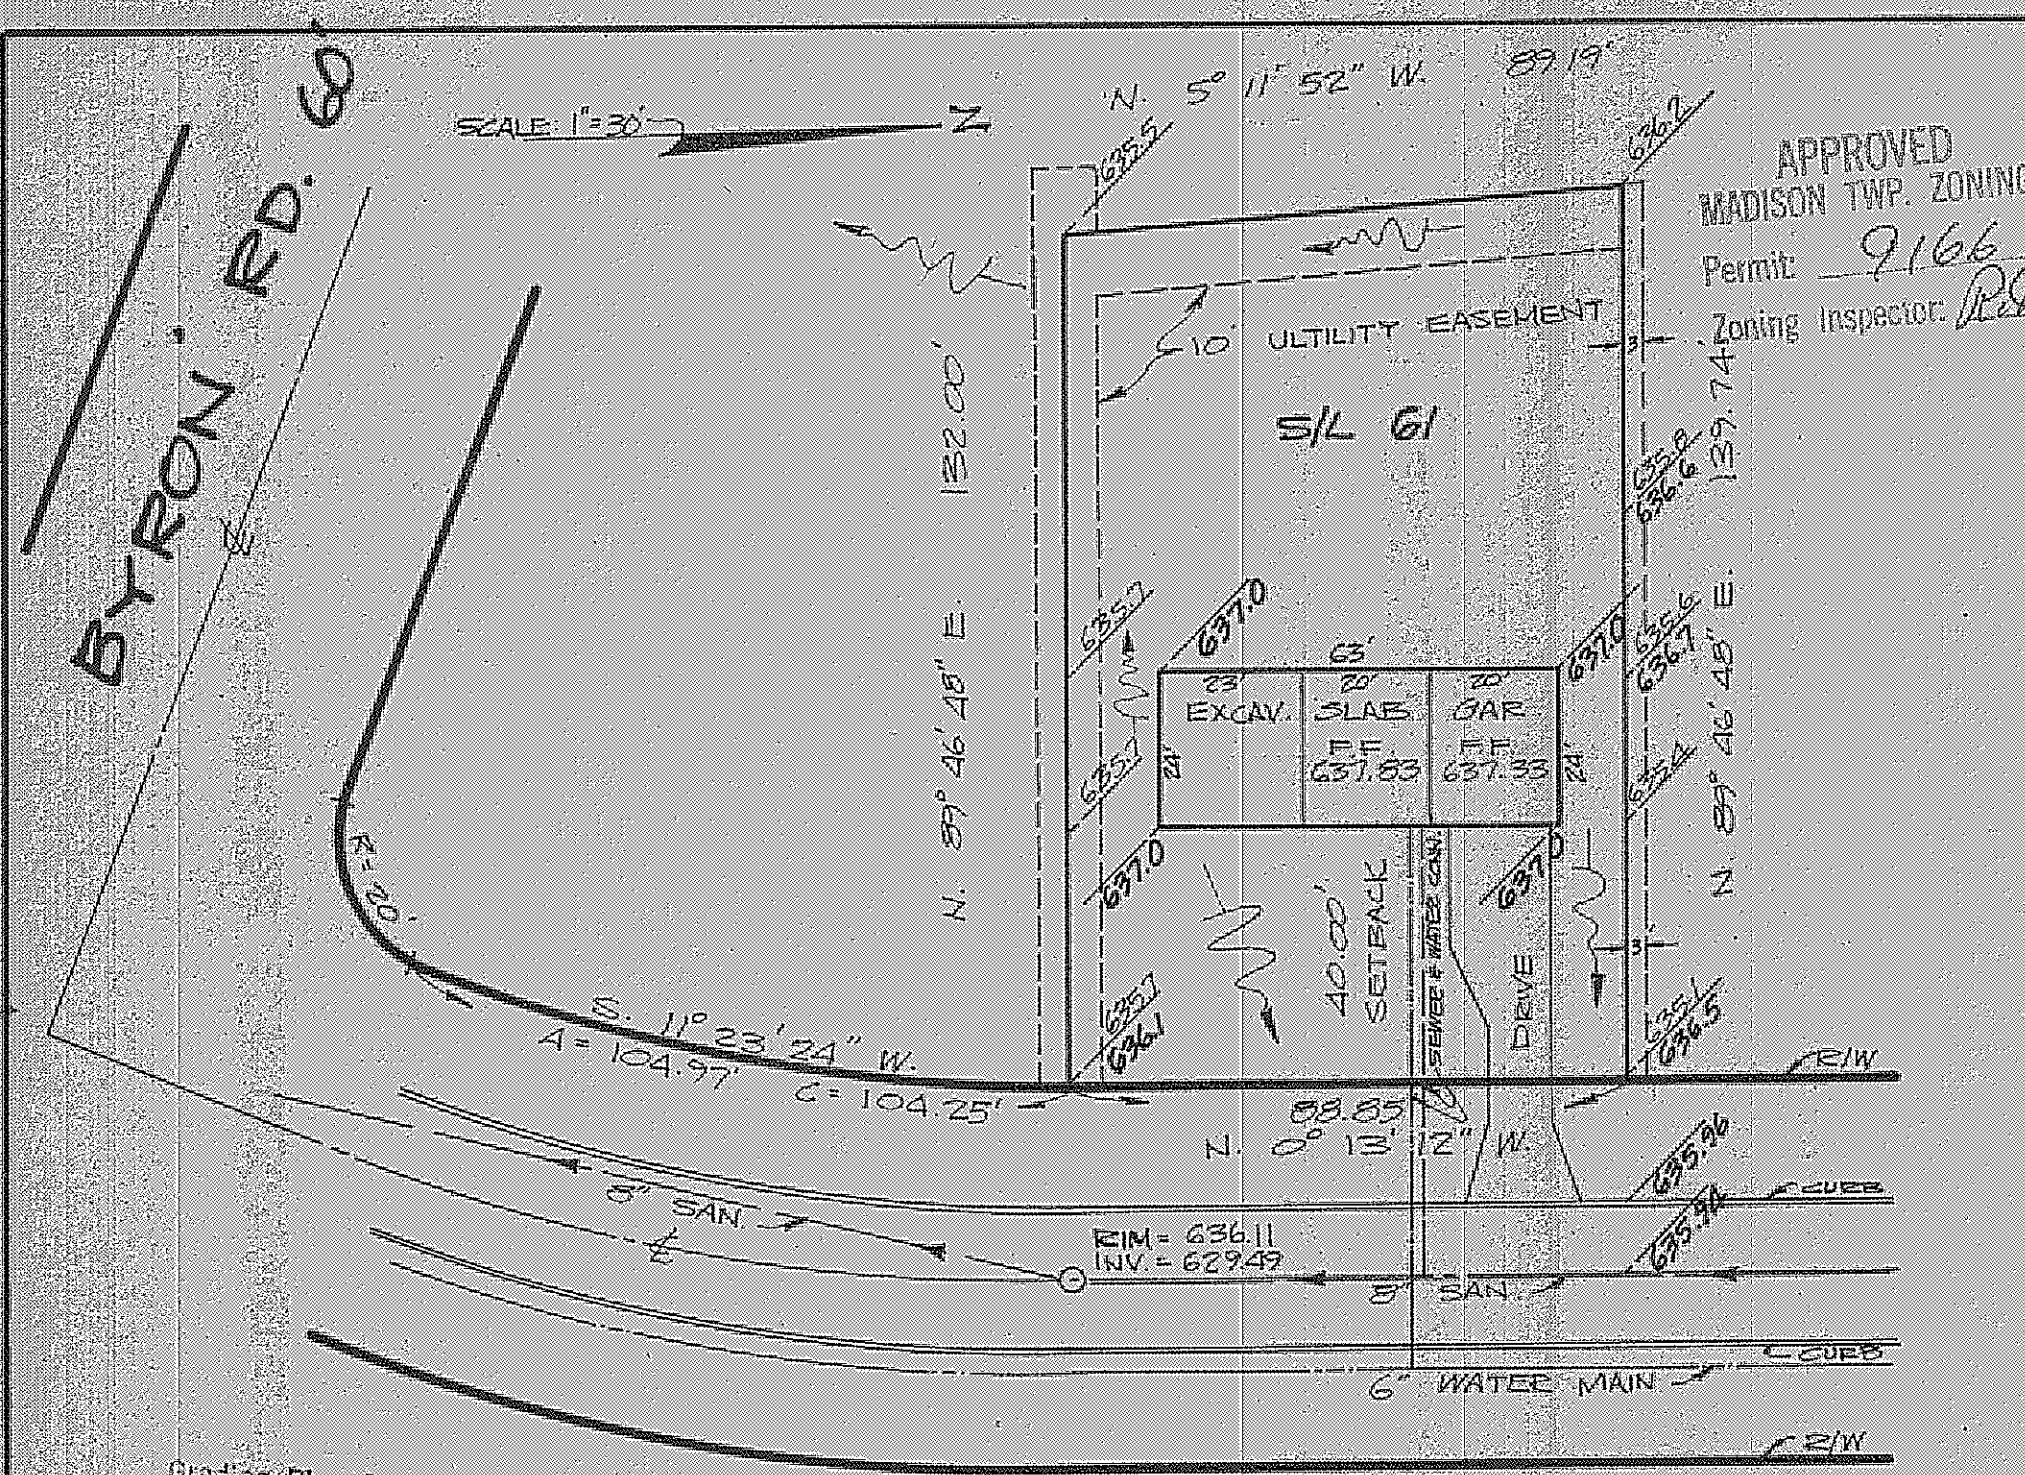

Grading Plan Approved
as shown and/or noted
THOMAS E. GILLES, P.E.
Lake County Engineer

JWK
Date 8-9-74

"AS BUILT" CERTIFICATION
I, HEREBY CERTIFY THAT THE CIRCLED GRADES ARE EXISTING FINISH
GRADES CHECKED IN FIELD ON _____ 19 ____ BY _____
SURVEYING AND ARE CORRECT TO THE BEST OF MY KNOWLEDGE AND BELIEF

REGISTERED SURVEYOR _____ REG. NO. _____

APPROVED
MADISON TWP. ZONING
Permit: 9166
Zoning Inspector: *[Signature]*

SITE PLAN			
MADISON TOWNSHIP		LAKE COUNTY, OHIO	
for: HALLMARK BUILDERS CLIENT OWNER			
ADDRESS	STREET	CITY	ZIP
CHAPEL GROVE SUBDIV. SUBDIVISION 0-14 NAME		LOT	TRACT
# 61 SUBLOT NO.		VOLUME	PAGE
HAMBLEN ST. STREET		PERM. PARCEL #	STREET
LEGEND			
SANITARY MANHOLE		WATER VALVE (GAS)	
STORM MANHOLE		WATER METER (GAS)	
INLET OR CATCH BASIN		AS BUILT ELEVATION	
HYDRANT		INDICATES	
EXISTING CONTOURS		DIRECTION OF	
PROPOSED CONTOURS		SURFACE DRAINAGE	
EXIST. ELEV. 100.0			
100.0 2 PROP ELEV.			
REMARKS			
ALL BOUNDARY DATA SHOWN WAS OBTAINED FROM (DEEDS, RECORDED SUBDIVISION PLAT OR OTHER PUBLIC RECORDS.)			
LOCATIONS AS SHOWN OF ADJACENT WELLS AND SEPTIC TANKS OBTAINED FROM LAKE COUNTY HEALTH DEPARTMENT			
DESIGN CERTIFICATION			
THIS PLAT WAS PREPARED BY ME, AND IS CORRECT TO THE BEST OF MY KNOWLEDGE AND BELIEF.			
NAME		PS# 5244 SURVEYOR REGISTRATION NO.	
CHECK LIST			
NO. OF BEDROOMS		WATER MAIN SIZE LOCATION	
DIMENSIONS		SAN. SEWER SIZE % GR. LOC.	
BEARINGS		SAN. MH CAST ELEV. INV. ELEV.	
TIE TO NEAREST STREET		SAN. CONN. SIZE LOC. DEPTH	
SUBLOT NO. PARCEL NO.		STORM SEWER SIZE % GR. LOC.	
SURROUNDING OWNERS		STORM MH CAST ELEV. INV. ELEV.	
BLDG. DIMENSIONS FIN. GR.		PAVT. TYPE GRADE CURBS	
BLDG. TIES FLR. GRADES		GAS LINE LOC. SIZE PRESSURE	
APRON TYPE WIDTH THICKNESS		SEPTIC TANK LOCATION & DUPLICATION AREA	
SIDEWALK TYPE WIDTH THICKNESS		WELL LOCATION	
CULVERT TYPE DIA. LENGTH		ISOLATION RADIUS FROM WELL	
ROCK OUTCROPPINGS			
REVISIONS		PLAN PREPARED BY:	
NO	DATE	DEBEVEC-SALO & ASSOC, INC.	
1		130 EAST JACKSON ST. PAINESVILLE	
2			
3		DRAWN BY <i>TF</i>	SCALE 1" = 30'
4		CHK'D <i>DJB</i>	DATE 7/25/74
5		CREW CHIEF	PHONE NO.
			DRAWING NO.