
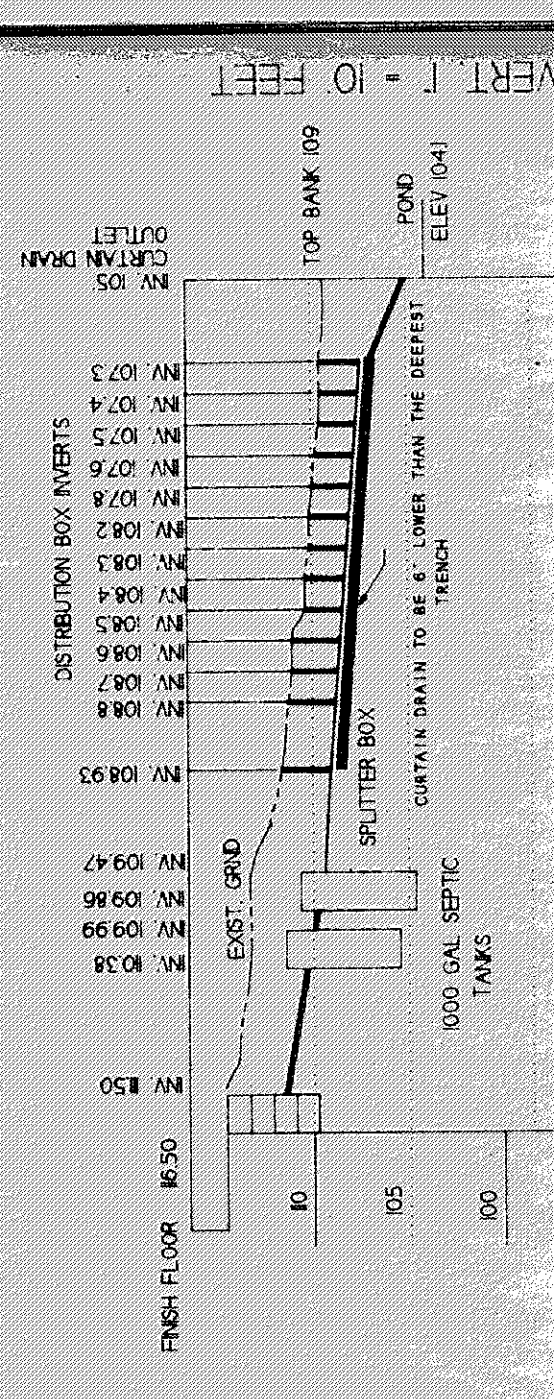


SURVEY AND SITE PLAN

FOR DAN MEDVEC
A 1 STORY 4 BEDROOM FRAME DWELLING
DWELLING ADDRESS


DAVID & EDNA MEDVEC IN LOT 7 TRACT II
TOWNSHIP OF MADISON COUNTY OF LAKE
STATE OF OHIO AS RECORDED IN
VOLUME 742 PAGE 005 IN THE OFFICE
OF THE COUNTY RECORDER

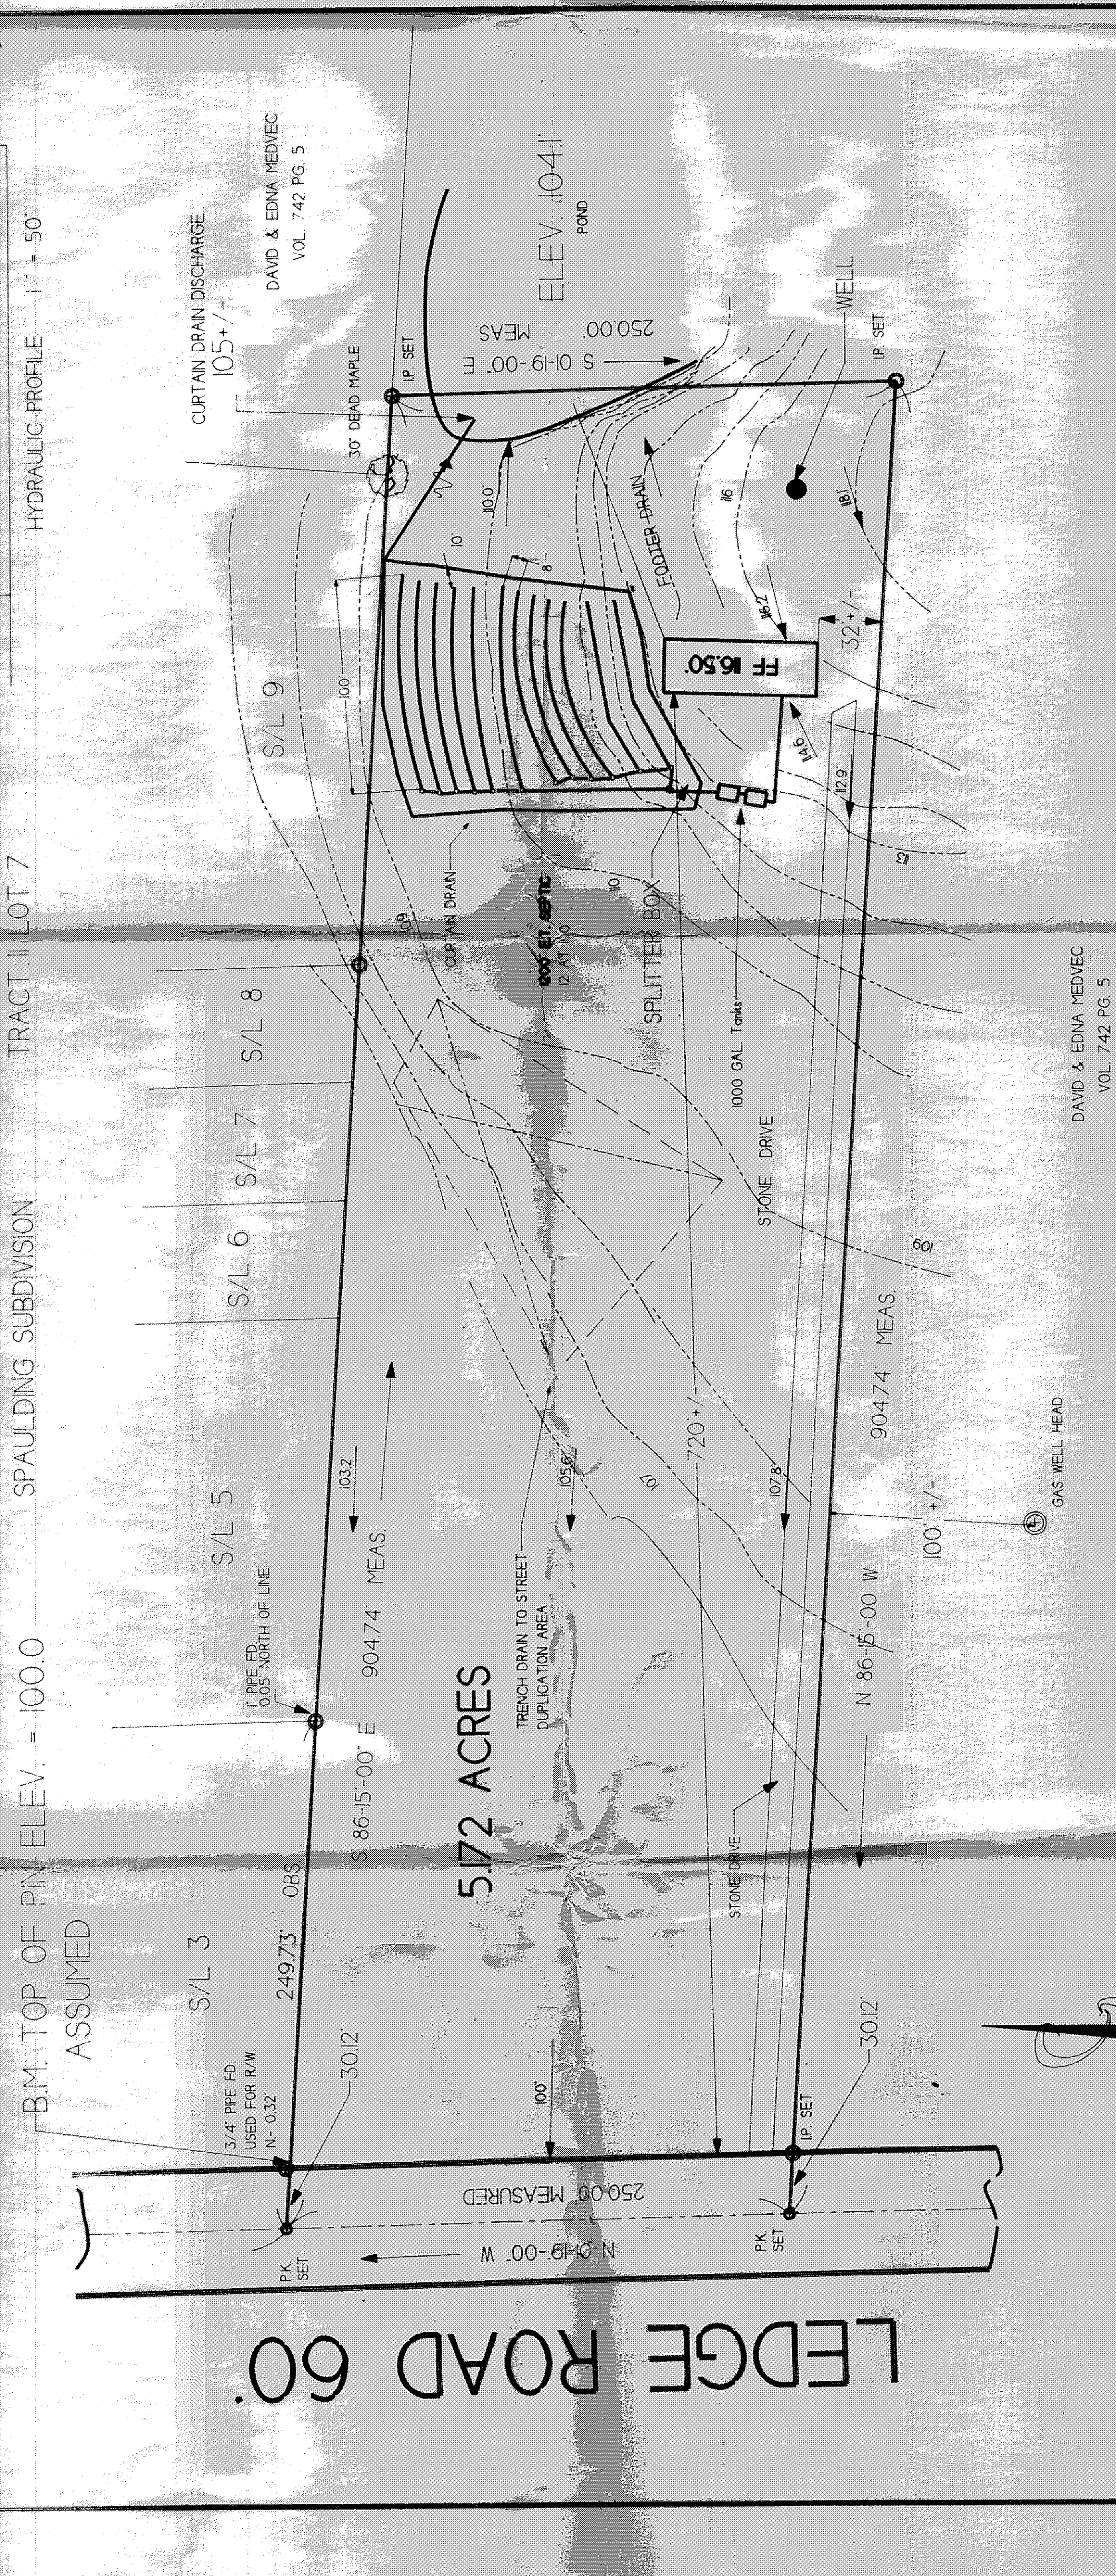


LEGEND

- PK NAIL WITH SHIRKER SET
- IRON PIN MONUMENT
- ⊕ IRON PIPE
- ⊙ MONUMENT BOX
- ⊙ UTILITY POLE
- ➔ RUNOFF DIRECTION
- POWER LINES

BASES OF BEARINGS USED HEREIN
ARE ASSUMED ALONG THE
CENTERLINE OF LEDGE ROAD
SOUTH 01° 19' - 00" EAST

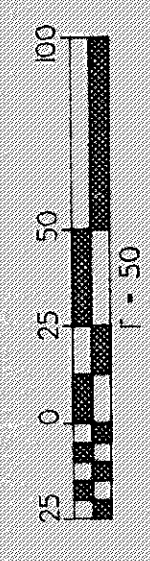

THIS PROPERTY SURVEY IS PURSUANT
TO CHAPTER 4733-37 OF THE OHIO
ADMINISTRATIVE CODE.

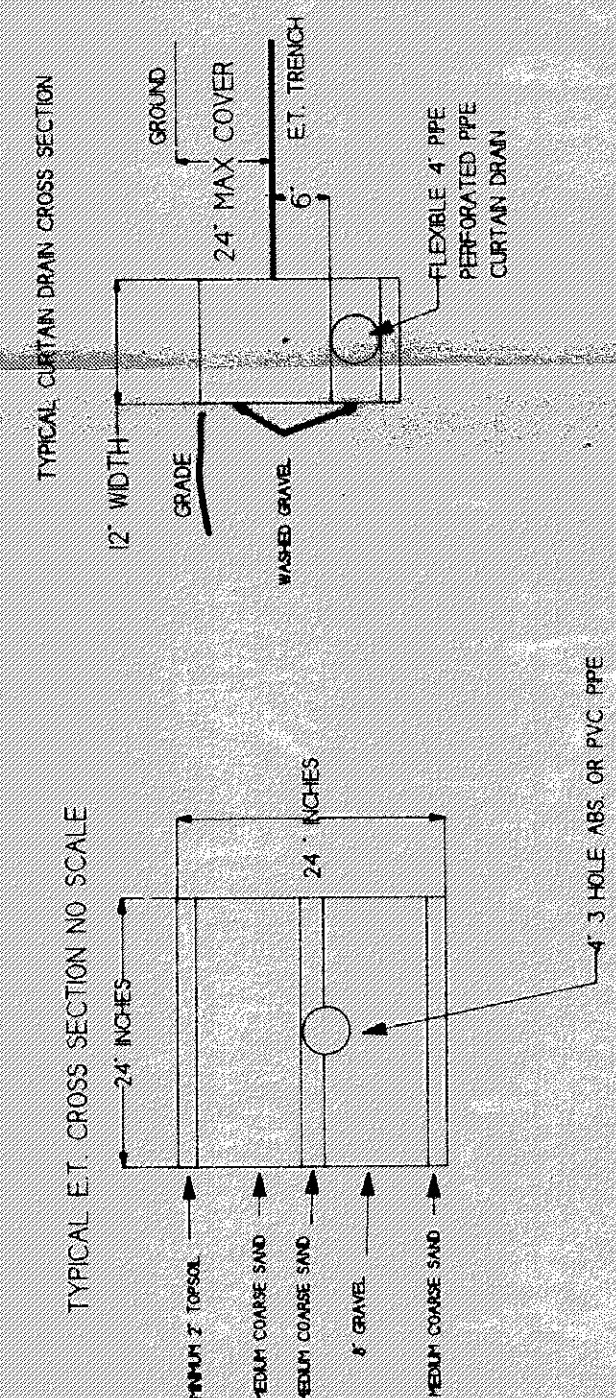

REVISIONS

NO.	DATE	DESCRIPTION
1	SEPT. 94	ISSUED FOR PERMIT

CRABBS'S SURVEYING SERVICE

WESTERN RESERVE BUILDING
708 NORTH ST. CLAR STREET SUIT 100
PARADESILLE OHIO 44077
PHONE 330-3300
FAX 330-337-986
HOURS 8:00-5:00 PM

PROFESSIONAL SURVEYOR

STATE OF OHIO

NO. 7245

JOSEPH E. STODOL

MOSELY E. STODOL P.S. 7245

COPYRIGHT 1994 CRABBS SURVEYING SERVICE

DRAWING NO. 120 TOPO

SHEET NO. 1-1

THE UNDERSIGNED HEREBY CERTIFY THAT THE TOPOGRAPHY
SHOWN HEREON INDICATED BY 1' CONTOURS AND ELEVATIONS
REPRESENTS AN ACTUAL FIELD TOPOGRAPHIC SURVEY
MADE BY ME ON THE 8TH DAY OF APRIL 1994
AND THAT THE ELEVATIONS WERE TAKEN AT APPROPRIATE
INTERVALS AND THAT AS OF THAT DATE THEY
EXISTED AS INDICATED HEREON

- A. To be brought to finished grade
1. Septic tank manhole covers
 2. Splitter box cover
 3. Distribution box cover
- B. No lower drains or downspouts
to be discharged into septic tanks
- C. All waste water to be discharged into
septic tanks

Reviewed and Accepted

LAKE COUNTY GENERAL HEALTH DISTRICT

Date 7-15-94

JOEL LUDAS, R.S., M.P.H.
Health Commissioner

BY J. Ludas

- LOW YIELD WATER
FIXTURES REQUIRED
ON ALL:
- Shower Head
 - Toilet

SEWAGE DISPOSAL PERMIT MUST BE
OBTAINED BY A LAKE COUNTY LICENSED
INSTALLER BEFORE INSTALLATION IS
STARTED.

APPROVED
MADISON TWP. ZONING
Planning Commission
07/13/94

Grading Plan Approved
as shown and/or noted
THOMAS P. GILLES, P.E.
Lake County Engineer
By G.H. Date 7-15-94

15" MINIMUM DRIVE CURB