


2P # 9729  
Grading Plan Approved  
as shown and/or noted  
THOMAS P. GILLES, P.E.  
Lake County Engineer  
*JWG* Date 10-4-76

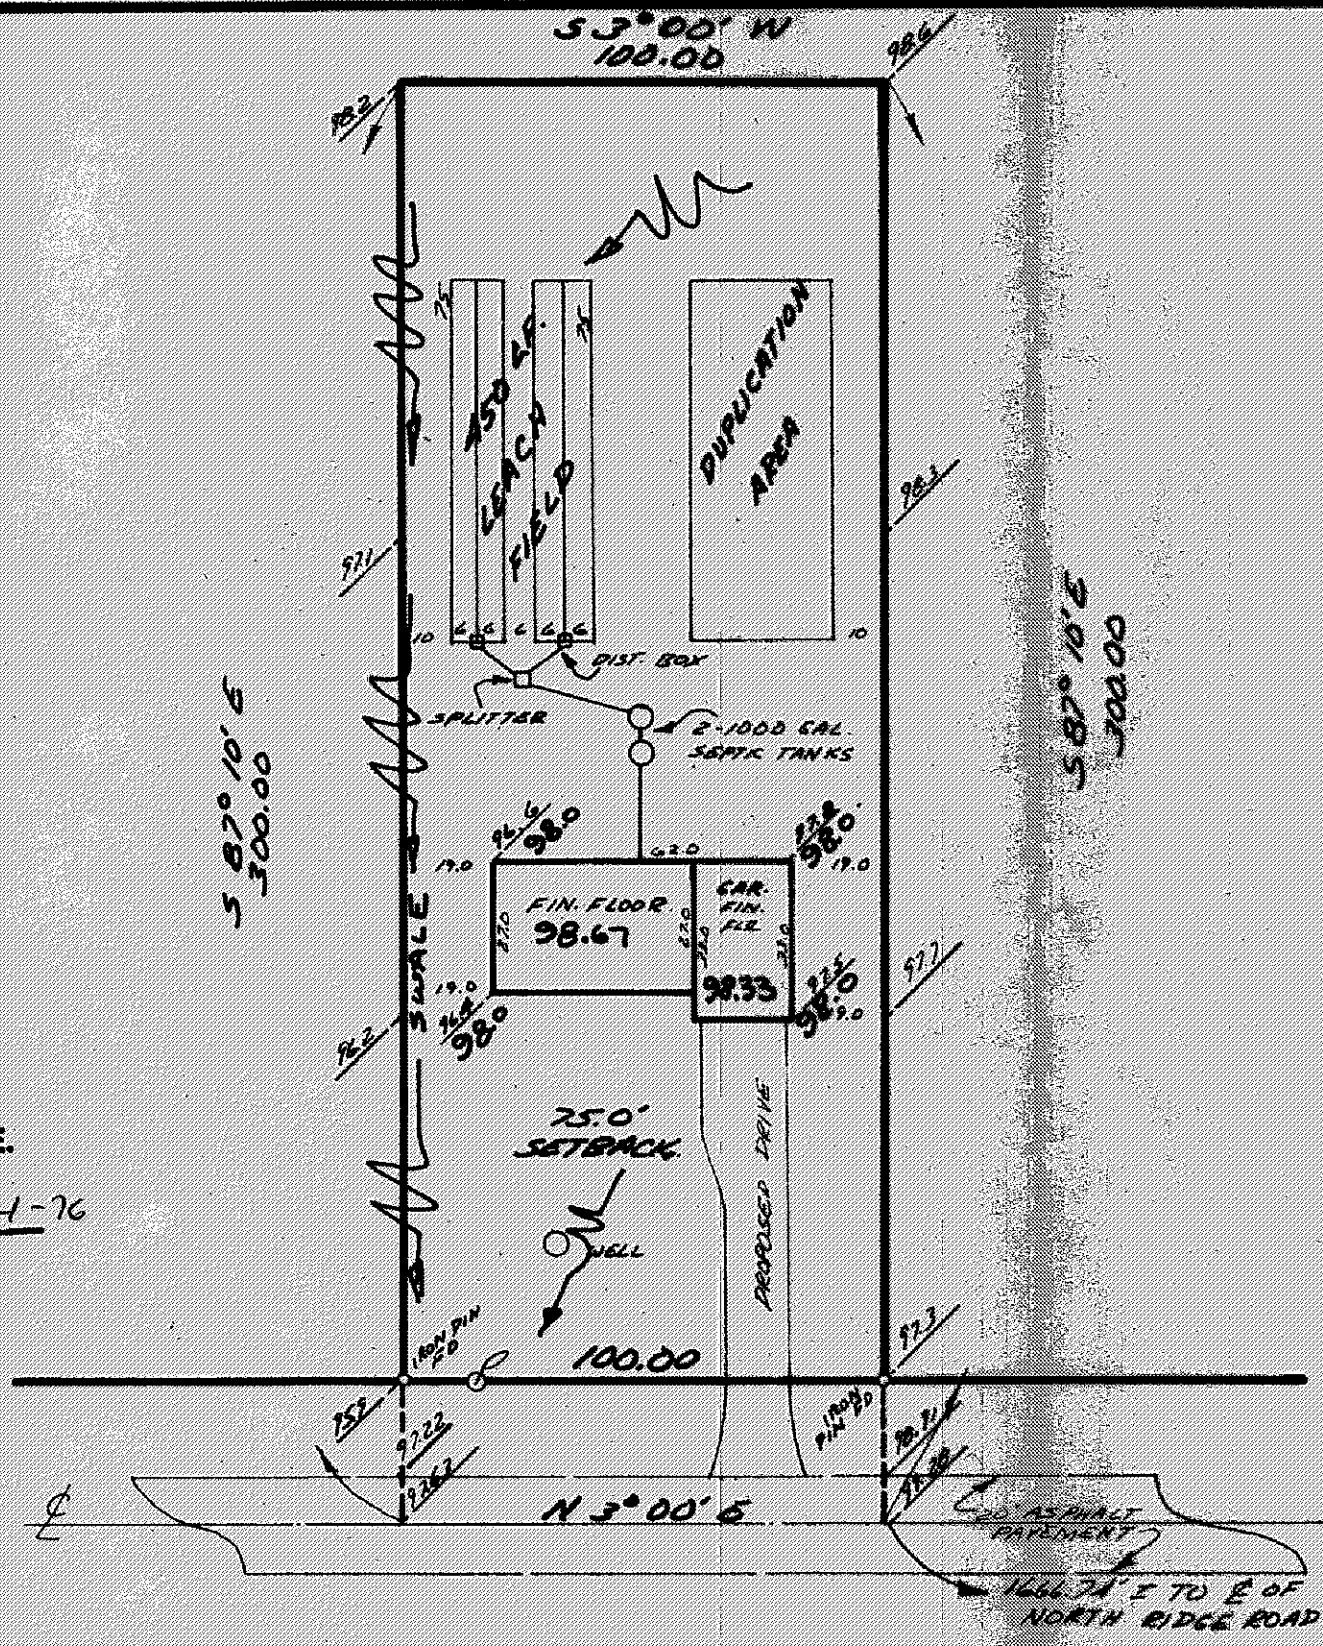

27 89 **McMACKIN ROAD 60' "AS BUILT" CERTIFICATION**  
I, HEREBY CERTIFY THAT THE CIRCLED GRADES ARE EXISTING FINISH  
GRADES CHECKED IN FIELD ON 19 BY  
SURVEYING AND ARE CORRECT TO THE BEST OF MY KNOWLEDGE AND BELIEF.

REGISTERED SURVEYOR \_\_\_\_\_ REG. NO. \_\_\_\_\_

# SITE PLAN

**MADISON** TOWNSHIP LAKE COUNTY, OHIO  
for: **LAKE SIDE BUILDERS**  
CLIENT OWNER

ADDRESS		STREET	CITY	ZIP
SUBDIVISION	NAME	LOT	TRACT	
VOL. - PG.		VOLUME	PAGE	
SUBLOT NO.		STREET	PERM. PARCEL NO.	STREET

**LEGEND**

SANITARY MANHOLE	-----○-----	WATER VALVE (GAS)	-----○-----
STORM MANHOLE	-----●-----	WATER METER (GAS)	-----○-----
INLET OR CATCH BASIN	-----■-----	AS BUILT ELEVATION	100.0
HYDRANT	-----○-----	INDICATES DIRECTION OF SURFACE DRAINAGE	↓
EXISTING CONTOURS	-----		
PROPOSED CONTOURS	-----		
EXIST. ELEV.	100.0	PROP. ELEV.	100.0

**REMARKS**  
ALL BOUNDARY DATA SHOWN WAS OBTAINED FROM (DEEDS, RECORDED SUBDIVISION PLAT OR OTHER PUBLIC RECORDS),  
LOCATIONS AS SHOWN OF ADJACENT WELLS AND SEPTIC TANKS OBTAINED FROM LAKE COUNTY HEALTH DEPARTMENT

**DESIGN CERTIFICATION**  
THIS PLAN WAS PREPARED BY ME, AND IS CORRECT TO THE BEST OF MY KNOWLEDGE AND BELIEF.  
*Richard J. Debevec* PS 5244  
NAME SURVEYOR REGISTRATION NO.

CHECK LIST	
NO. OF BEDROOMS	WATER MAIN SIZE, LOCATION
DIMENSIONS	SAN. SEWER SIZE & GR. LOC.
BEARINGS	SAN. MH. CAST. ELEV. INV. ELEV.
TIE TO NEAREST STREET	SAN. CONN. SIZE, LOC. DEPTH
SUBLOT NO. PARCEL NO.	STORM SEWER SIZE & GR. LOC.
SURROUNDING OWNERS	STORM MH. CAST. ELEV. INV. ELEV.
BLDG. DIMENSIONS FIN. GR.	PAV'T TYPE GRADE CURBS
BLDG. TIES FL'R. GRADES	GAS LINE LOC. SIZE PRESSURE
APRON TYPE WIDTH THICKNESS	SEPTIC TANK LOCATION & DUPLICATION AREA
SIDEWALK TYPE WIDTH THICKNESS	WELL LOCATION
CULVERT TYPE DIA., LENGTH	ISOLATION RADIUS FROM WELL
ROCK OUTCROPPINGS	

REVISIONS			PLAN PREPARED BY:	
NO.	DATE	BY	<b>DEBEVEC - SALO &amp; ASSOCIATES, INC.</b>	
1			130 EAST JACKSON ST. PAINESVILLE, OHIO	
2			DRAWN BY <i>LD</i>	SCALE 1"=40'
3			CHK'D. <i>RJB</i>	DATE 9-14-76
4			CREW CHIEF <i>JWG</i>	APP'D. <i>JWG</i>
5				PHONE NO. 352-9250
				DRAWING NO. 4715