
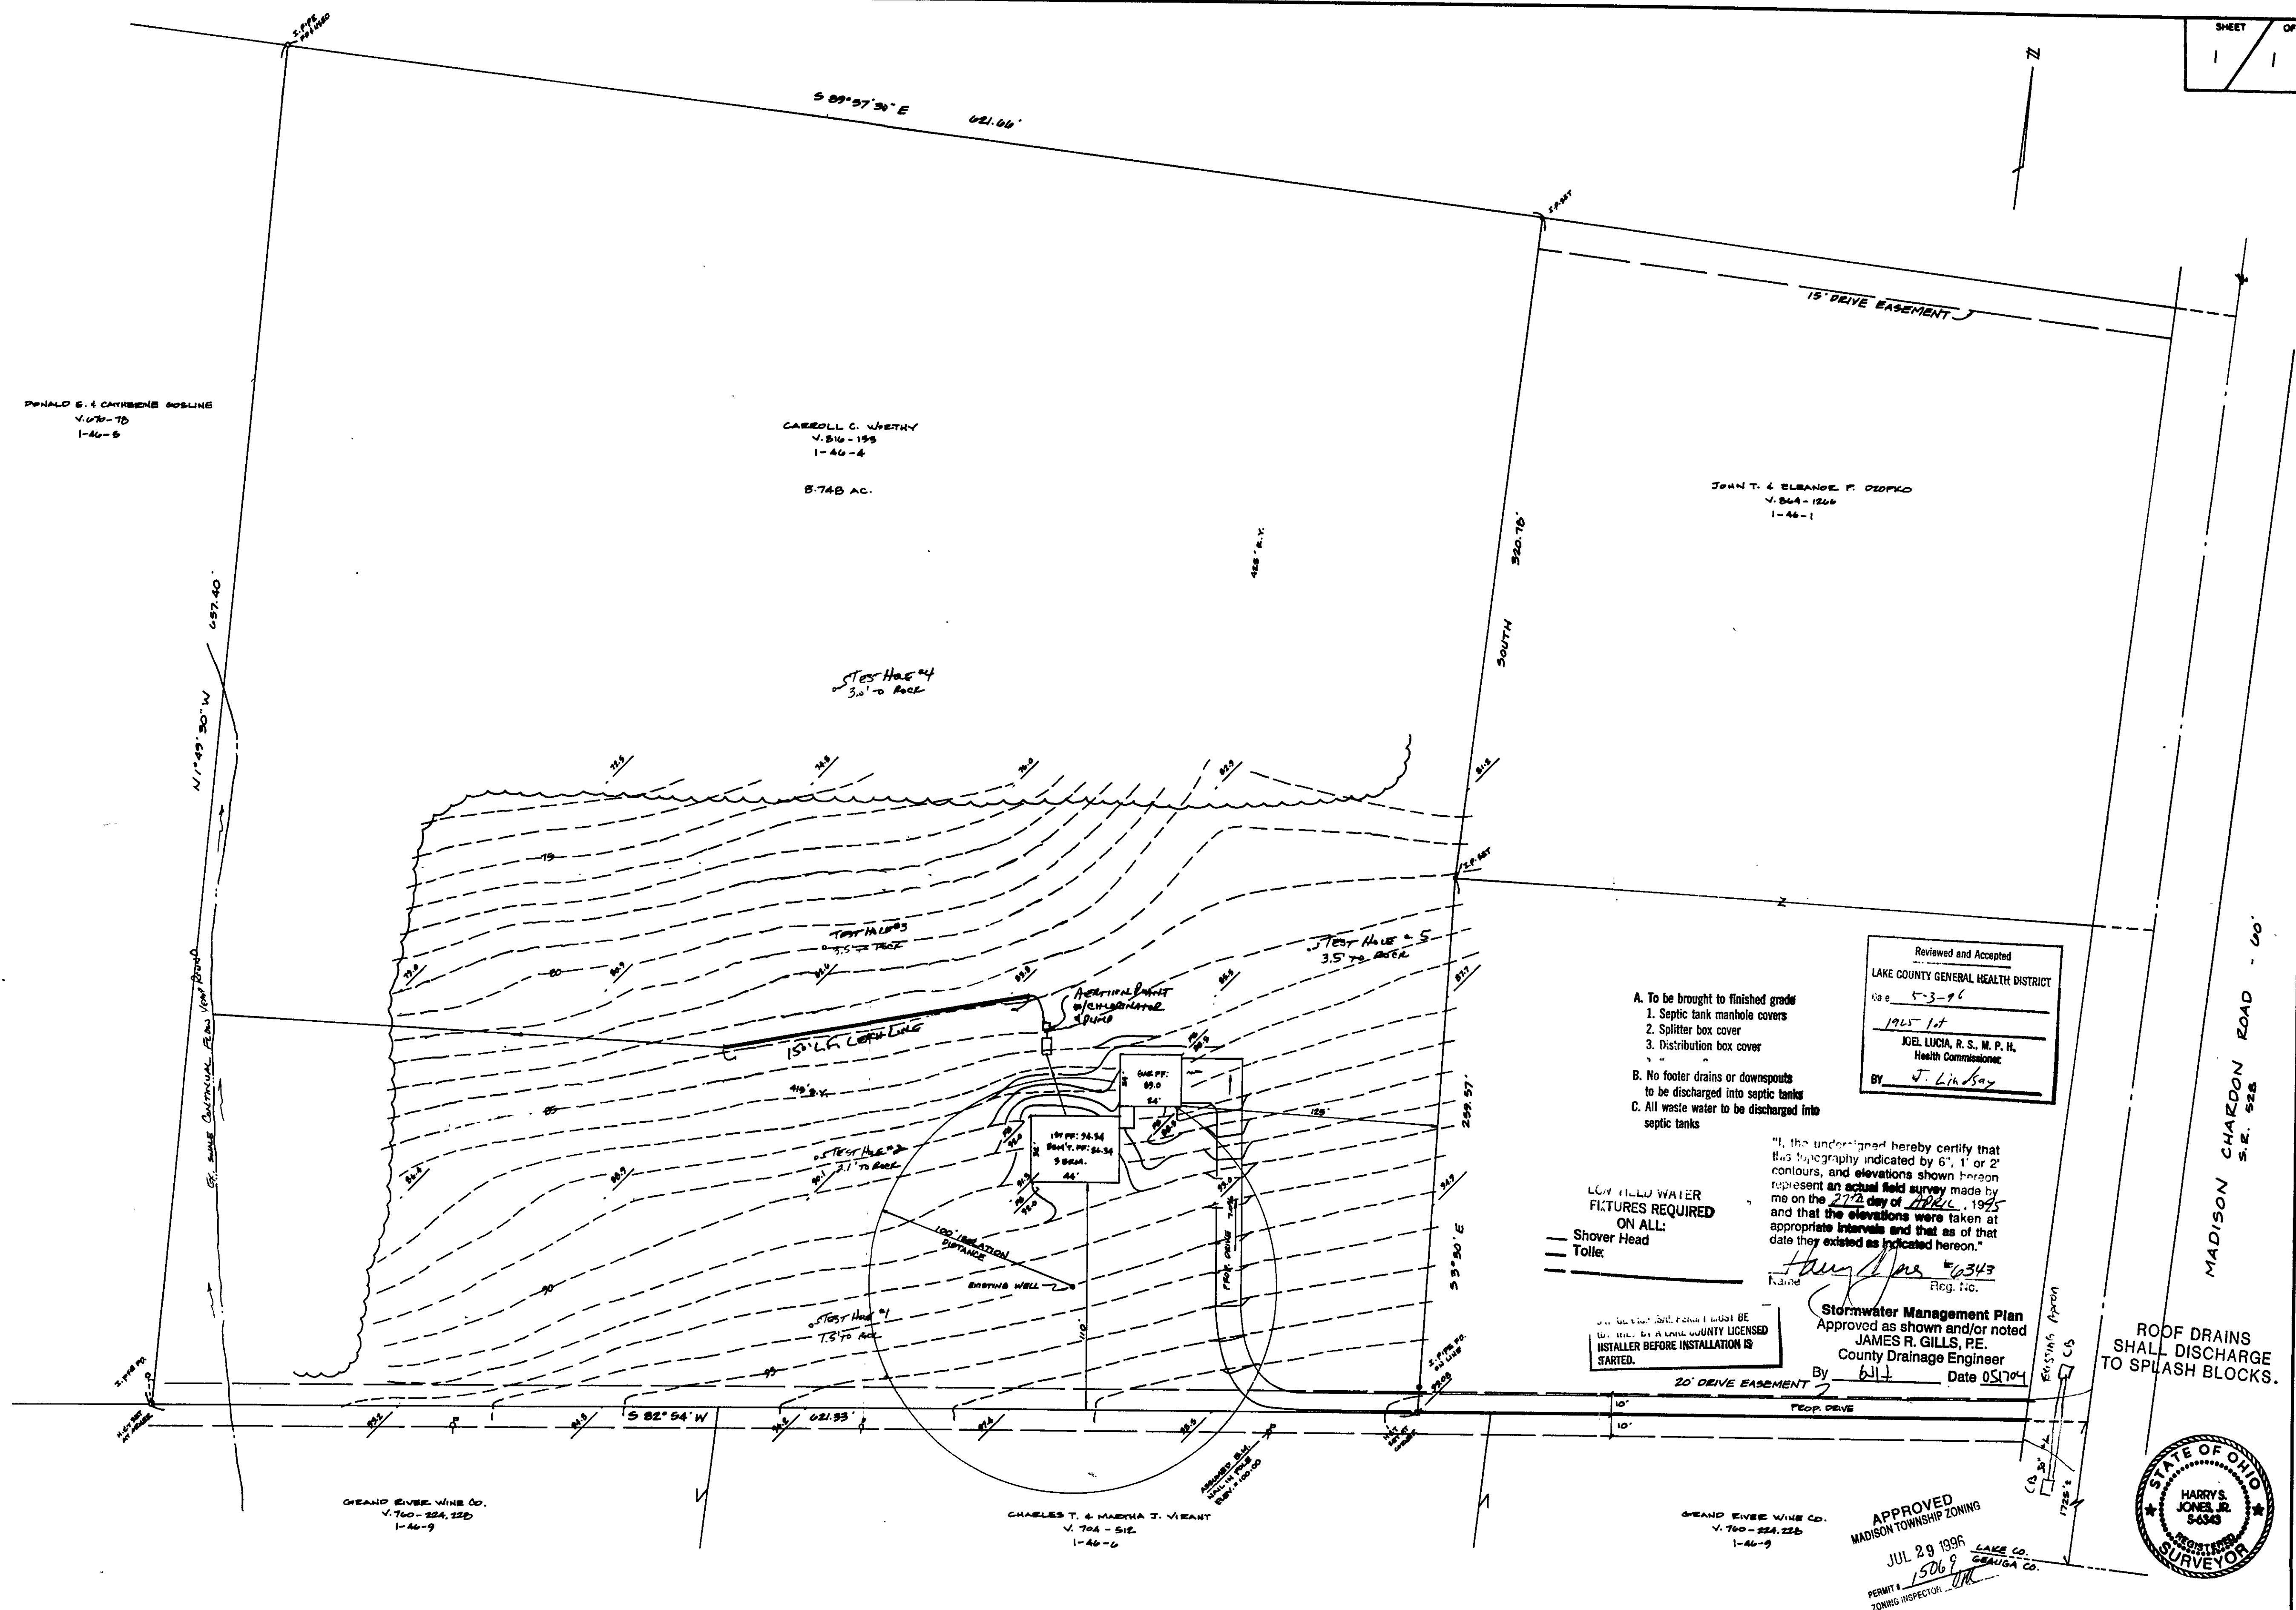
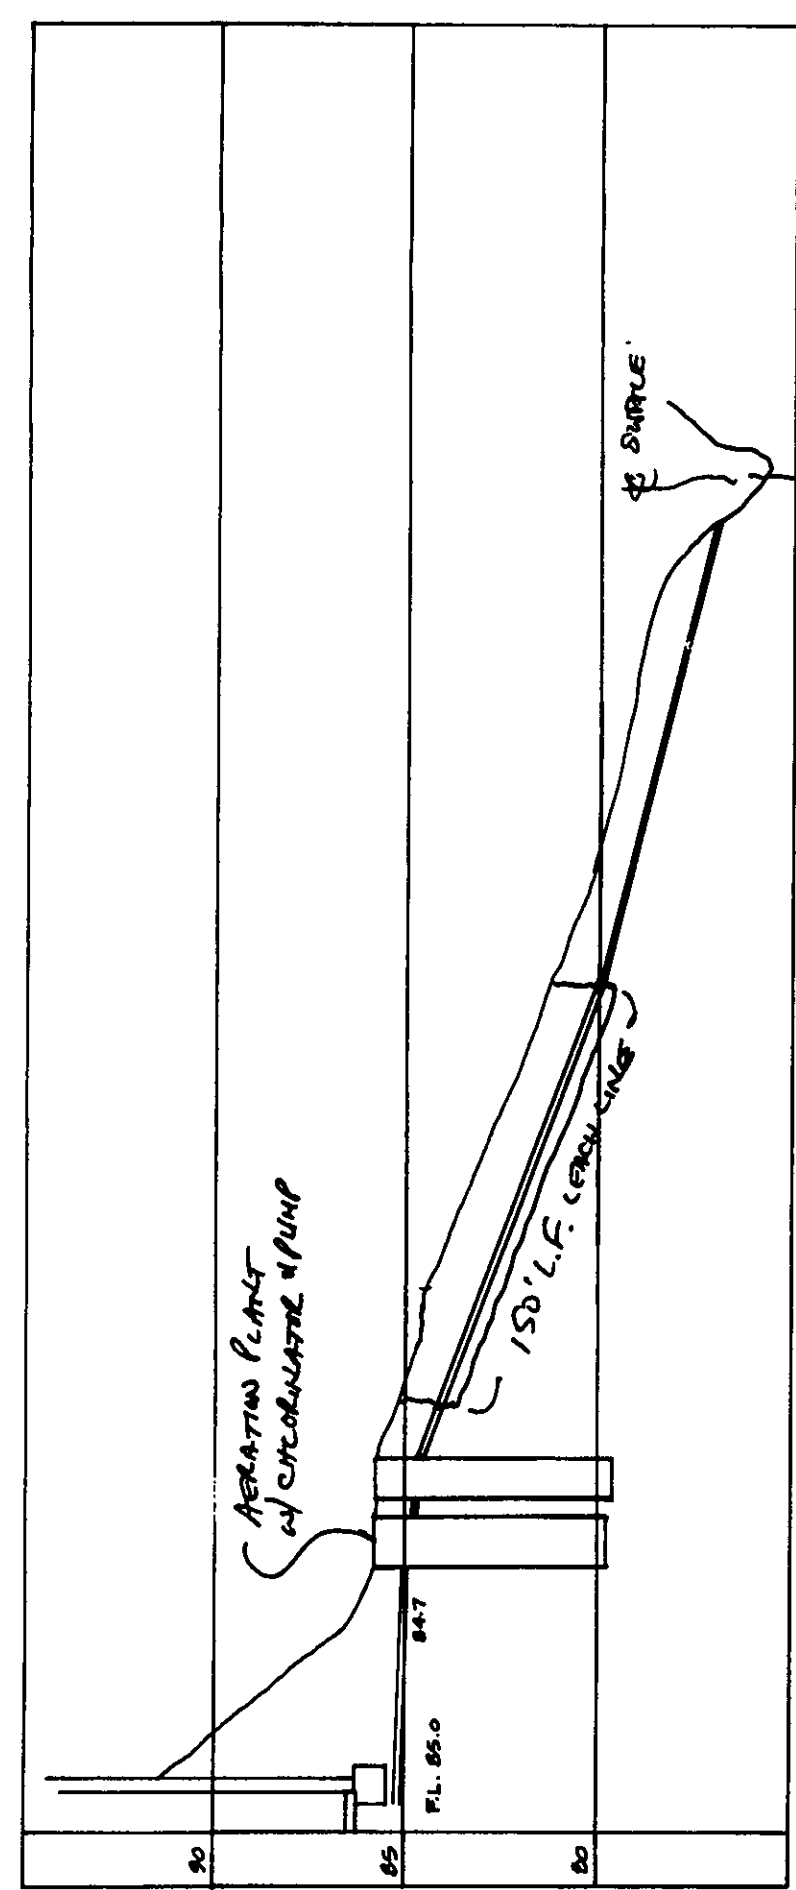


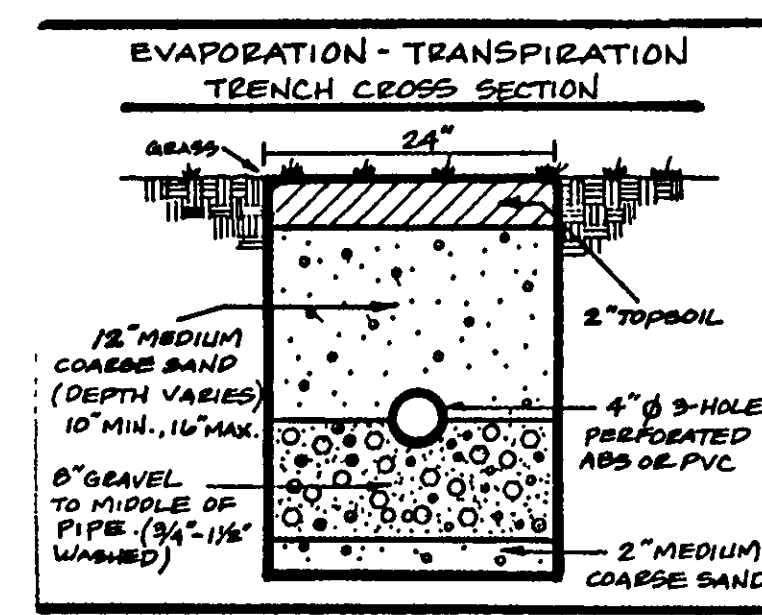

REV. NO.	DESCRIPTION	DATE	BY	CHKD
1	REVISED SEPTIC SYSTEM	4-28-76	HT	HT

SITE PLAN
FOR
DON JACOBSON

bj **BABCOCK, JONES AND ASSOCIATES, INC.**
CIVIL ENGINEERS - SURVEYORS - LAND PLANNERS
PAINESVILLE OHIO 44077

DATE 5/3/95
DESIGN BY HT
DRAWN BY HT
APPROVED BY HT

BEING A PART OF ORIGINAL LOT 3, TRACT 11 MADISON TOWNSHIP
LAKE COUNTY, OHIO
PP # 1-46-4 V. 516-153

SCALE 1\"/>

