







REVIEWED AND ACCEPTED
LAKE COUNTY GENERAL
HEALTH DISTRICT

Date 8-26-03 BY David B. Norris P.E.

*a sewer permit will not be issued
until the above is approved*
SEWER DISPOSAL PERMIT MUST BE
OBTAINED BY A LAKE COUNTY LICENSED
INSTALLER BEFORE INSTALLATION IS
STARTED

Vacant Lot

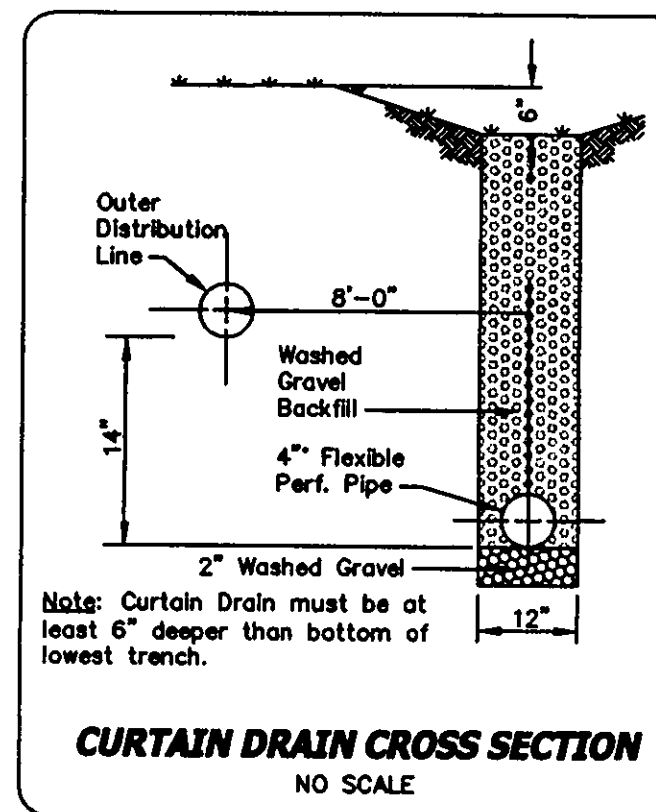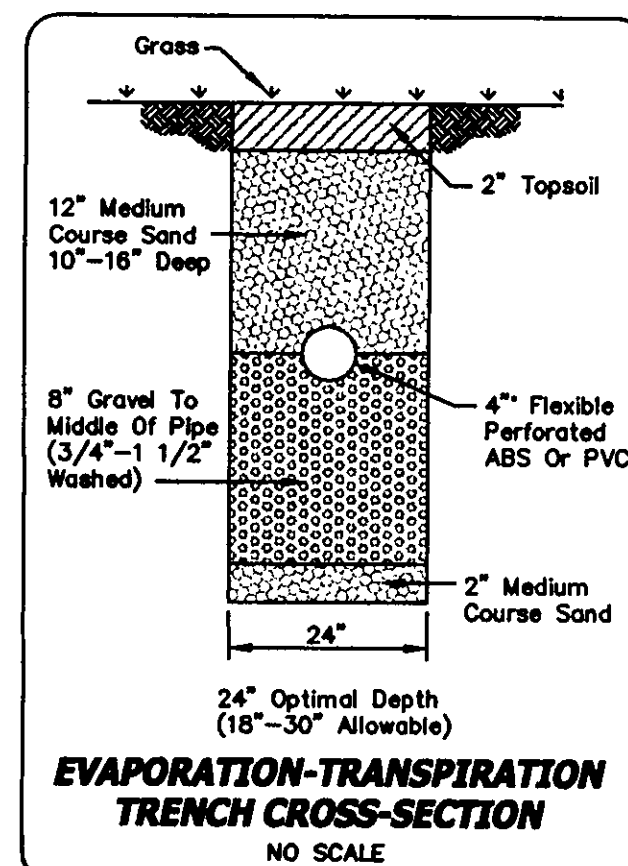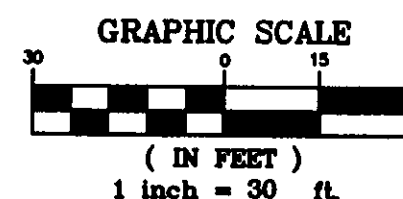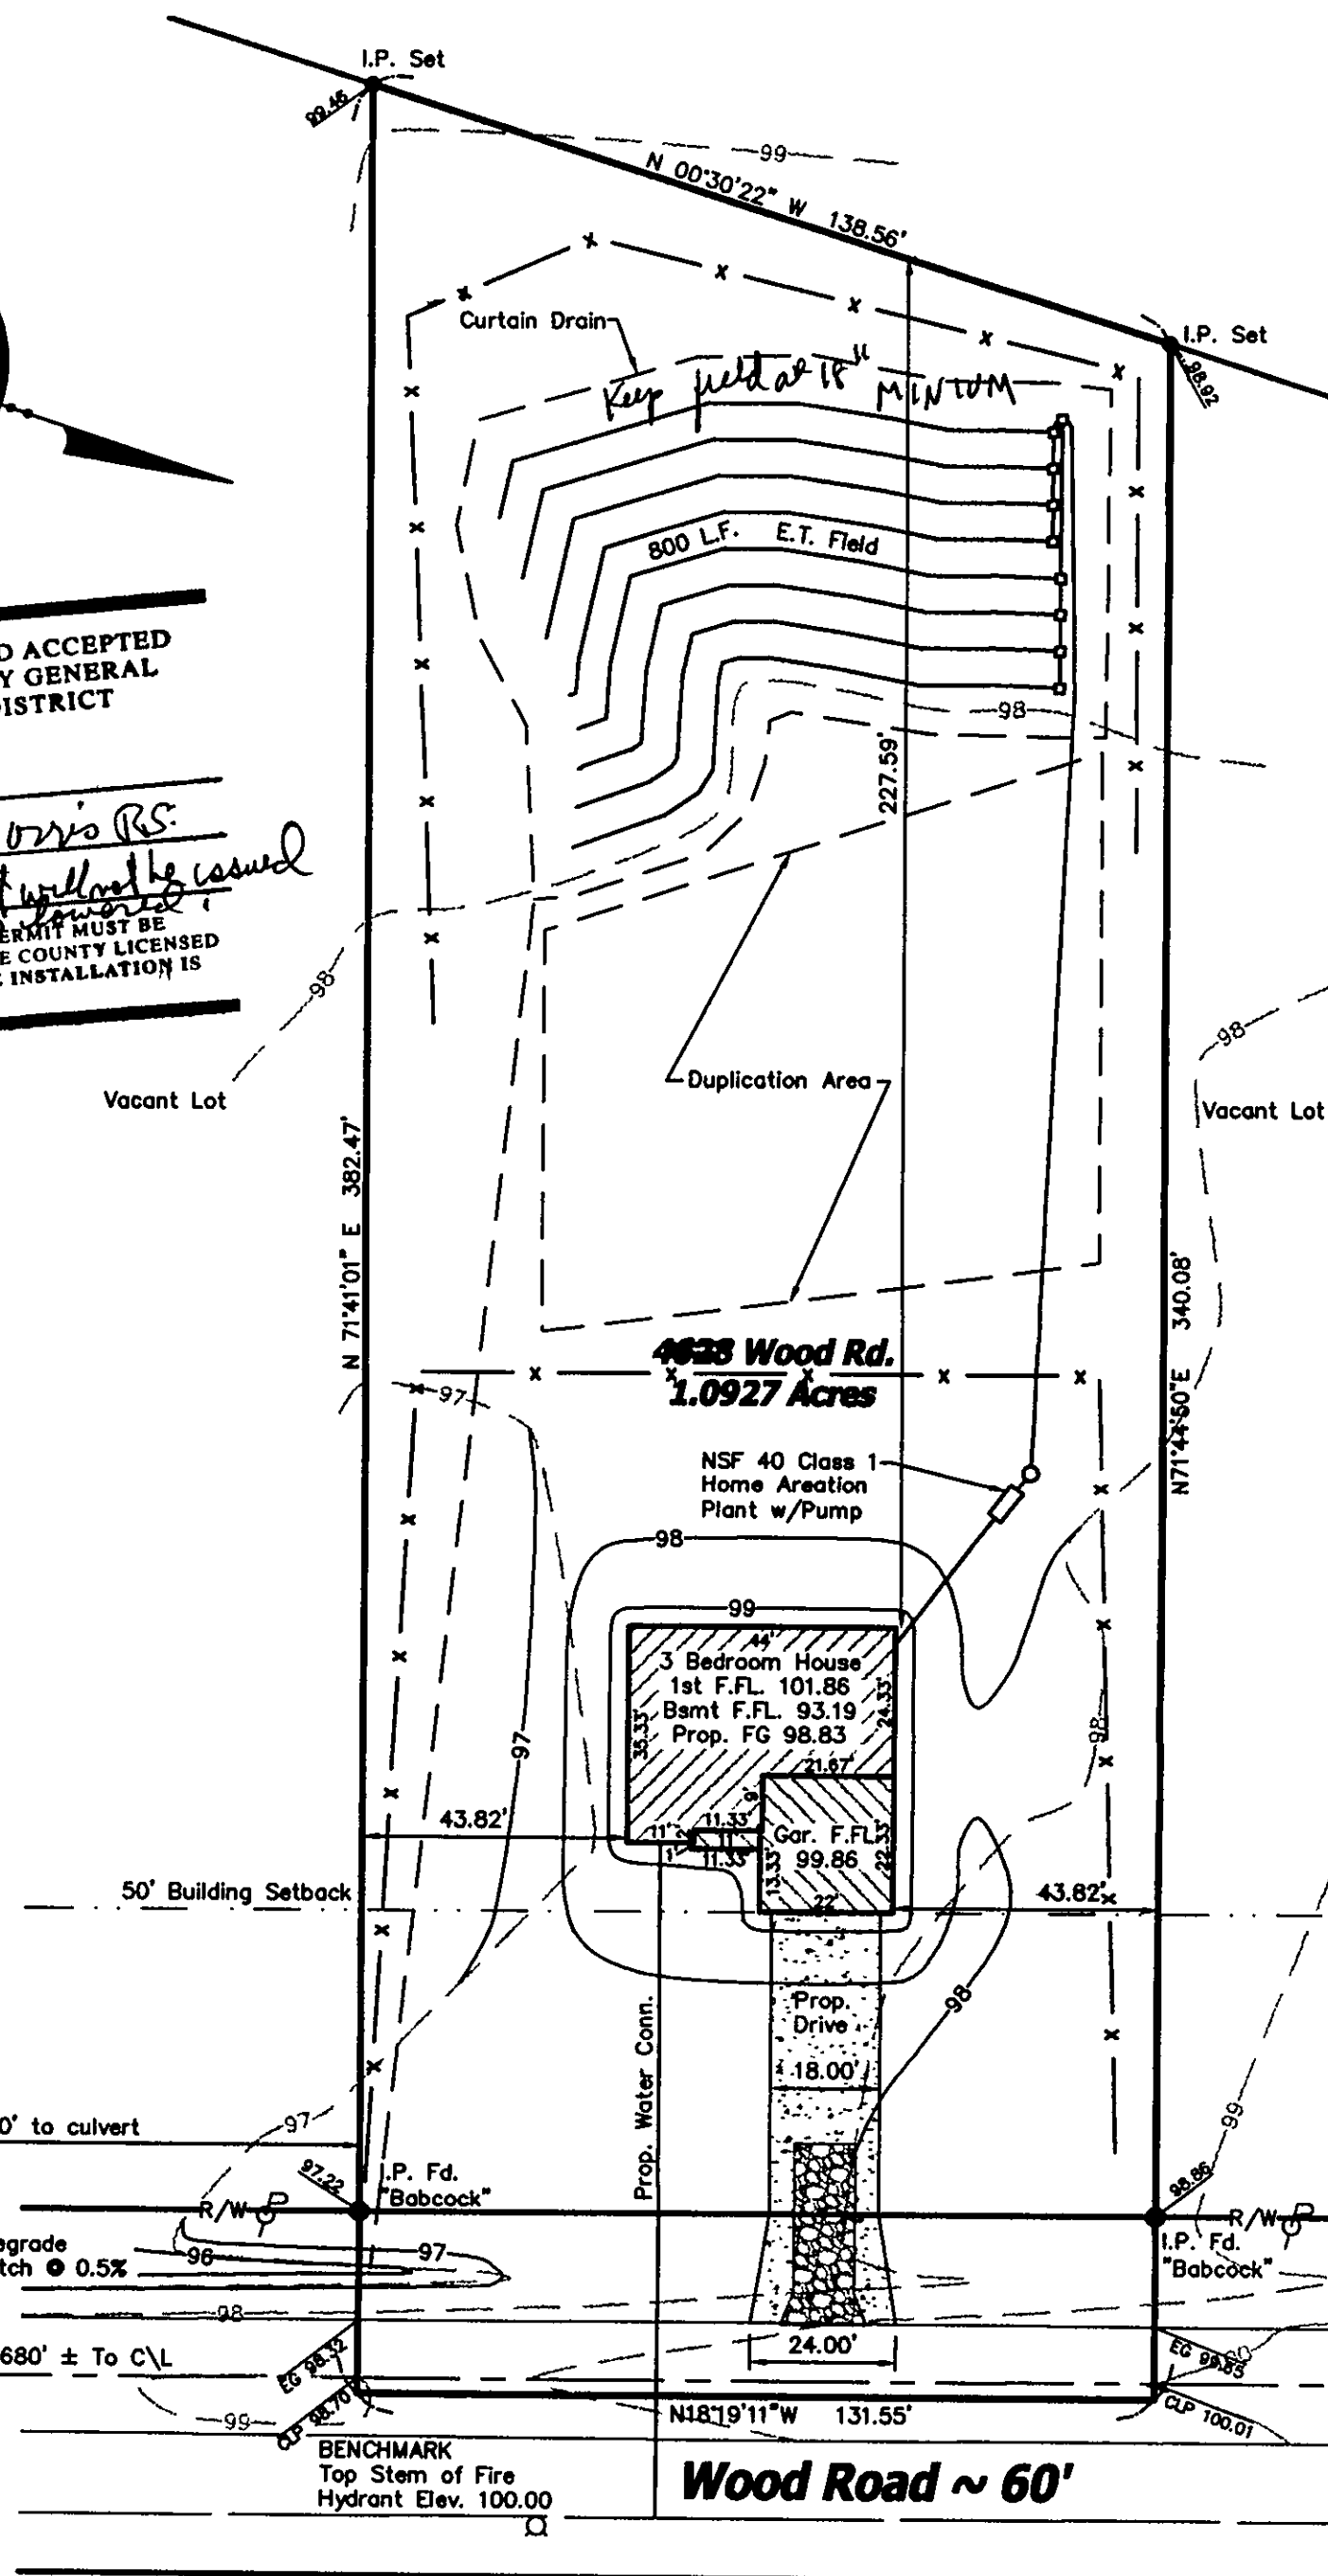

SITE PLAN
for: McCullough Home Builders
CLIENT
P.O. Box 349 Perry Ohio 44081
ADDRESS CITY STATE ZIP
SUBLOT No. 1028 Wood Rd. SUBDIVISION NAME VOL. PAGE
LOT Madison Ohio TRACT CITY STATE

Foresight Engineering Group
Engineers & Surveyors
440 286-1010
440 286-1034 fax
320 Center Street, Unit F
Chardon, Ohio 44024

SCALE: 1" = 30' 1
FILE NAME: I:\Mcc10307\Siteplan 2
DATE: August 19, 2003 3
BENCHMARK: Top Stem of Fire Hydrant
Elevation: 100.00 (As Shown)
SHEET NO. 1/2


LEGEND	
	Fire Hydrant
	Iron Pin Found
	Power Pole

EROSION CONTROL SYMBOLS

	Silt Fence
	Construction Entrance

Zoning District ~ A1
Front Setback = 50'
Side Setback = 15'
Sum of Side yards = 35'
Rear Setback = 40'
Min. Lot Frontage = 100'


* Curtain Drain Pump
per Lake County
Health Department

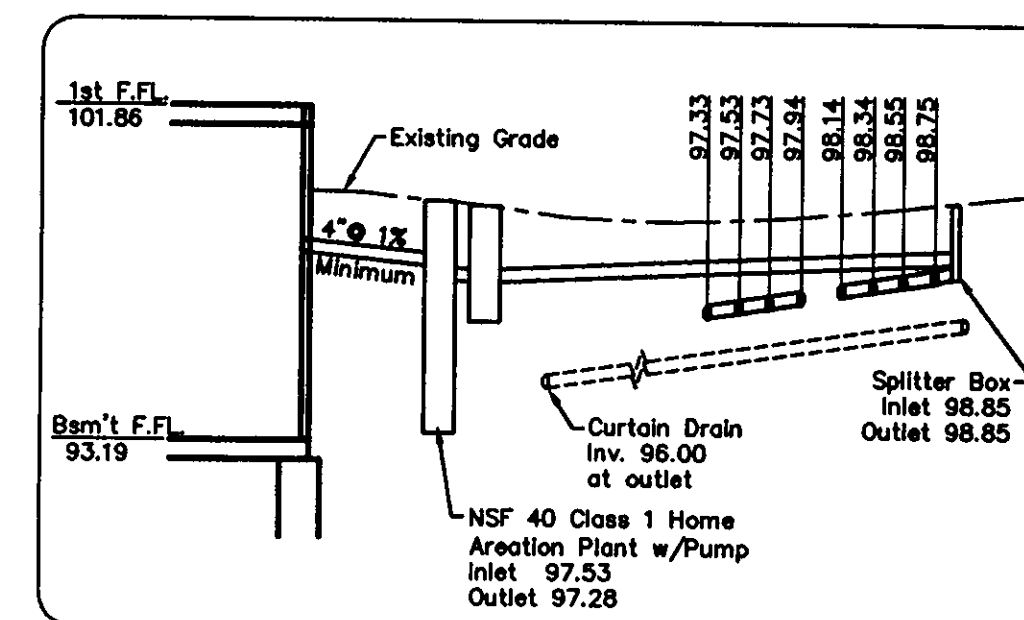

Hydraulic Profile
NO SCALE

The locations of the underground utilities as shown hereon are based on above ground structures and record drawings. Locations of underground utilities/structures may vary from the locations shown hereon. Additional buried utilities/structures may be encountered. Contractor to field verify horizontal and vertical location of all utilities in all area of work prior to commencement of work.

**2 WORKING DAYS
BEFORE YOU DIG**
CALL TOLL FREE 800-362-2764
OHIO UTILITIES PROTECTION SERVICE

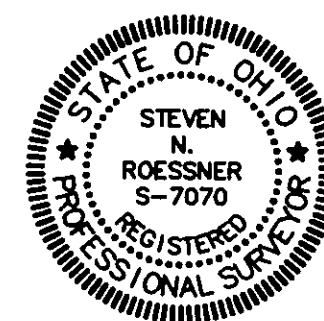

APPROVED
MADISON TOWNSHIP ZONING
DATE 8/29/03
"I, the undersigned hereby state that this topography indicated by 1' contours, and the elevations shown hereon represent an actual field survey made by Foresight Engineering Group, Inc. on the 16 day of July, 2003 and that the elevations were taken at appropriate intervals and that as of that date they existed as indicated hereon."
Steven N. Roessner, P.E. S-7070 8/19/07
Date