


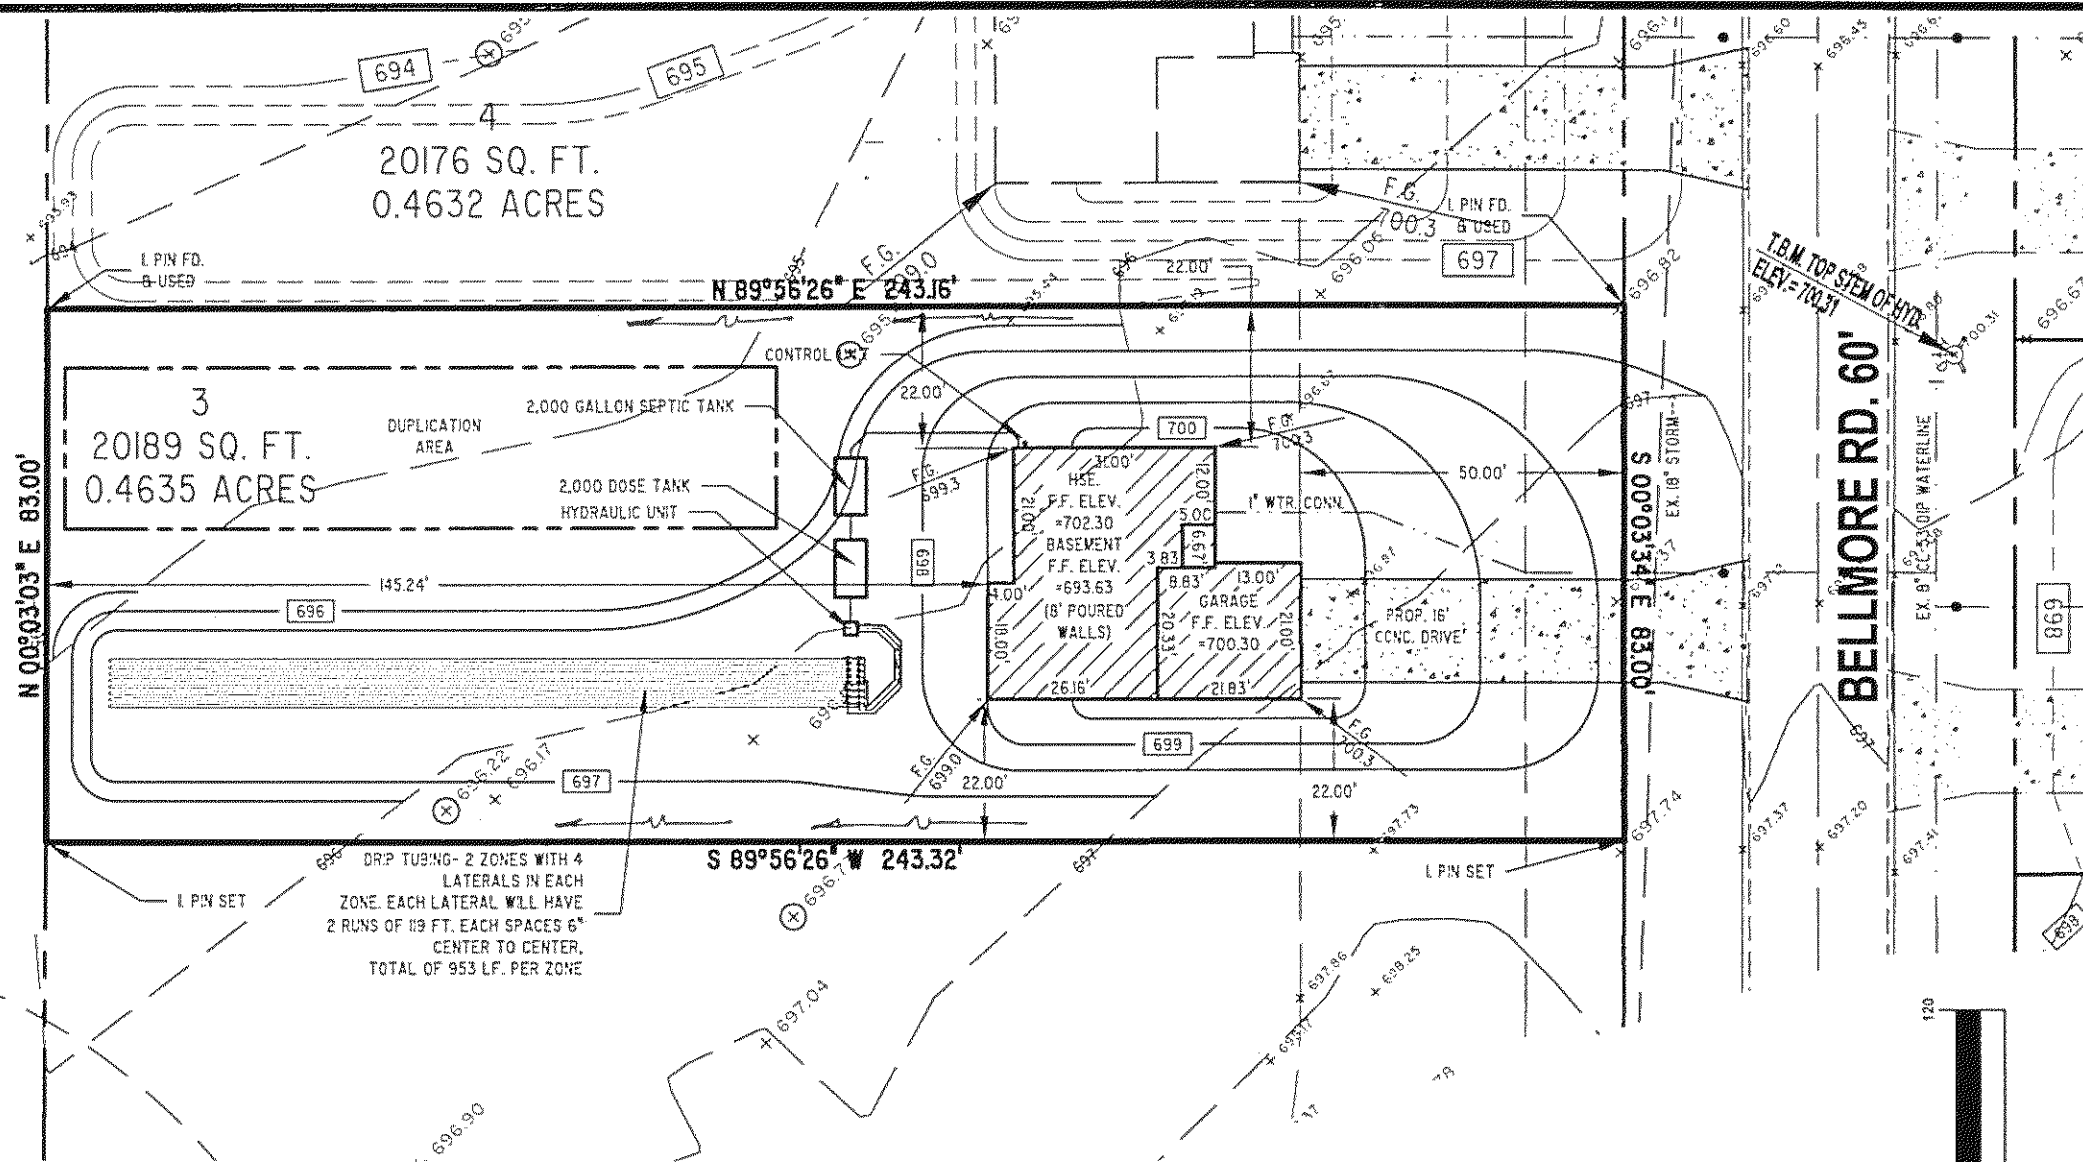

GENERAL NOTES:

1. BENCHMARK - TOP STEM OF EXISTING FIRE HYDRANT LOCATED IN FRONT SUBLOT 23, ELEVATION = 700.31.
2. DRIVEWAY APRON TO BE 6" THICK CONCRETE.
3. ALL DOWNSPOUTS TO BE OUTLETTED TO SPLASH BLOCKS.
4. CONTRACTOR RESPONSIBLE FOR CONTACTING THE OHIO UTILITY PROTECTION SERVICE (1.800.362.2764) AND ALL UTILITY COMPANIES A MINIMUM OF 48 HOURS PRIOR TO CONSTRUCTION.
5. THE LOCATION BOTH HORIZONTAL AND VERTICAL OF EXISTING UNDERGROUND UTILITIES SHOWN HEREON, HAVE BEEN OBTAINED BY A DILIGENT AND COMPREHENSIVE SEARCH OF AVAILABLE RECORDS. VERIFICATION BY FIELD OBSERVATION HAS BEEN CONDUCTED WHERE PRACTICAL, HOWEVER, BARRINGTON CONSULTING GROUP, INC. DOES NOT GUARANTEE THE COMPLETENESS, NOR ACCURACY THEREOF.
6. CONTRACTOR SHALL VERIFY ELEVATIONS OF LATERAL INVERTS IN THE FIELD PRIOR TO FOUNDATION EXCAVATION.
7. SEE SHEET 3 FOR EROSION AND SEDIMENT-CONTROL PLAN
8. SEE SHEET 3 FOR SEEDING INFORMATION

CERTIFICATION:


"I THE UNDERSIGNED HEREBY CERTIFIES THAT THIS TOPOGRAPHY INDICATED BY 1 FOOT CONTOURS AND ELEVATION SHOWN HEREON REPRESENTS AN ACTUAL SURVEY MADE BY ME ON THE 16th DAY OF JANUARY, 2002 AND THE ELEVATIONS WERE TAKEN AT AN APPROPRIATE INTERVAL AND AS OF THAT DAY THEY EXISTED AS INDICATED HEREON.


"I HEREBY CERTIFY THAT THIS PLAN WAS PREPARED BY ME AND IS CORRECT TO THE BEST OF MY KNOWLEDGE AND BELIEF"

"I CERTIFY THIS SEWAGE SYSTEM DESIGN MEETS MINIMUM REQUIREMENTS ESTABLISHED BY THE LCGHD IN THE HSTS GUIDANCE MANUAL, AND THE REQUIREMENT AND RECOMMENDATIONS OF THE SYSTEM MANUFACTURER."

DAVID W. NOVAK, P.S. No. 7507
Stormwater Management Plan
Approved as shown and/or noted
JAMES R. GILLS, P.E.
County Drainage Engineer


By L.S. Date 10/6/05

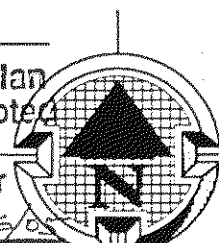

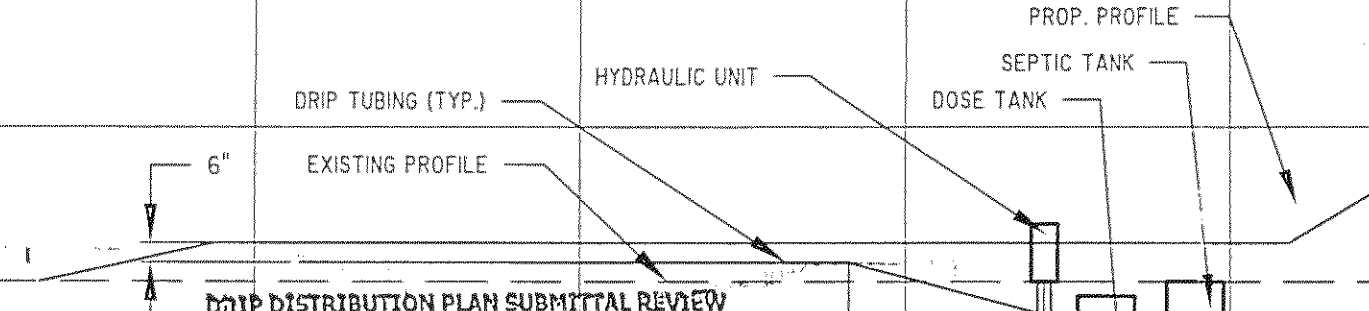700				HSE. F.F. ELEV. =702.30			700				
695				B'SMT F.F. ELEV. =693.63			695				
690	Drip distribution area has been field verified and protected with marking tape Plans submitted to LCGHD and meet design criteria Hydraulic calculations verified and accurate			Date 9/29/05 10/6/05 9/28/05	Name [Signature] [Signature] [Signature]		690				
685				INV. =696.40	INV. =696.00	INV. =694.50	INV. =694.50	INV. =694.09	INV. =694.68	INV. =694.98	685

REVISIONS	BY
REVISED SEPTIC	WSO
OCT. 3, 2005	

Barrington
CONSULTING GROUP, INC.
9114 TYLER BLVD., MENTOR, OHIO 44060
PHONE 440.295.1260 FAX 440.295.1262
BCG@BarringtonCGI.com

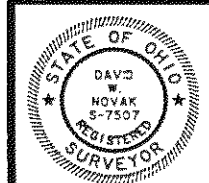

SITE PLAN
SIL 3 BELLMORE DR. PAINESVILLE TWP. OH. 44077
BELLMORE SUBDIVISION VOL. 44 PG. 21
LITTLE MOUNTAIN HOMES, INC.

DRAWN	WSO
CHECKED	DWN
DATE	SEPT. 08, 2005
SCALE	1" = 30'
JOB NO.	02007-03
SHEET	1/5