



MARGARET L. LANUM
VOL. 639-202

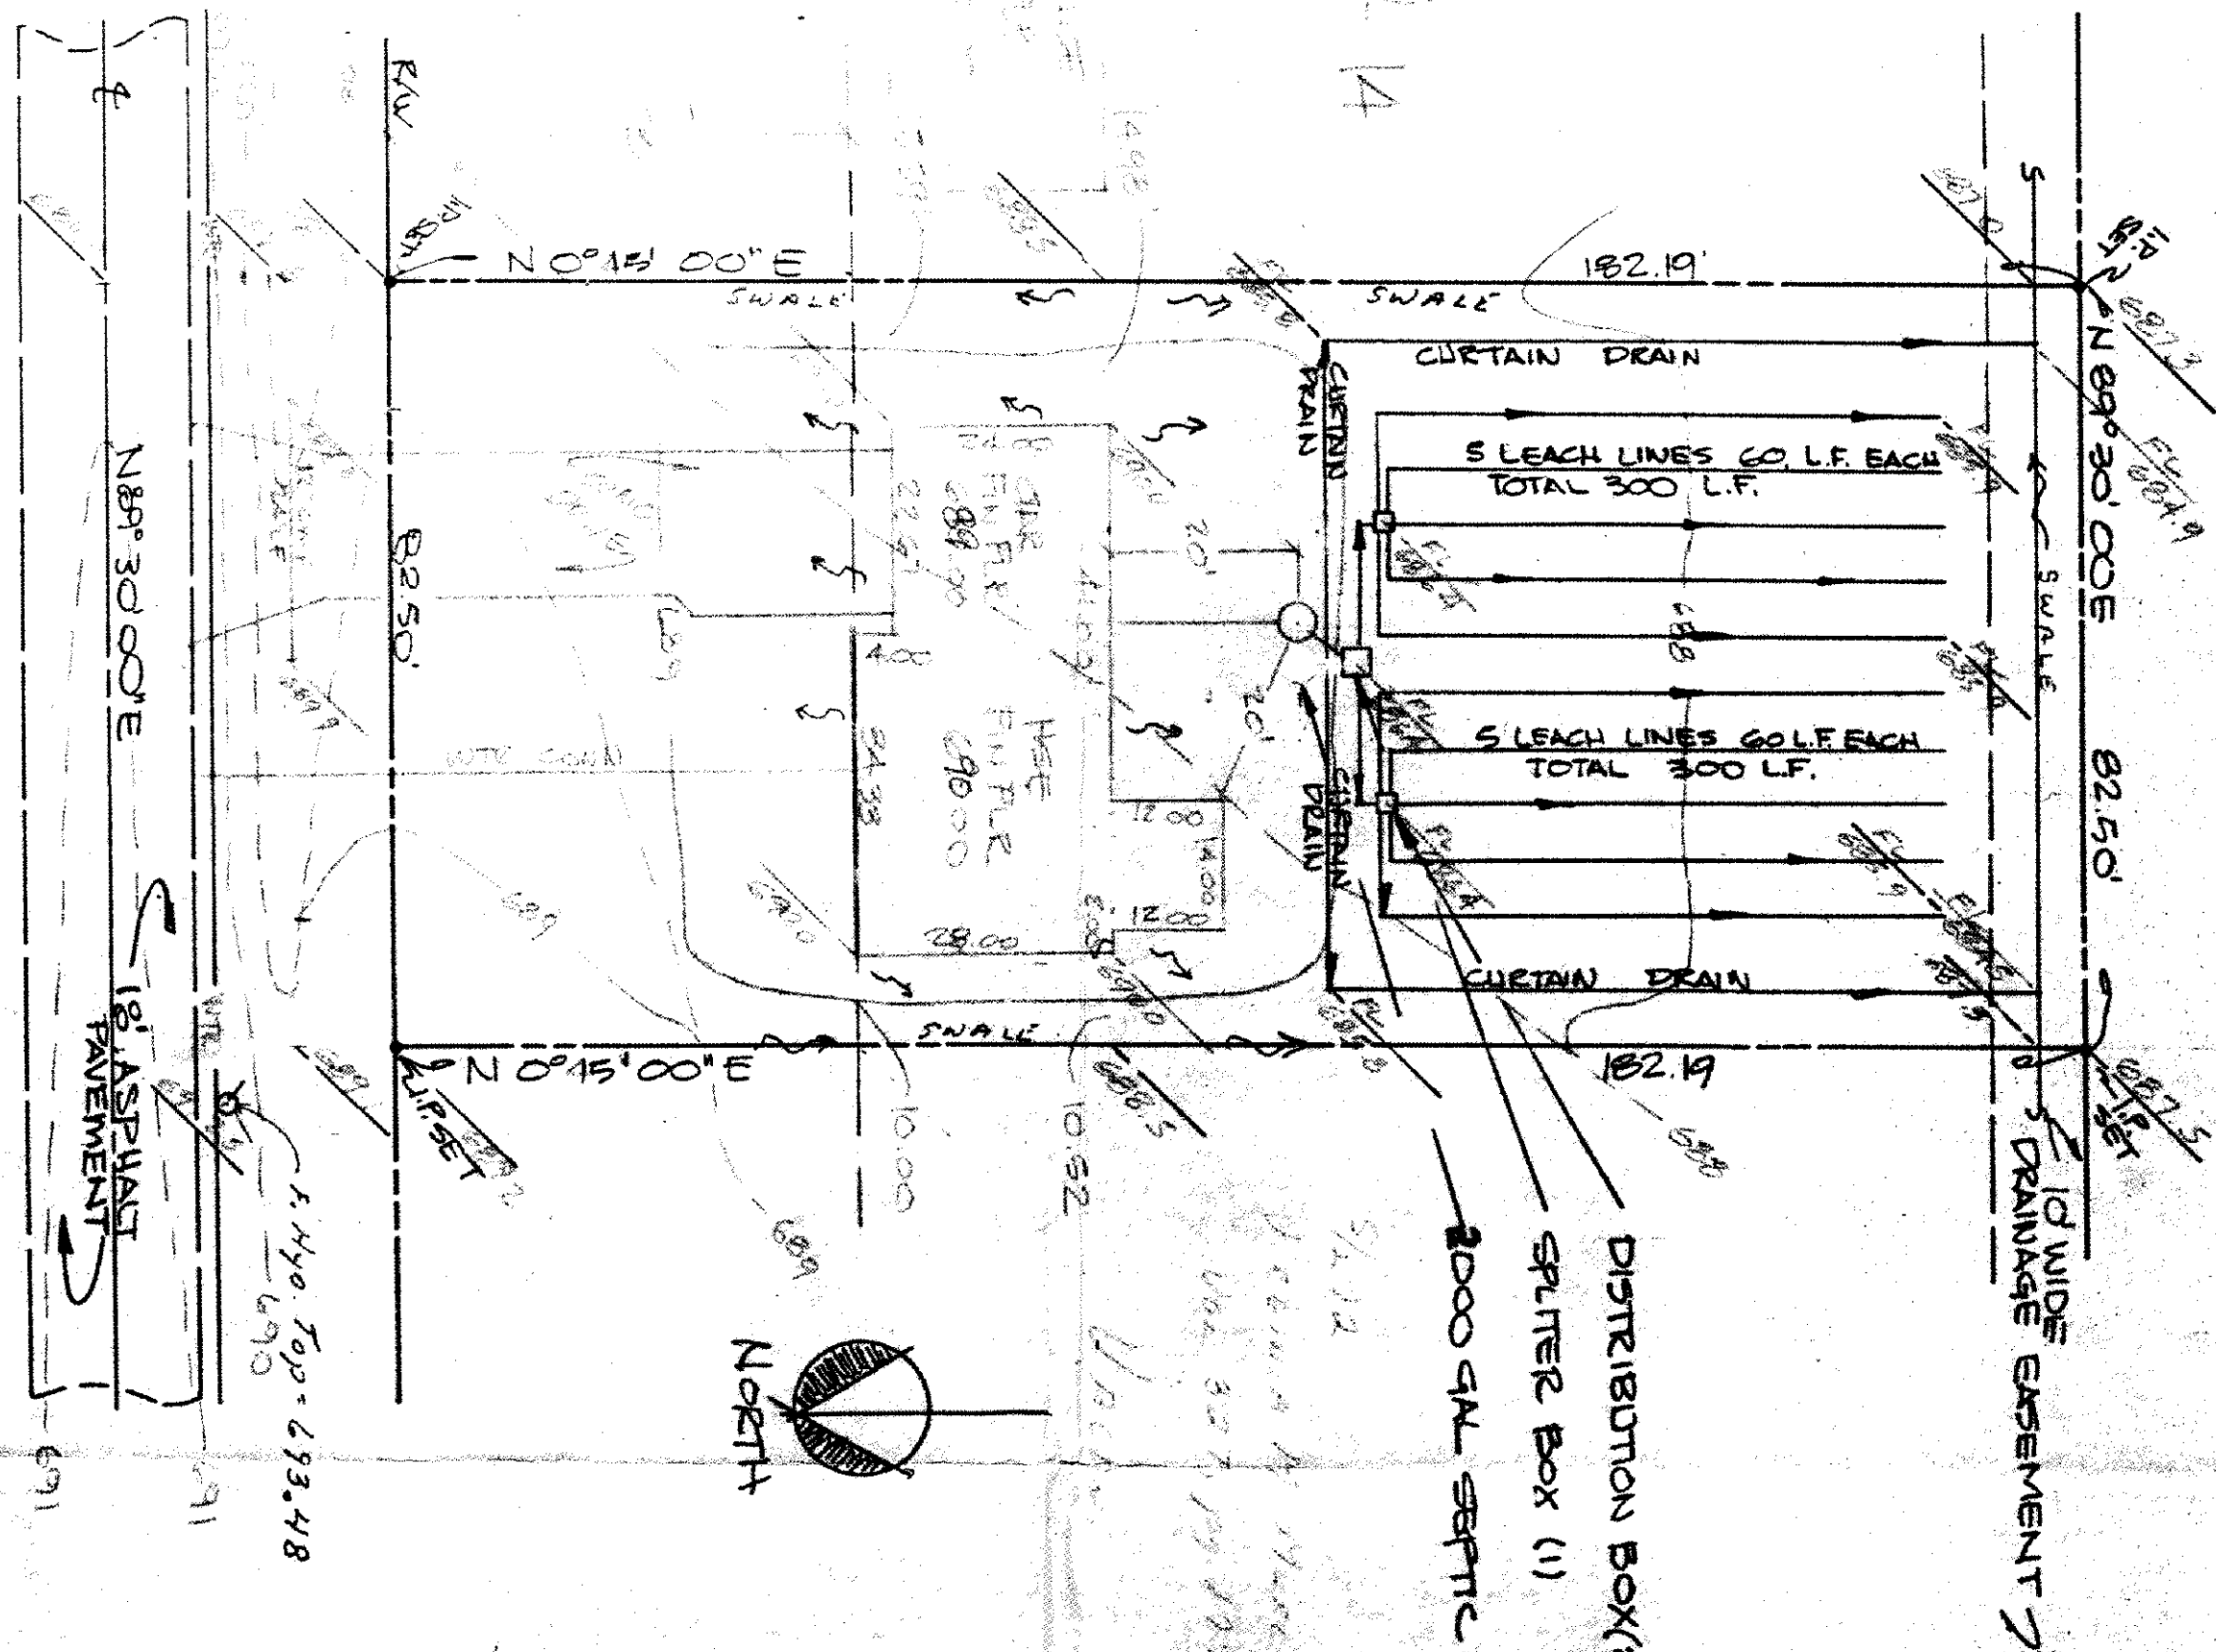

BRANCH STREET CO
BENCH MARK - TOP OF FIRE MND IN FRONT
OF SPLIT ELEV. = 690.68

DISTRIBUTION BOX(2)
SPLITTER BOX (1)
2000 GAL SEPTIC TANK (1)

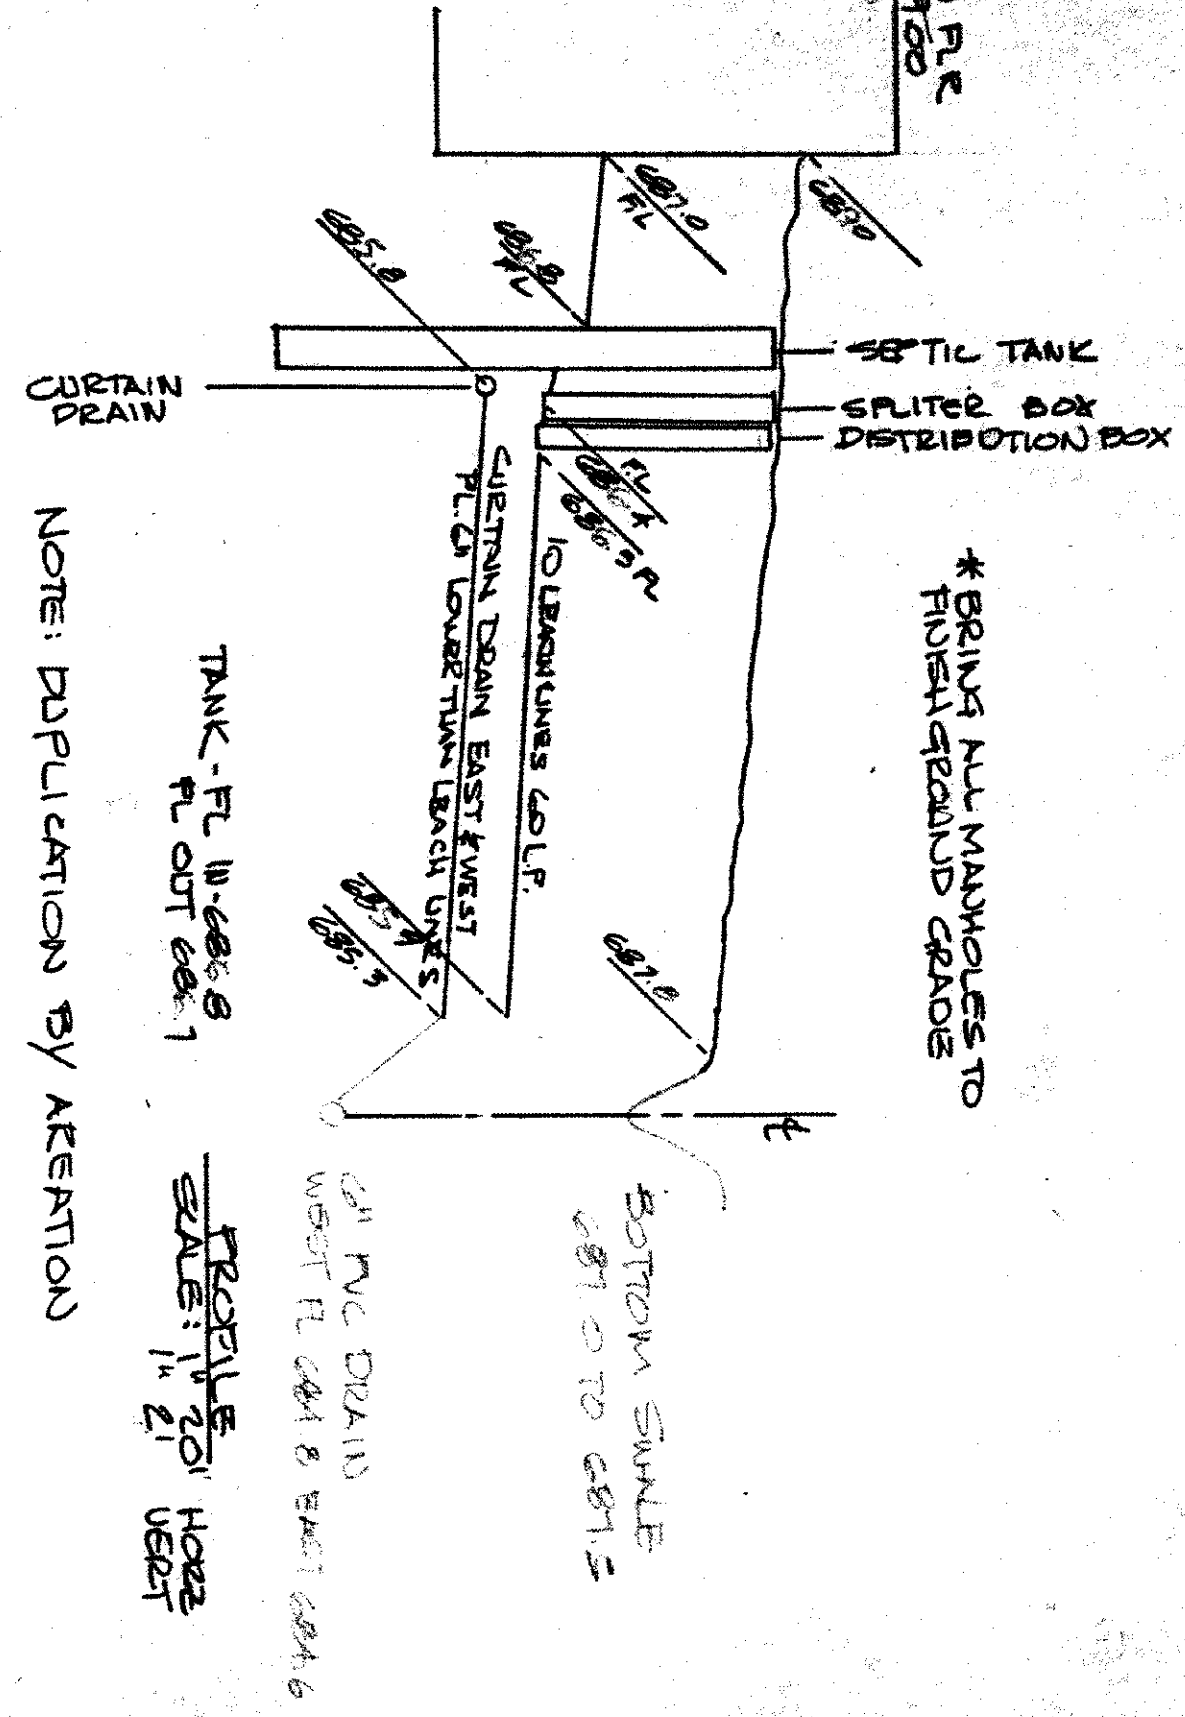


THIS PLAN WAS PREPARED BY ME AND IS CORRECT
TO THE BEST OF MY KNOWLEDGE

BEING KNOWN AS SUBLOT 13 IN THE REYNOLDS SURVEY AS
RECORDED IN VOLUME A PAGE 17 LAKE COUNTY RECORD
OF PLATS

Reviewed and Accepted
LAKE COUNTY GENERAL HEALTH DISTRICT
Date 8-4-89
JOEL LUDIA, R. S., M. P. H.
Health Commissioner
By *Debra K. Knepper*

SEWAGE DISPOSAL PERMIT MUST BE
OBTAINED BY A LAKE COUNTY LICENSED
INSTALLER BEFORE INSTALLATION IS
STARTED.
LOW YIELD WATER
FIXTURES REQUIRED
ON ALL:
Shower Head
Toilet

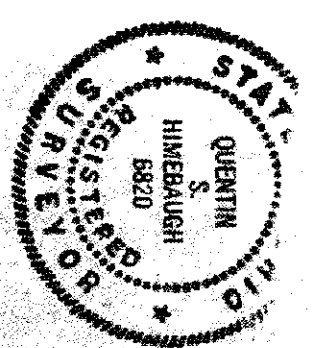

This Permit Expires
10-5-90
2363
Zoning Inspector 10/5/89

- A. To be brought to finished grade
1. Septic tank manhole covers
 2. Splitter box cover
 3. Distribution box cover
- B. To 100' or downslopes
to be discharged into septic tanks
- C. All waste water to be discharged into
septic tanks
- Grading Plan Approved
as shown and/or noted
THOMAS P. GILLES, P.E.
Lake County Engineer
Date 8/1/89

SITE PLAN SUBLOT 13 BRANCH STREET
REYNOLDS SURVEY/PAINESVILLE TWP PAINESVILLE OH
PLAN PREPARED BY QUENTIN HIMEBAUGH
WILDEGARY C/O 946-1761

DRAWING NUMBER
88-134-13