

SITE PLAN

PAINESVILLE TWP., LAKE COUNTY, OHIO

for: JOHN CUTLIP

CLIENT OWNER ADDRESS STREET CITY ZIP

BRANCH SURVEY SUBDIVISION A-77 NAME TRACT STREET LOT 14 PT. VOL-PG. BRANCH AVE. LOT 11B-27A-10. SUBLOT NO. STREET VOL-PG. PERM. PARCEL NO.

LEGEND

SANITARY MANHOLE STORM MANHOLE INLET OR CATCH BASIN HYDRANT EXISTING CONTOURS PROPOSED CONTOURS EXIST. ELEV. 100.0 100.0 2 PROP. ELEV. AS BUILT ELEVATION INDICATES DIRECTION OF SURFACE DRAINAGE

REMARKS

ALL BOUNDARY DATA SHOWN WAS OBTAINED FROM (DEEDS, RECORDED SUBDIVISION PLAT OR OTHER PUBLIC RECORDS)

LOCATIONS AS SHOWN OF ADJACENT WELLS AND SEPTIC TANKS OBTAINED FROM LAKE COUNTY HEALTH DEPARTMENT

DESIGN CERTIFICATION

THIS PLAT WAS PREPARED BY ME, AND IS CORRECT TO THE BEST OF MY KNOWLEDGE AND BELIEF.

NAME SURVEYOR REGISTRATION NO.

CHECK LIST

NO. OF BEDROOMS DIMENSIONS BEARINGS TIE TO NEAREST STREET SUBLOT NO. PARCEL NO. SURROUNDING OWNERS BLDG. DIMENSIONS FIN GR. BLDG. TIES FL'R. GRADES APRON TYPE WIDTH THICKNESS SIDEWALK TYPE WIDTH THICKNESS CULVERT TYPE DIA., LENGTH ROCK OUTCROPPINGS WATER MAIN SIZE, LOCATION SAN. SEWER SIZE 7/8 GR. LOC. SAN. MH. CAST. ELEV. INV. ELEV. SAN. CONN. SIZE, LOC. DEPTH STORM SEWER SIZE 7/8 GR. LOC. STORM MH. CAST. ELEV. INV. ELEV. PAV'T TYPE GRADE CURBS GAS LINE LOC. SIZE PRESSURE SEPTIC TANK LOCATION & DUPLICATION AREA WELL LOCATION ISOLATION RADIUS FROM WELL

REVISIONS

NO.	DATE	BY
1	8/8/05	H.J.
2	8/12/05	H.J.
3	8/18/05	B.P.
4	8/24/05	H.J.
5		

DRAWN BY B.P.	SCALE 1"=20'	PHONE NO. 440-357-1811
CHK'D. H.J.	DATE 8/2/05	DRAWING NO. 05-162
CREW/ CHIEF W.B.	APP'D H.J.	

"AS BUILT" CERTIFICATION

I, HEREBY CERTIFY THAT THE CIRCLED GRADES ARE EXISTING FINISH GRADES CHECKED IN THE FIELD ON 8/2/05, 2005 AND ARE CORRECT TO THE BEST OF MY KNOWLEDGE AND BELIEF.

REGISTERED SURVEYOR


REG. NO.

TBM - 1" IRON PIPE FND ELEV - 686.18

684.52
I.B.
RIM 684.52
INV. 680.02

685.00
I.B.
RIM 685.00
INV 679.90


EXISTING UTILITIES NOTE: THE SIZE AND LOCATION, BOTH HORIZONTAL AND VERTICAL OF THE UNDERGROUND UTILITIES SHOWN HEREON, HAVE BEEN OBTAINED BY A SEARCH OF AVAILABLE RECORDS. VERIFICATION BY FIELD OBSERVATION HAS BEEN CONDUCTED WHERE PRACTICAL, HOWEVER, BABCOCK, JONES AND ASSOCIATES INC. DOES NOT GUARANTEE THE COMPLETENESS NOR ACCURACY THEREOF.

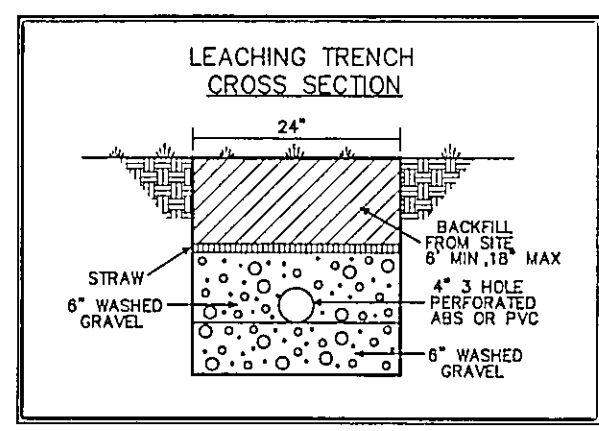


REVIEWED AND ACCEPTED LAKE COUNTY GENERAL HEALTH DISTRICT

Date 8/25/05 BY [Signature]

SEWAGE DISPOSAL PERMIT MUST BE OBTAINED BY A LAKE COUNTY LICENSED INSTALLER BEFORE INSTALLATION IS STARTED

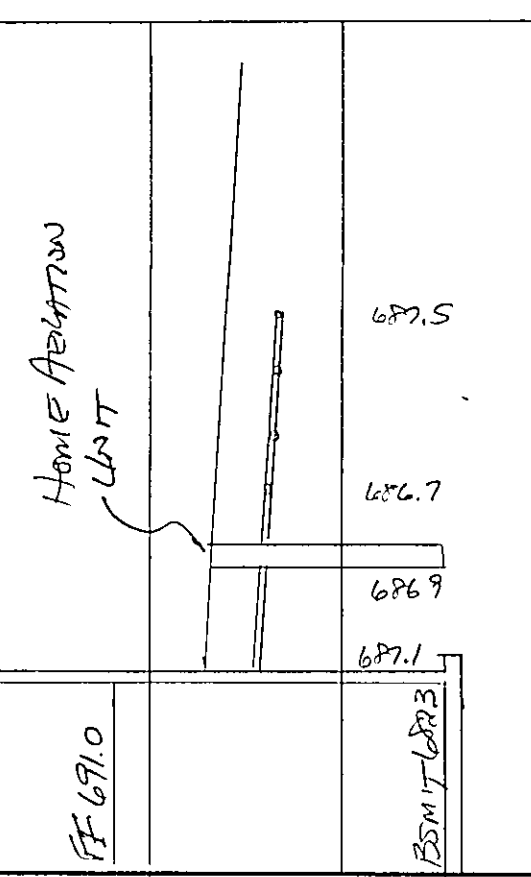

14" DIA. VERTICAL PROFILE

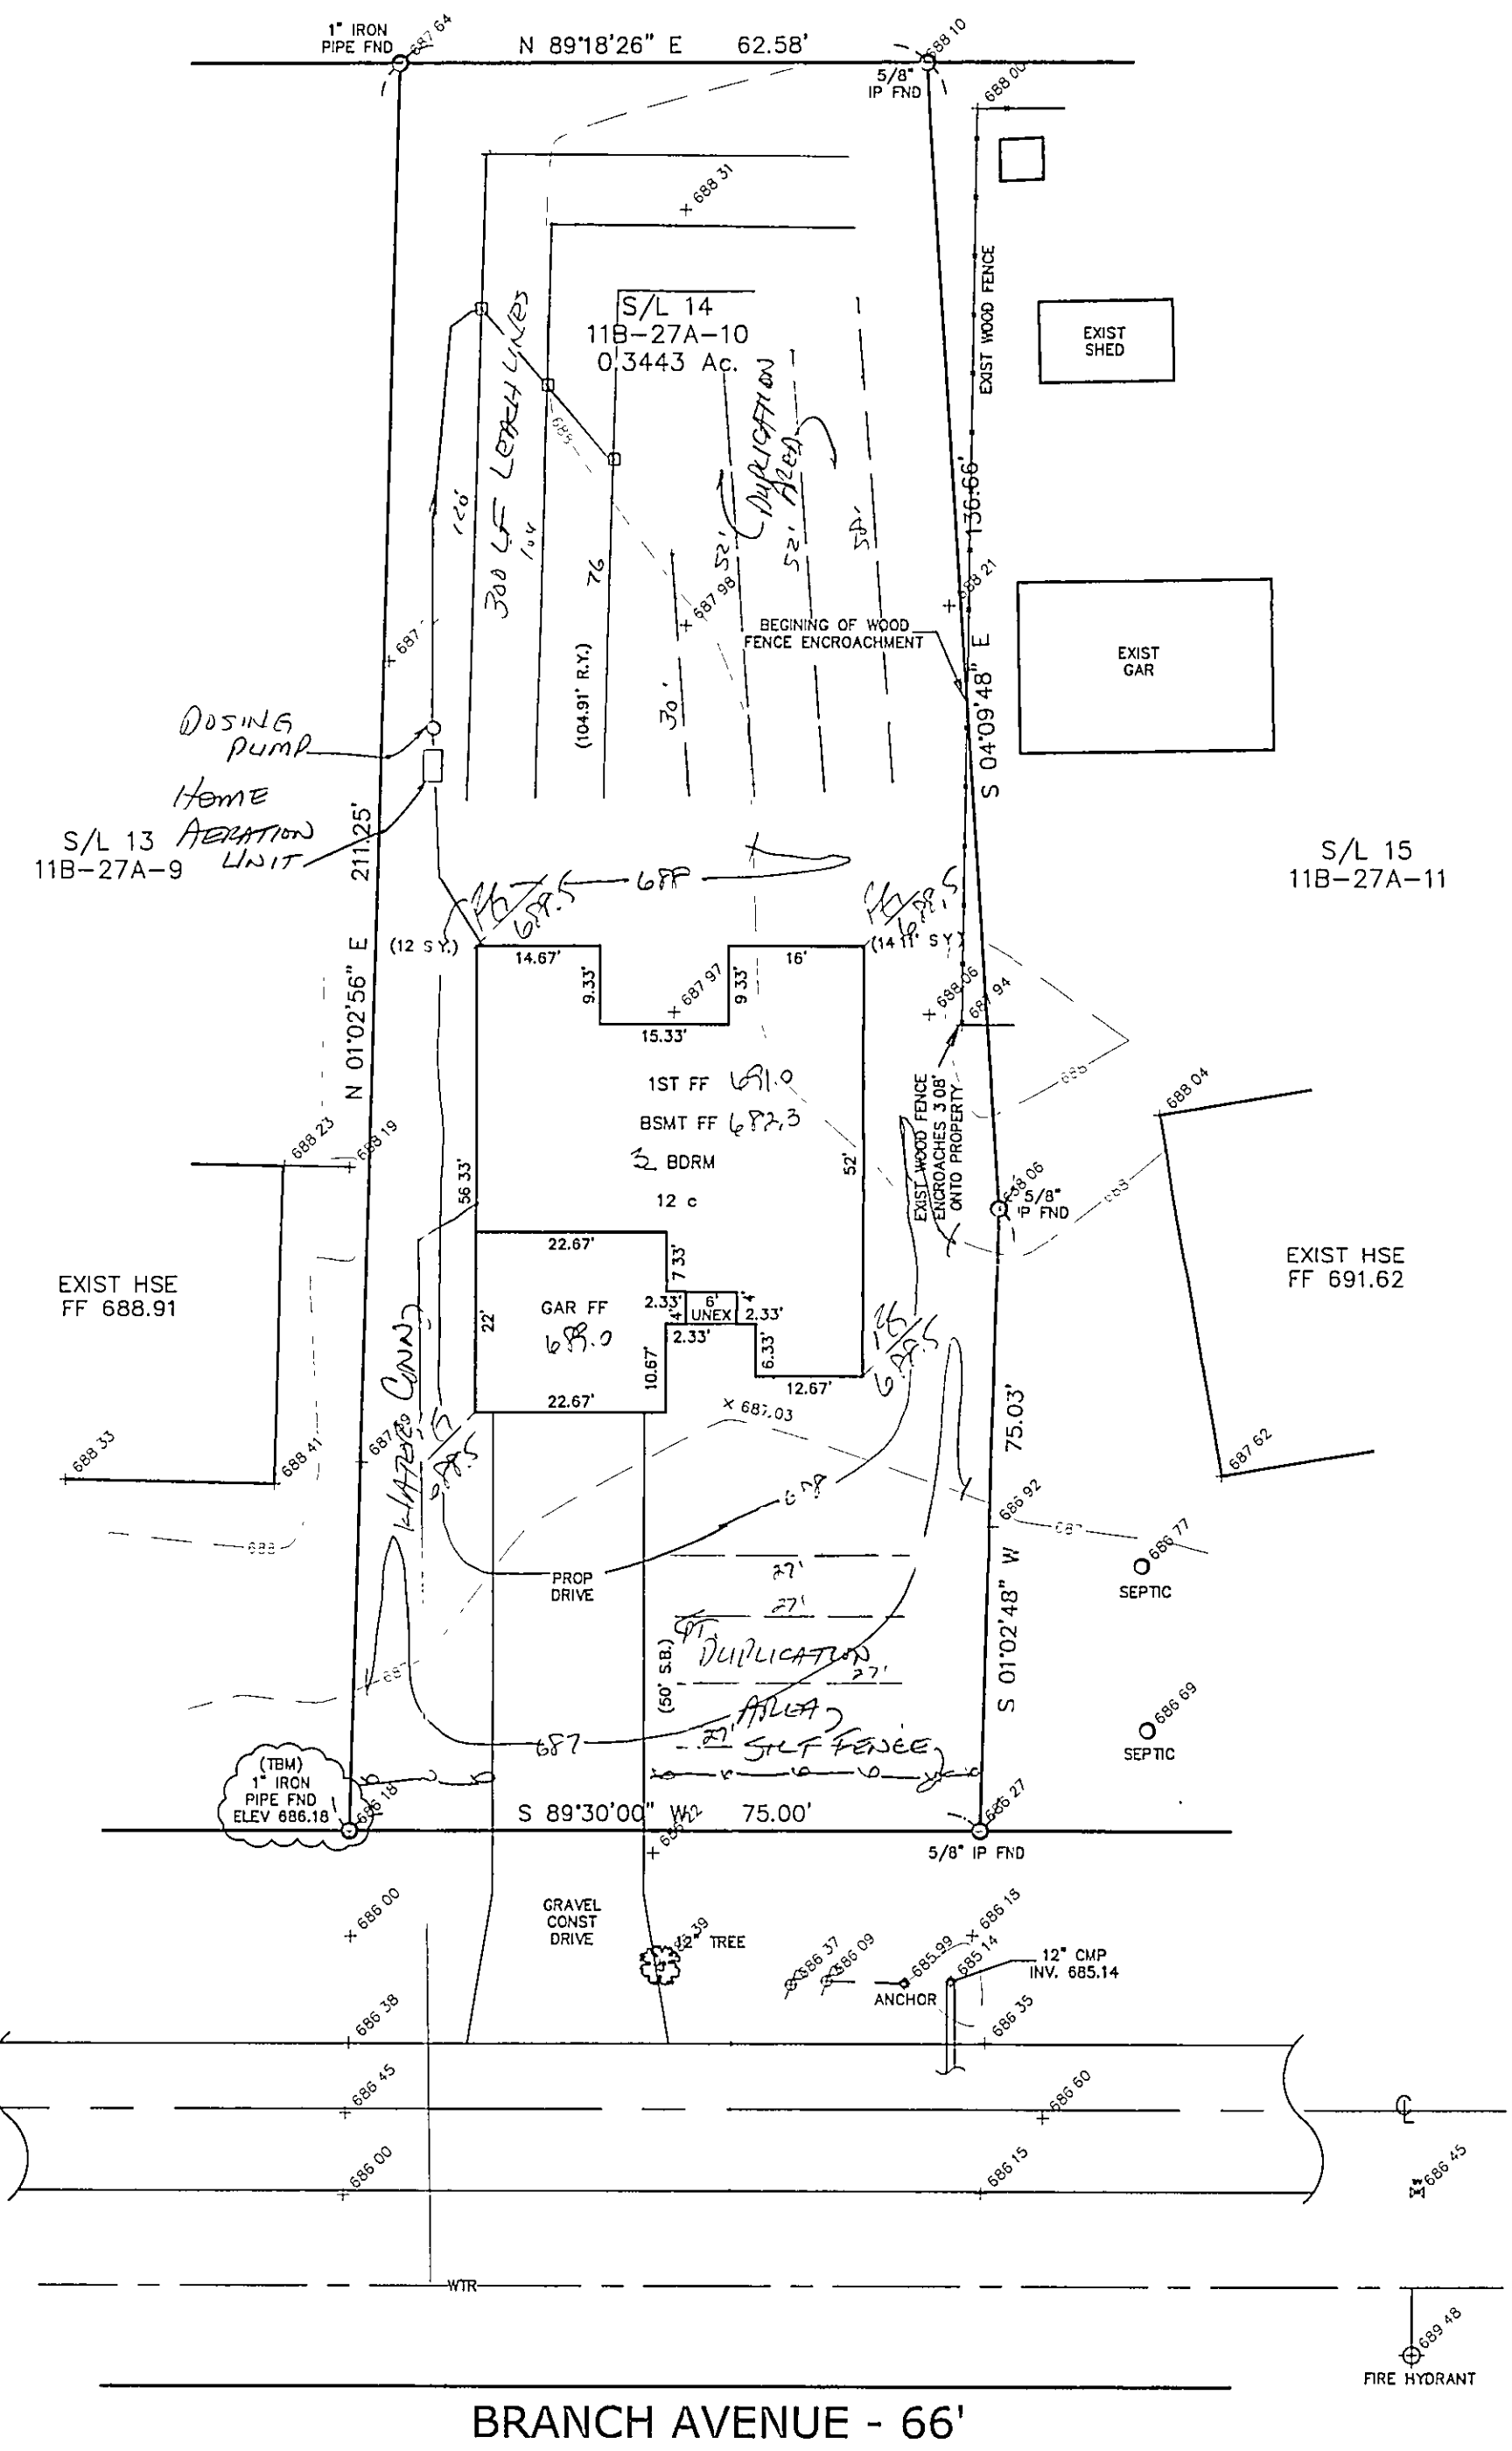

BRANCH AVENUE - 66'