

**PAINESVILLE TOWNSHIP
ZONING APPROVED**


3950 6-11-76

Thomas P. Gilles
Zoning Inspector

Grading Plan Approved
as shown and/or noted
THOMAS P. GILLES, P.E.
Lake County Engineer

By *JWK*

Date 6-11-76

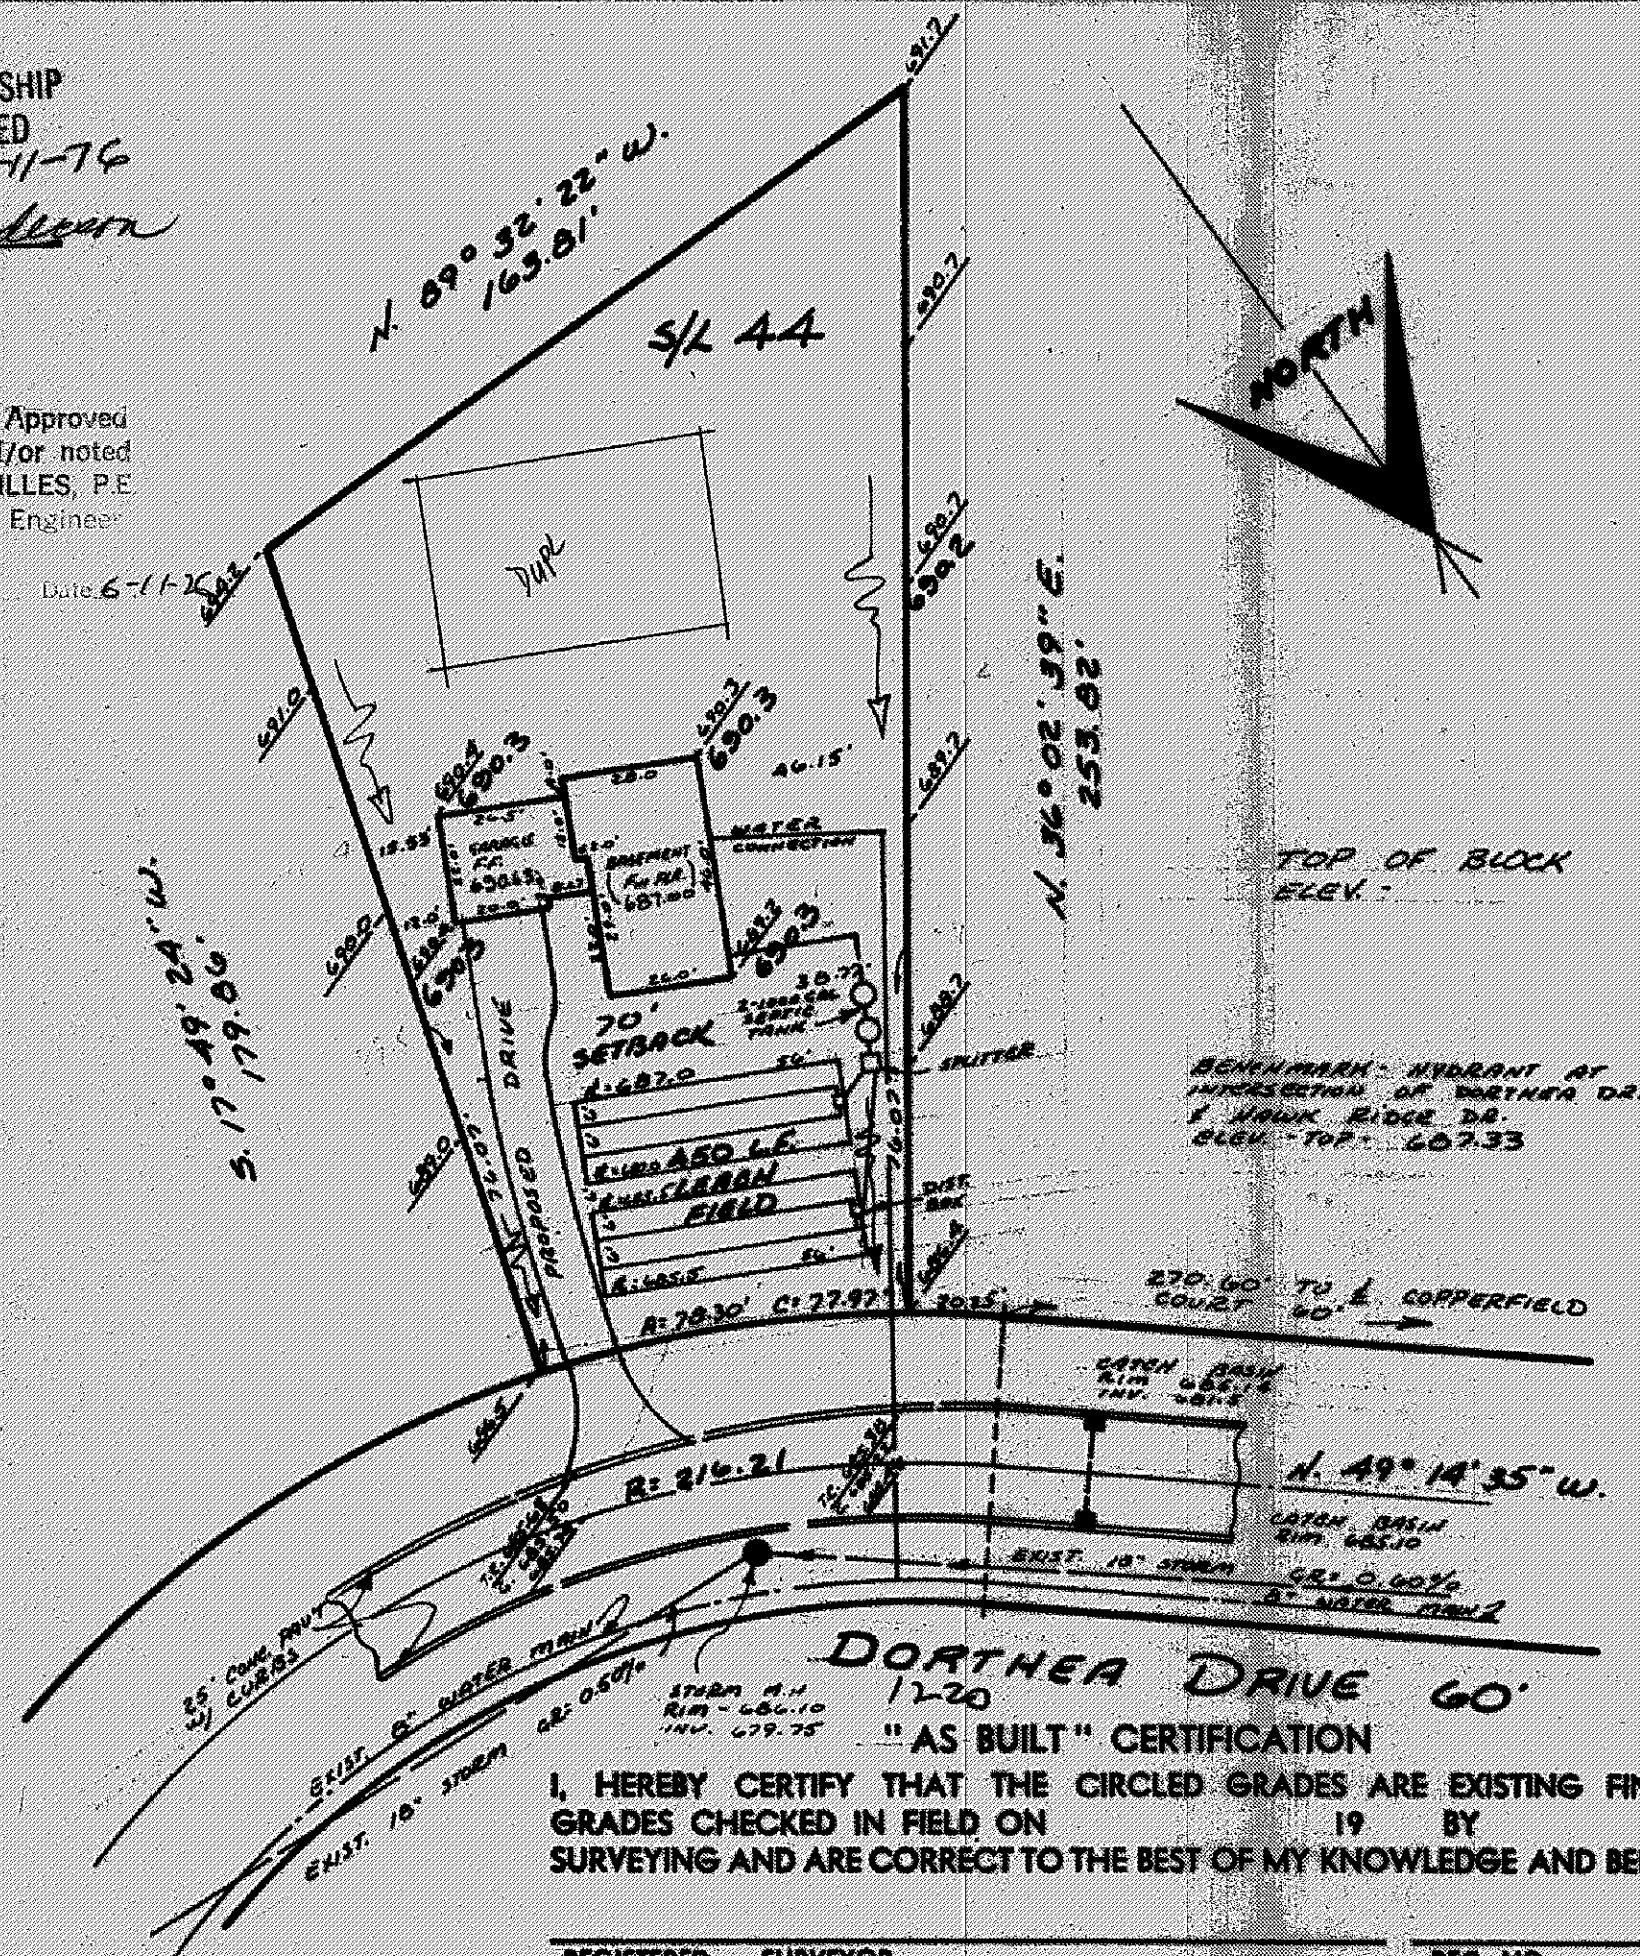

I, HEREBY CERTIFY THAT THE CIRCLED GRADES ARE EXISTING FINISH GRADES CHECKED IN FIELD ON 19 BY SURVEYING AND ARE CORRECT TO THE BEST OF MY KNOWLEDGE AND BELIEF.

REGISTERED SURVEYOR

REG. NO.

SITE PLAN

PAINESVILLE LAKE COUNTY, OHIO
TOWNSHIP

for: **B.S.M.**

CLIENT OWNER

ADDRESS STREET CITY ZIP

HEMLOCK HEIGHTS N.P.S.
SUBDIVISION NAME
44 VOL. - PG.
SUBLOT NO. **DORTNER DR.** STREET

LOT TRACT
VOLUME PAGE
PERM. PARCEL NO. STREET

LEGEND

SANITARY MANHOLE	-----○	WATER VALVE (GAS)	-----○
STORM MANHOLE	-----●	WATER METER (GAS)	-----○
INLET OR CATCH BASIN	-----■	AS BUILT ELEVATION	100.0
HYDRANT	-----○	INDICATES DIRECTION OF SURFACE DRAINAGE	↓
EXISTING CONTOURS	-----		
PROPOSED CONTOURS	-----		
EXIST. ELEV.	100.0	PROP. ELEV.	100.0

REMARKS

ALL BOUNDARY DATA SHOWN WAS OBTAINED FROM (DEEDS, RECORDED SUBDIVISION PLAT OR OTHER PUBLIC RECORDS)

LOCATIONS AS SHOWN OF ADJACENT WELLS AND SEPTIC TANKS OBTAINED FROM LAKE COUNTY HEALTH DEPARTMENT

DESIGN CERTIFICATION

THIS PLAT WAS PREPARED BY ME, AND IS CORRECT TO THE BEST OF MY KNOWLEDGE AND BELIEF.

NAME *Richard J. Salo* SURVEYOR REGISTRATION NO. **PS# 5244**

CHECK LIST

NO. OF BEDROOMS	WATER MAIN SIZE, LOCATION
DIMENSIONS	SAN. SEWER SIZE % GR. LOC.
BEARINGS	SAN. MH. CAST. ELEV. INV. ELEV.
TIE TO NEAREST STREET	SAN. CONN. SIZE, LOC. DEPTH
SUBLOT NO. PARCEL NO.	STORM SEWER SIZE % GR. LOC.
SURROUNDING OWNERS	STORM MH. CAST. ELEV. INV. ELEV.
BLDG. DIMENSIONS FIN. GR.	PAV'T TYPE GRADE CURBS
BLDG. TIES FL'R. GRADES	GAS LINE LOC. SIZE PRESSURE
APRON TYPE WIDTH THICKNESS	SEPTIC TANK LOCATION & DUPLICATION AREA
SIDEWALK TYPE WIDTH THICKNESS	WELL LOCATION
CULVERT TYPE DIA. LENGTH	ISOLATION RADIUS FROM WELL
ROCK OUTCROPPINGS	

REVISIONS

NO.	DATE	BY
1		
2		
3		
4		
5		

PLAN PREPARED BY:

DEBEVEC-SALO & ASSOCIATES, INC.

130 EAST JACKSON ST. PAINESVILLE, OHIO

DRAWN BY *JS* SCALE **1"=40'** PHONE NO. **352-9250**
CHK'D. *JS* DATE **4 Aug 76** DRAWING NO. **4438-44**
CREW CHIEF *JS* APP'D. *JS*