

SITE PLAN

PAINE SYLLE LAKE COUNTY, OHIO

for: DELBERT & DAWN ALLEN

33 E WALNUT ST. PAINES. 44077

ADDRESS CITY ZIP

PROP RIDGEWOOD SUB
SUBDIVISION VOL. 11-100A-02-001
SUBLOT NO. 11 FAIRGROUNDS RD PERM TARGET NO. 11

LEGEND

SANITARY MANHOLE
STORM MANHOLE
INLET OR CATCH BASIN
HYDRANT
EXISTING CONTOURS
PROPOSED CONTOURS
EXIST. ELEV. 100.0
PROP. ELEV. 100.0

WATER VALVE (GAS)
WATER METER (GAS)
AS BUILT ELEVATION
INDICATES DIRECTION OF SURFACE DRAINAGE

REMARKS

ALL BOUNDARY DATA SHOWN WAS OBTAINED FROM (DEEDS, RECORDED, SUBDIVISION PLAT OR OTHER PUBLIC RECORDS)
LOCATIONS AS SHOWN OF ADJACENT WELLS AND SEPTIC TANKS OBTAINED FROM LAKE COUNTY HEALTH DEPARTMENT

DESIGN CERTIFICATION

THIS PLAT WAS PREPARED BY ME, AND IS CORRECT TO THE BEST OF MY KNOWLEDGE AND BELIEF.

NAME SURVEYOR REGISTRATION NO. 4514

CHECK LIST

NO. OF BEDROOMS
DIMENSIONS
BEARINGS
TIE TO NEAREST STREET
SUBLOT NO. AND DIST. TO CORNER
BLDG. DIMENSIONS FIN. GR.
BLDG. TYPE, GRADES
APPROX. TYPE WIDTH THICKNESS
SIDEWALK TYPE WIDTH THICKNESS
CULVERT TYPE DIA. LENGTH
ROCK OUTCROPPINGS

WATER MAIN SIZE, LOCATION
SAN. SEWER SIZE, % GR. LOC.
SAN. MH. CAST. ELEV. INV. ELEV.
SAN. CONN. SIZE, LOC. DEPTH
STORM SEWER SIZE, % GR. LOC.
STORM MH. CAST. ELEV. INV. ELEV.
PAVING TYPE, GRADE CURVES
GAS LINE LOC. SIZE PRESSURE
SEPTIC TANK LOCATION & DUPLICATION AREA
WELL LOCATION
ISOLATION RADII FROM WELL

PLAN PREPARED BY:

A. GERBERA

NO. DATE BY
1 10-24-86
2 10-24-86
3 10-24-86
4 10-24-86
5 10-24-86

DRAWN BY F. S. S. SCALE 1" = 20'
CHKD. DATE 10-24-86
CREW F. S. APPD. 86010500

172 NO. ST. CLAIR PAINESVILLE, OHIO

"AS BUILT" CERTIFICATION


I, HEREBY CERTIFY THAT THE CIRCLED GRADES ARE EXISTING FINISH GRADES CHECKED IN THE FIELD ON 19 AND ARE CORRECT TO THE BEST OF MY KNOWLEDGE AND BELIEF.

REGISTERED SURVEYOR REG. NO. 1624

BENCHMARK - SW CAP BOLT FIRE HYDRANT ELEV. 100.00 (ASSUMED).

NOTE: SITE PLAN AMENDED 11/21/89 TO DELBERT & DAWN ALLEN SPACE AND NO. BASEMENT.

DAVID J. LEPISTO P.S. REG. NO. 1624

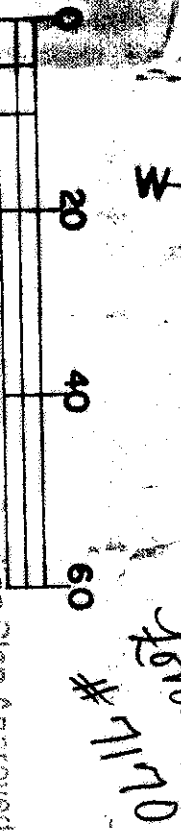

Existing Plan Approved
as shown and/or noted
THOMAS P. GILLES, P.E.
LAKE COUNTY ENGINEER

