

SITE PLAN

PAINESVILLE TOWNSHIP, LAKE COUNTY, OHIO

for: **WILHELM BUILDERS, INC.**

CLIENT OWNER

ADDRESS STREET CITY ZIP

SUBDIVISION	NAME	LOT	TRACT
VOL. - PG.		30	1372
SUBLOT NO.	STREET	VOLUME	PAGE
		1-8	1372
		PERM. PARCEL NO.	STREET

SANITARY MANHOLE	WATER VALVE (GAS)
STORM MANHOLE	WATER METER (GAS)
INLET OR CATCH BASIN	AS BUILT ELEVATION
HYDRANT	
EXISTING CONTOURS	INDICATES DIRECTION OF SURFACE DRAINAGE
PROPOSED CONTOURS	
EXIST. ELEV.	100.0
PROP. ELEV.	100.0

REMARKS

ALL BOUNDARY DATA SHOWN WAS OBTAINED FROM IDEEDS, RECORDED SUBDIVISION PLAT OR OTHER PUBLIC RECORDS)

LOCATIONS AS SHOWN OF ADJACENT WELLS AND SEPTIC TANKS OBTAINED FROM LAKE COUNTY HEALTH DEPARTMENT

DESIGN CERTIFICATION

THIS PLAN WAS PREPARED BY ME, AND IS CORRECT TO THE BEST OF MY KNOWLEDGE AND BELIEF.

NAME: **Harry S. Jones, Jr.** SURVEYOR REGISTRATION NO. **50343**

CHECK LIST

NO. OF BEDROOMS	WATER MAIN SIZE, LOCATION
DIMENSIONS	SAN. SEWER SIZE % GR. LOC.
THE TO NEAREST STREET	SAN. MH. CAST. ELEV. INV. ELEV.
SUBLOT NO. PARCEL NO.	SAN. CONN. SIZE, LOC. DEPTH
SURROUNDING OWNERS	STORM SEWER SIZE % GR. LOC.
BIDG. DIMENSIONS FIN. GR.	STORM MH. CAST. ELEV. INV. ELEV.
ADJ. TYPE ELEV. OR THICKNESS	PAV'T TYPE GRADE CURBS
SEPTIC TANK TYPE WIDTH THICKNESS	GAS LINE LOC. SIZE PRESSURE
CLIVERT TYPE DIA. LENGTH	SEPTIC TANK LOCATION & DUPPLICATION AREA
ROCK OUTCROPPINGS	WELL LOCATION
	ISOLATION RADIUS FROM WELL

PLAN PREPARED BY:

BABCOCK • JONES & ASSOCIATES, INC.

PAINESVILLE, OHIO

NO.	DATE	BY	SCALE	PHONE NO.
1			1" = 30'	357-1811
2				
3				
4				
5				

CREW CHIEF: **12** APPD. **87-104**

"AS BUILT" CERTIFICATION

I, HEREBY CERTIFY THAT THE CIRCLED GRADES ARE EXISTING FINISH GRADES CHECKED IN THE FIELD ON 19

AND ARE CORRECT TO THE BEST OF MY KNOWLEDGE AND BELIEF.

REGISTERED SURVEYOR REG. NO.


SEWAGE DISPOSAL PERMIT MUST BE OBTAINED BY A LAKE COUNTY LICENSED INSTALLER BEFORE INSTALLATION IS STARTED.

THIS PERMIT EXPIRES 5-7-89



PAINESVILLE TOWNSHIP ZONING APPROVED # 6678 W. E. S. M. 5/7/87 To the Inspector

Grading Plan Approved as shown and/or noted by **THOMAS P. GILLES, P.E.** Lake County Engineer

By: **THP** Date: **5.1.87**

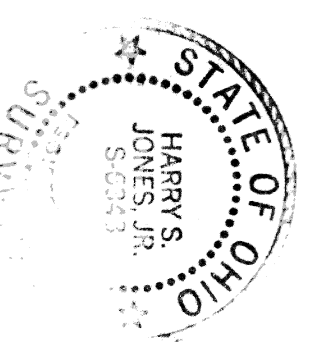

Reviewed and Accepted
LAKE COUNTY GENERAL HEALTH DISTRICT
JOEL LUCIA, R. S., M. P. H.
Health Commissioner
Date: **5-7-87**

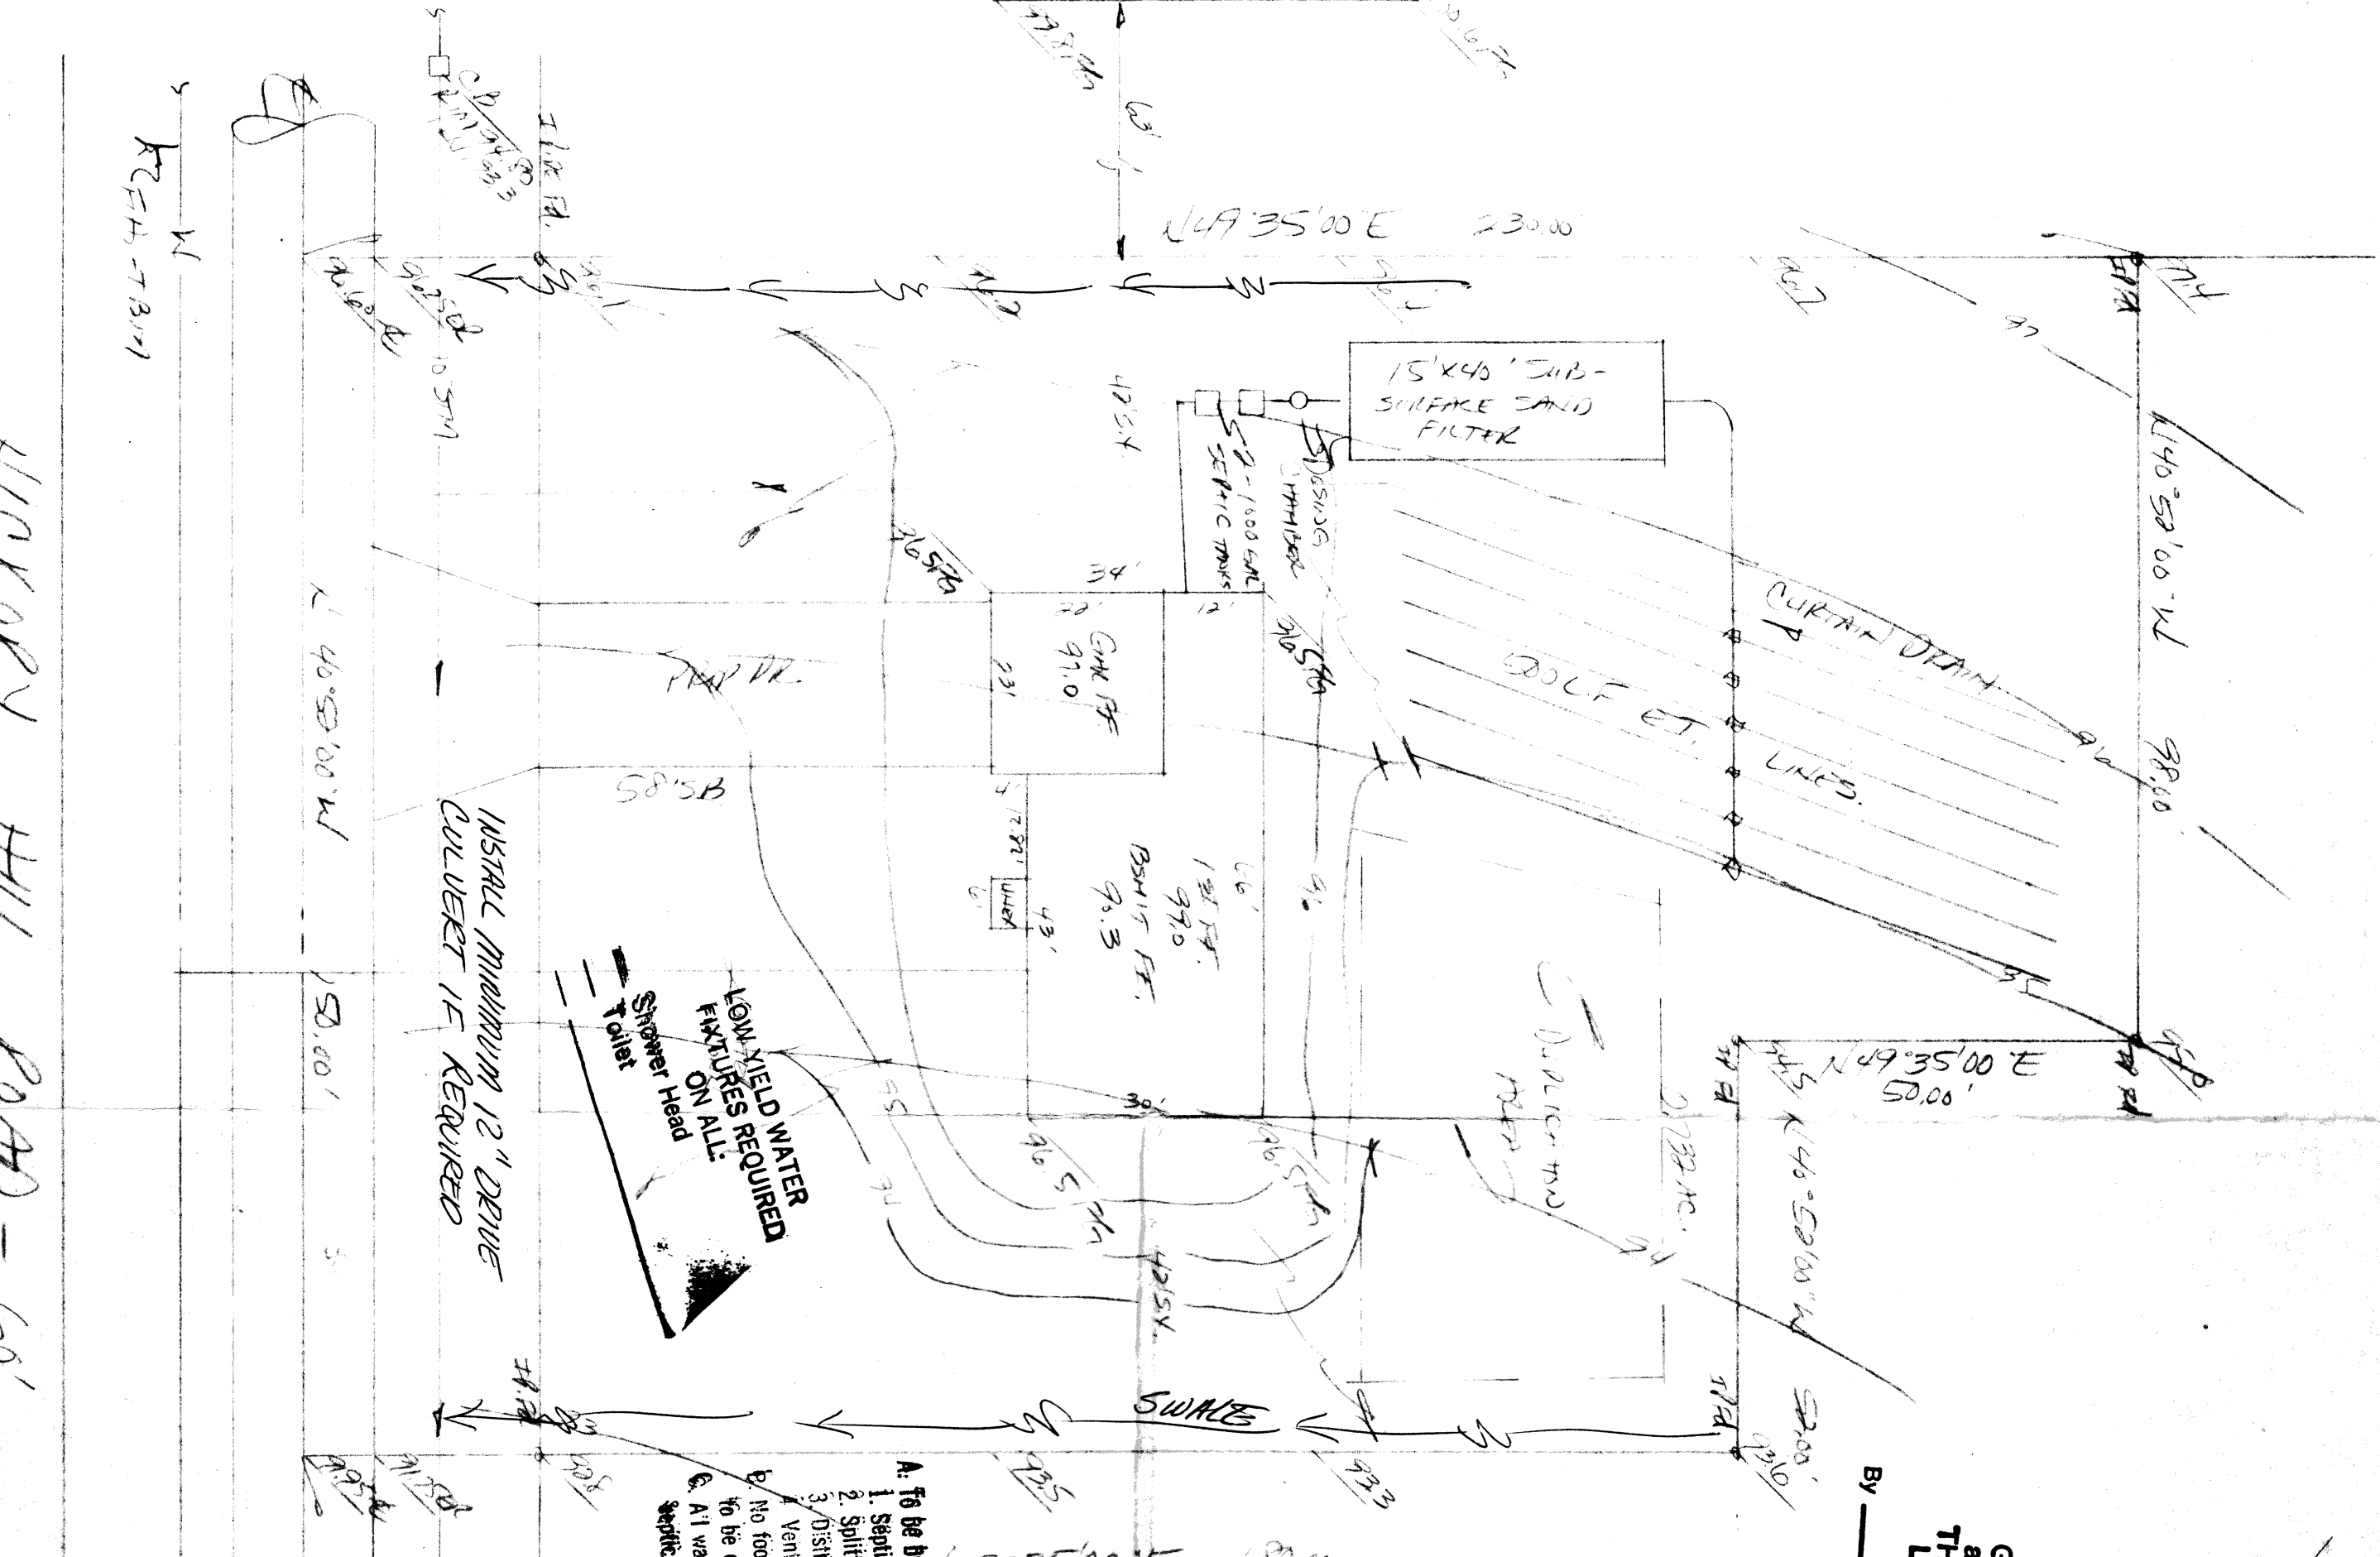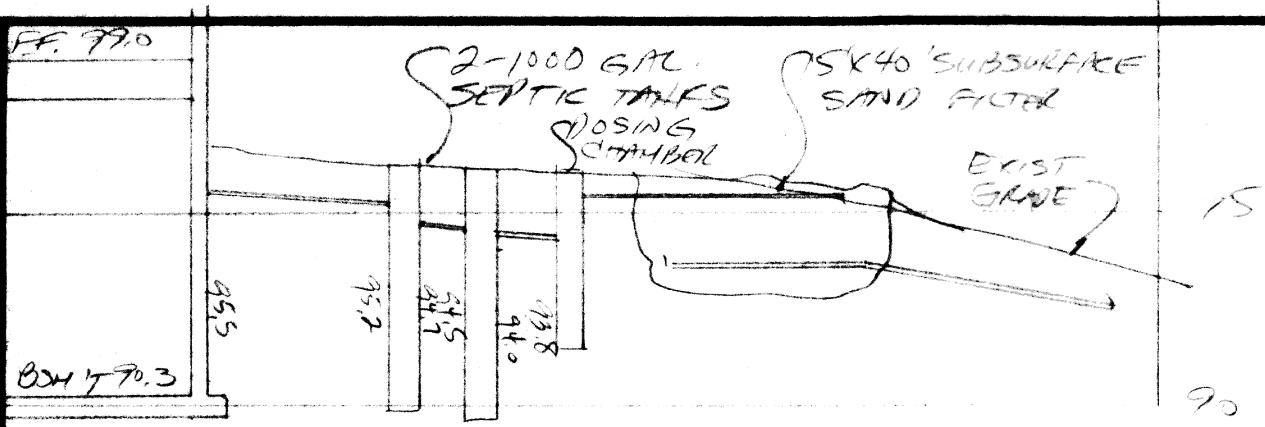

HICKORY HILL ROAD - 60'