


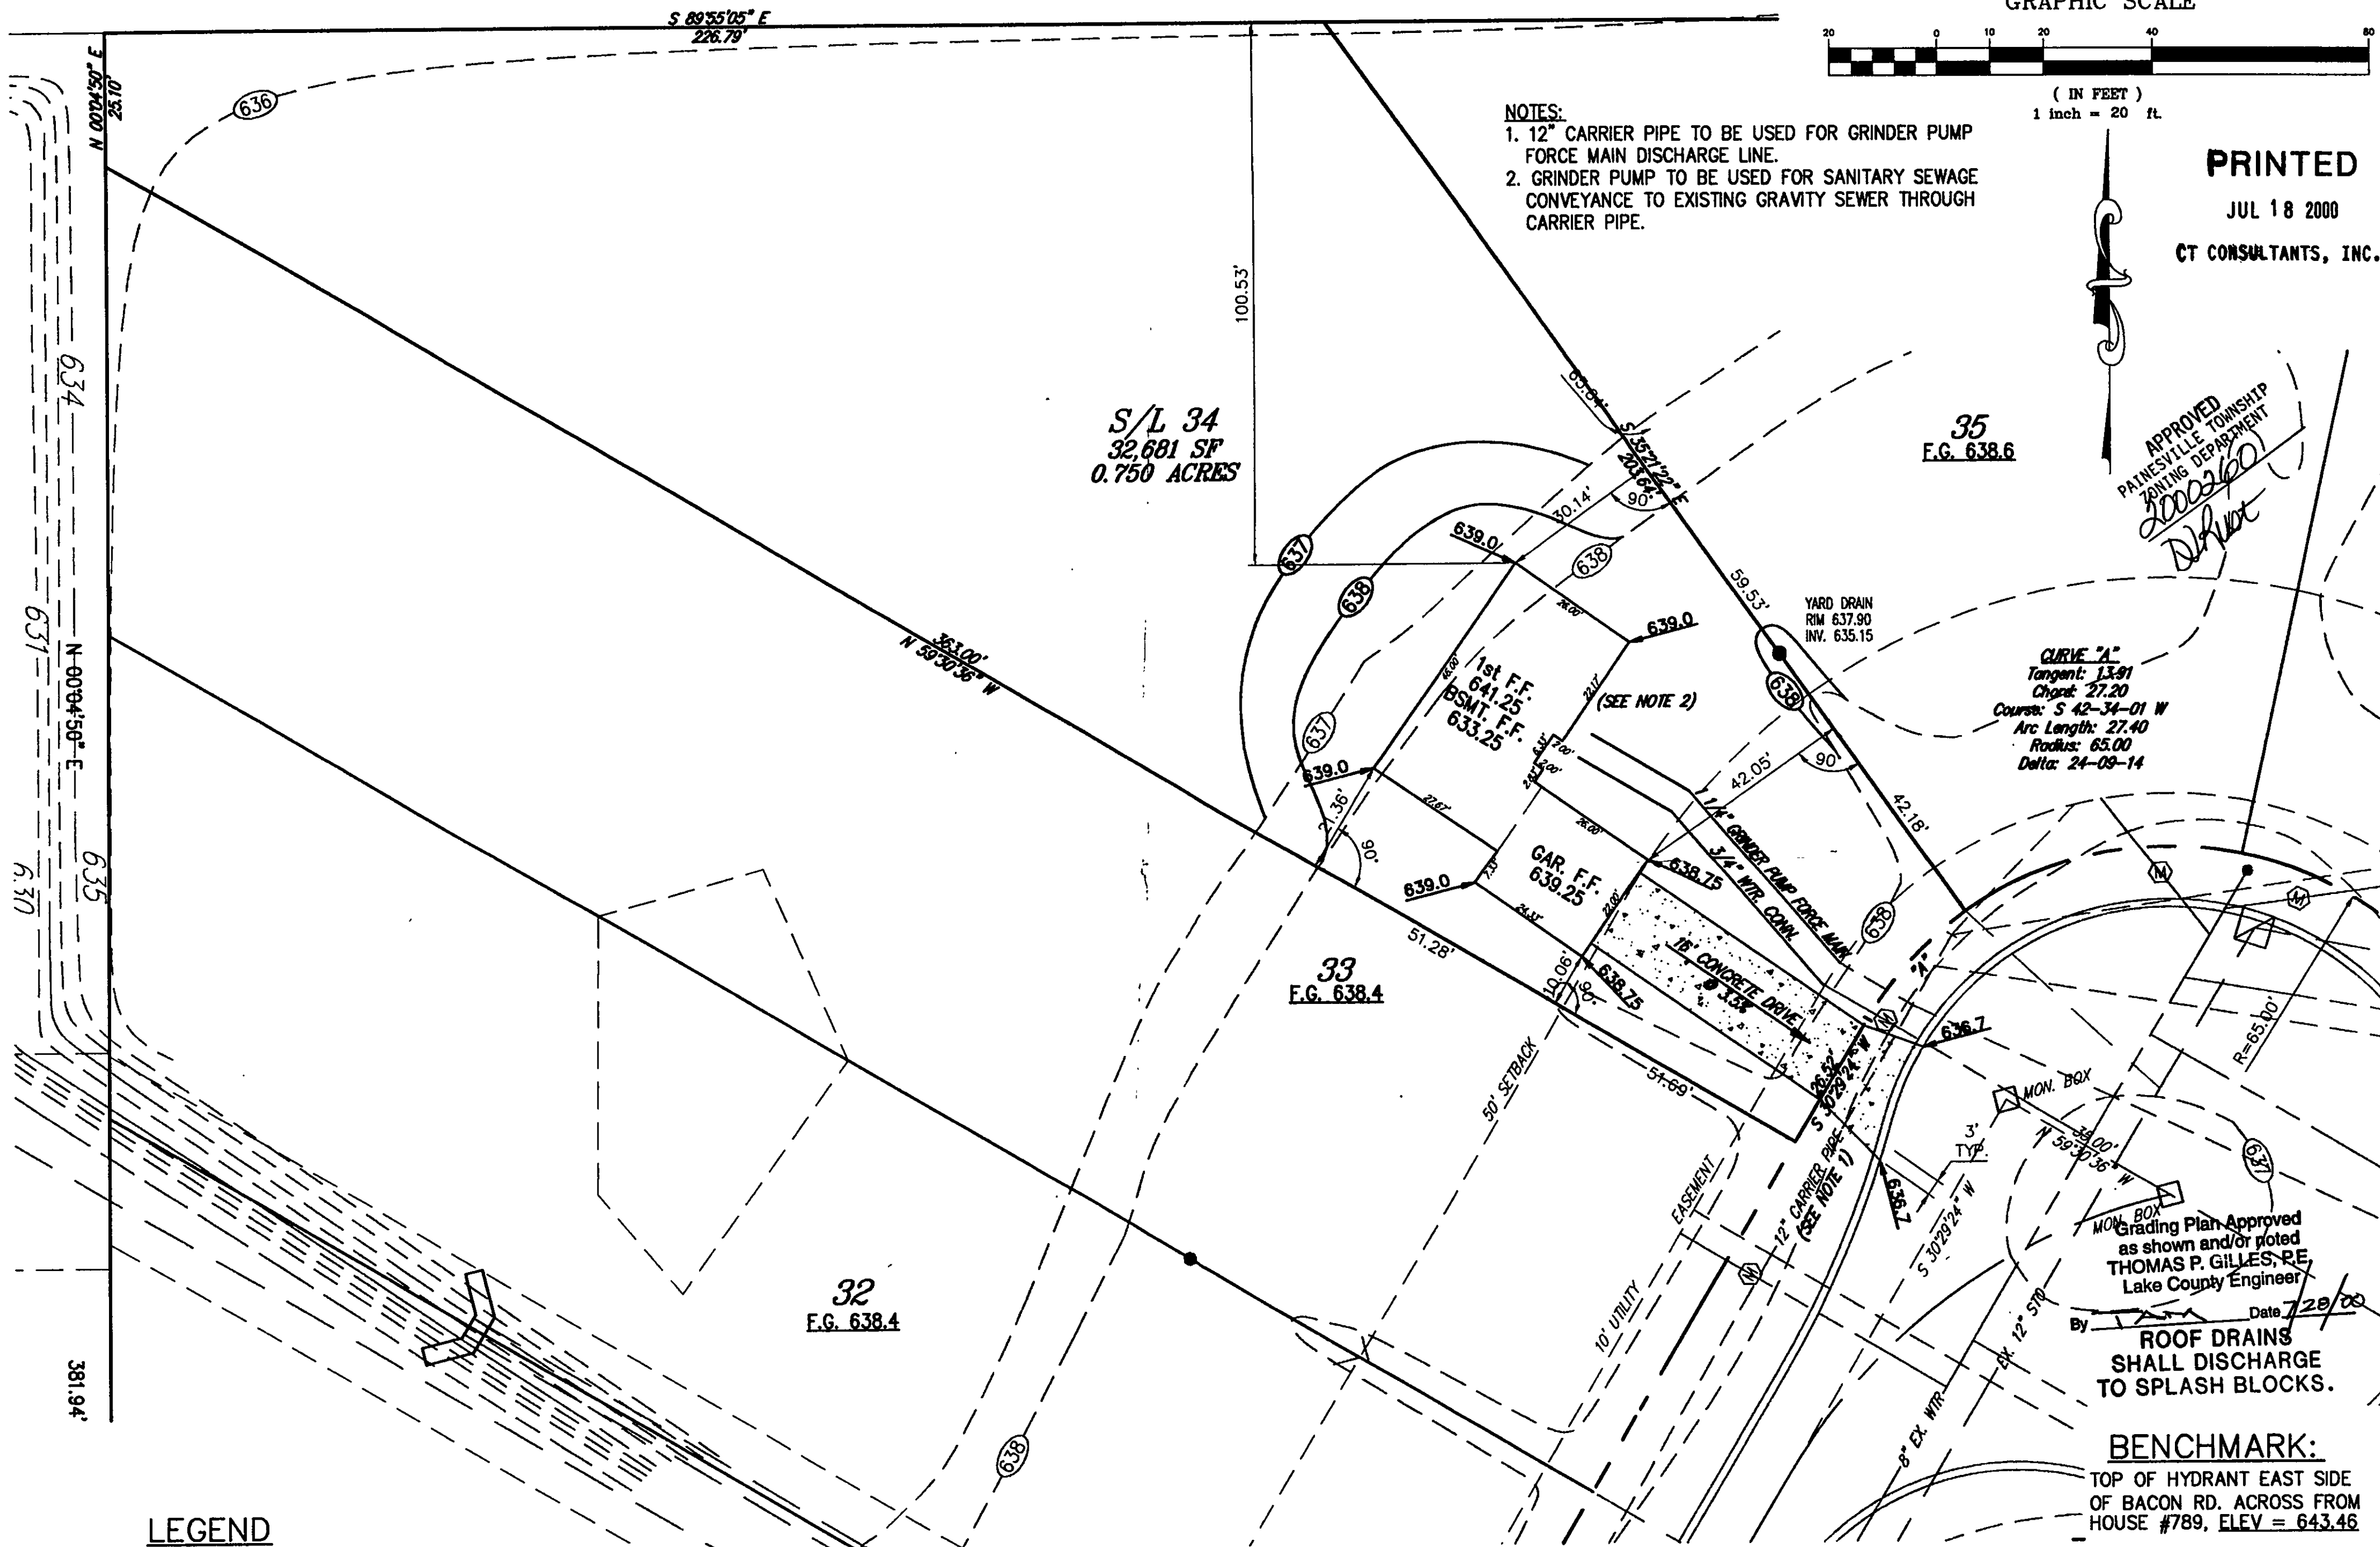

GRAPHIC SCALE



(IN FEET)
1 inch = 20 ft.

PRINTED

JUL 18 2000

CT CONSULTANTS, INC.

NOTES:

1. 12" CARRIER PIPE TO BE USED FOR GRINDER PUMP FORCE MAIN DISCHARGE LINE.
2. GRINDER PUMP TO BE USED FOR SANITARY SEWAGE CONVEYANCE TO EXISTING GRAVITY SEWER THROUGH CARRIER PIPE.

APPROVED
PAINESVILLE TOWNSHIP
ZONING DEPARTMENT
2000.60
Dr. [Signature]

CURVE "A"
Tangent: 13.91
Chord: 27.20
Course: S 42-34-01 W
Arc Length: 27.40
Radius: 65.00
Delta: 24-09-14

Grading Plan Approved
as shown and/or noted
THOMAS P. GILLES, P.E.
Lake County Engineer

ROOF DRAINS
SHALL DISCHARGE
TO SPLASH BLOCKS.

BENCHMARK:
TOP OF HYDRANT EAST SIDE
OF BACON RD. ACROSS FROM
HOUSE #789, ELEV = 643.46

LEGEND

- 639.4 F.G. PROPOSED GRADES
- 639.4 F.S. PROPOSED SURFACES
- 641.70 H.P. EXISTING GRADES
- 641 EXISTING CONTOURS
- 639 PROPOSED CONTOURS

CERTIFICATION

I HEREBY CERTIFY THAT THIS PLAT WAS
PREPARED BY ME AND IS CORRECT TO THE
BEST OF MY KNOWLEDGE AND BELIEF.

BY: Stephen L. Guard
STEPHEN L. GUARD, P.E. 52784

SITE PLAN for:

EDWARD H. TRESGER, INC.

8100 DEEPWOOD BLVD. MENTOR, OHIO 44060

BEING SUBLOT NO. 34 IN THE PINES SUBDIVISION NO. 5 IN PAINESVILLE TOWNSHIP, OHIO.

DATE JULY 2000
SCALE 1"=20'
DRAWN BY K.P.A.
CHKD BY S.L.G.
F.B.# PG



CT Consultants, Inc.
Engineers • Architects • Planners
Willoughby • Mentor • Columbus • North Canton • Youngstown

SHEET 1 OF 1
CONTRACT NO. 94290