

1/2

SITE PLAN

PAINESVILLE TWP., LAKE COUNTY, OHIO
for: HABITAT FOR HUMANITY

ADDRESS		STREET	CITY	ZIP
SUBDIVISION		NAME	TRACT	STREET
19, Block 9		D-60	3	LOT
SUBLOT NO.		MIDWAY BLVD	VOL.-PG.	11B-43B-89
		STREET	VOL.-PG.	PERM. PARCEL NO.

LEGEND

- SANITARY MANHOLE
 - STORM MANHOLE
 - INLET OR CATCH BASIN
 - HYDRANT
 - EXISTING CONTOURS
 - PROPOSED CONTOURS
- EXIST. ELEV. 100.0
100.0 ± PROP. ELEV.
- AS BUILT ELEVATION
- INDICATES DIRECTION OF SURFACE DRAINAGE

REMARKS

ALL BOUNDARY DATA SHOWN WAS OBTAINED FROM (DEEDS, RECORDED SUBDIVISION PLAT OR OTHER PUBLIC RECORDS)

LOCATIONS AS SHOWN OF ADJACENT WELLS AND SEPTIC TANKS OBTAINED FROM LAKE COUNTY HEALTH DEPARTMENT

DESIGN CERTIFICATION

THIS PLAT WAS PREPARED BY ME, AND IS CORRECT TO THE BEST OF MY KNOWLEDGE AND BELIEF.

NAME SURVEYOR REGISTRATION NO.

CHECK LIST

- | | |
|-------------------------------|---|
| NO. OF BEDROOMS | WATER MAIN SIZE, LOCATION |
| DIMENSIONS | SAN. SEWER SIZE & GR. LOC. |
| BEARINGS | SAN. MH. CAST. ELEV. INV. ELEV. |
| TIE TO NEAREST STREET | SAN. CONN. SIZE, LOC. DEPTH |
| SUBLOT NO. PARCEL NO. | STORM SEWER SIZE & GR. LOC. |
| SURROUNDING OWNERS | STORM MH. CAST ELEV. INV. ELEV. |
| BLDG. DIMENSIONS FIN GR. | PAY'T TYPE GRADE CURBS |
| BLDG. TIES FL'R. GRADES | GAS LINE LOC. SIZE PRESSURE |
| APRON TYPE WIDTH THICKNESS | SEPTIC TANK LOCATION & DUPLICATION AREA |
| SIDEWALK TYPE WIDTH THICKNESS | WELL LOCATION |
| CULVERT TYPE DIA., LENGTH | ISOLATION RADIUS FROM WELL |
| ROCK OUTCROPPINGS | |

REVISIONS

NO.	DATE	BY
1		
2		
3		
4		
5		


PLAN PREPARED BY:		BACOCK JONES & ASSOCIATES, INC.	
PAINESVILLE, OHIO			
DRAWN BY	B.P.	SCALE	1"=20'
CHK'D.	H.J.	DATE	1/6/09
CREW CHIEF	R.B.	APP'D	H.J.
		PHONE NO.	440-357-1811
		DRAWING NO.	08 118

"AS BUILT" CERTIFICATION
I, HEREBY CERTIFY THAT THE CIRCLED GRADES ARE EXISTING FINISH GRADES CHECKED IN THE FIELD ON 20 AND ARE CORRECT TO THE BEST OF MY KNOWLEDGE AND BELIEF.

REGISTERED SURVEYOR REG. NO.

BM - SANITARY MANHOLE
ELEV - 627.42

GRAPHIC SCALE

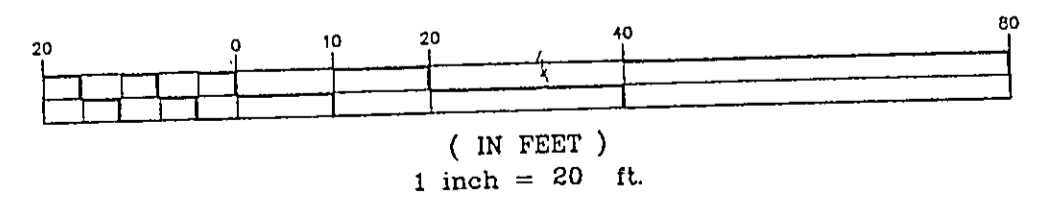

This project is exempt from
ESC Plan Review
Date 5-4-09
Lake SWCF

Stormwater Management Plan
Approved as shown and/or noted
JAMES R. GILLS, P.E.
County Drainage Engineer
By Date 5-5-09

EXISTING UTILITIES NOTE:
THE SIZE AND LOCATION, BOTH HORIZONTAL AND VERTICAL OF THE UNDERGROUND UTILITIES SHOWN HEREON, HAVE BEEN OBTAINED BY A SEARCH OF AVAILABLE RECORDS. VERIFICATION BY FIELD OBSERVATION HAS BEEN CONDUCTED WHERE PRACTICAL, HOWEVER, BACOCK, JONES AND ASSOCIATES INC. DOES NOT GUARANTEE THE COMPLETENESS NOR ACCURACY THEREOF.

