




LEACHING TRENCH
CROSS SECTION

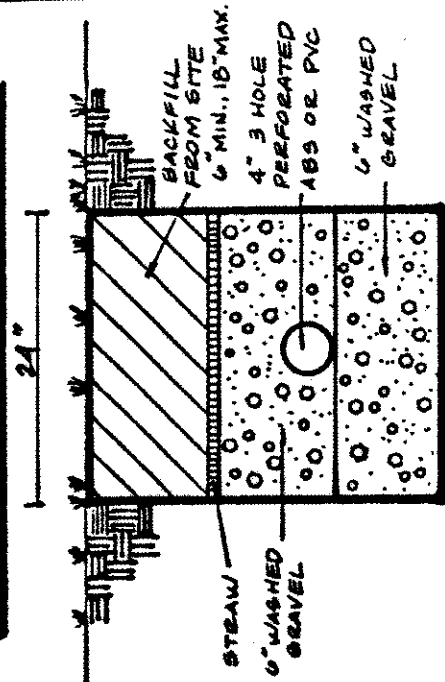

PT. 5/12
CINDI M. SIEDLARZYL
V. 685-405
118-33A-95

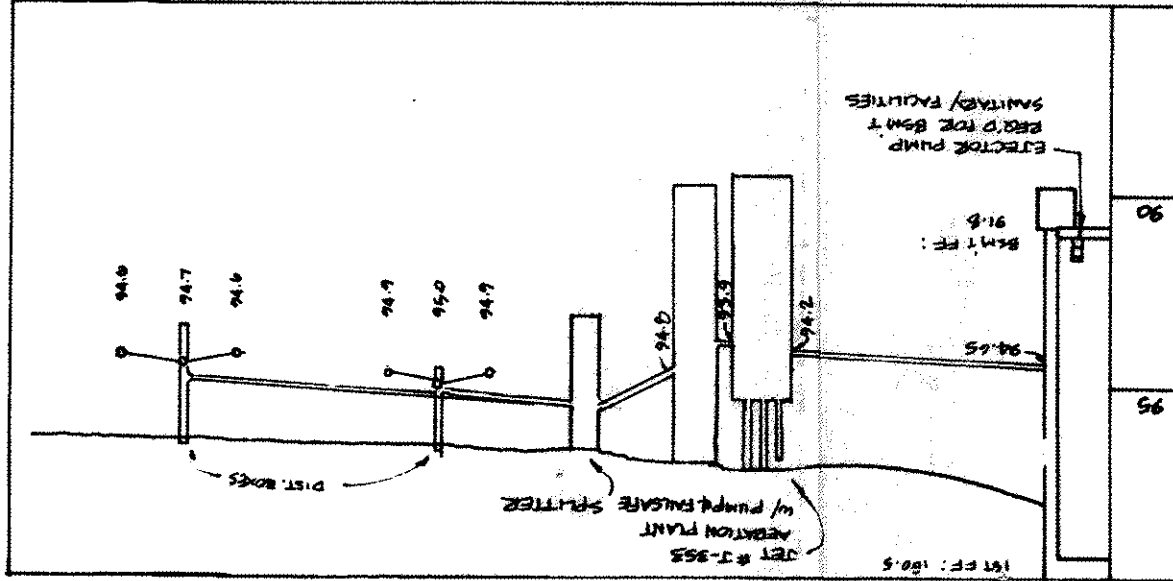

HYDRAULIC PROFILE
HORIZ. 1" = 30', VERT. 1" = 5'

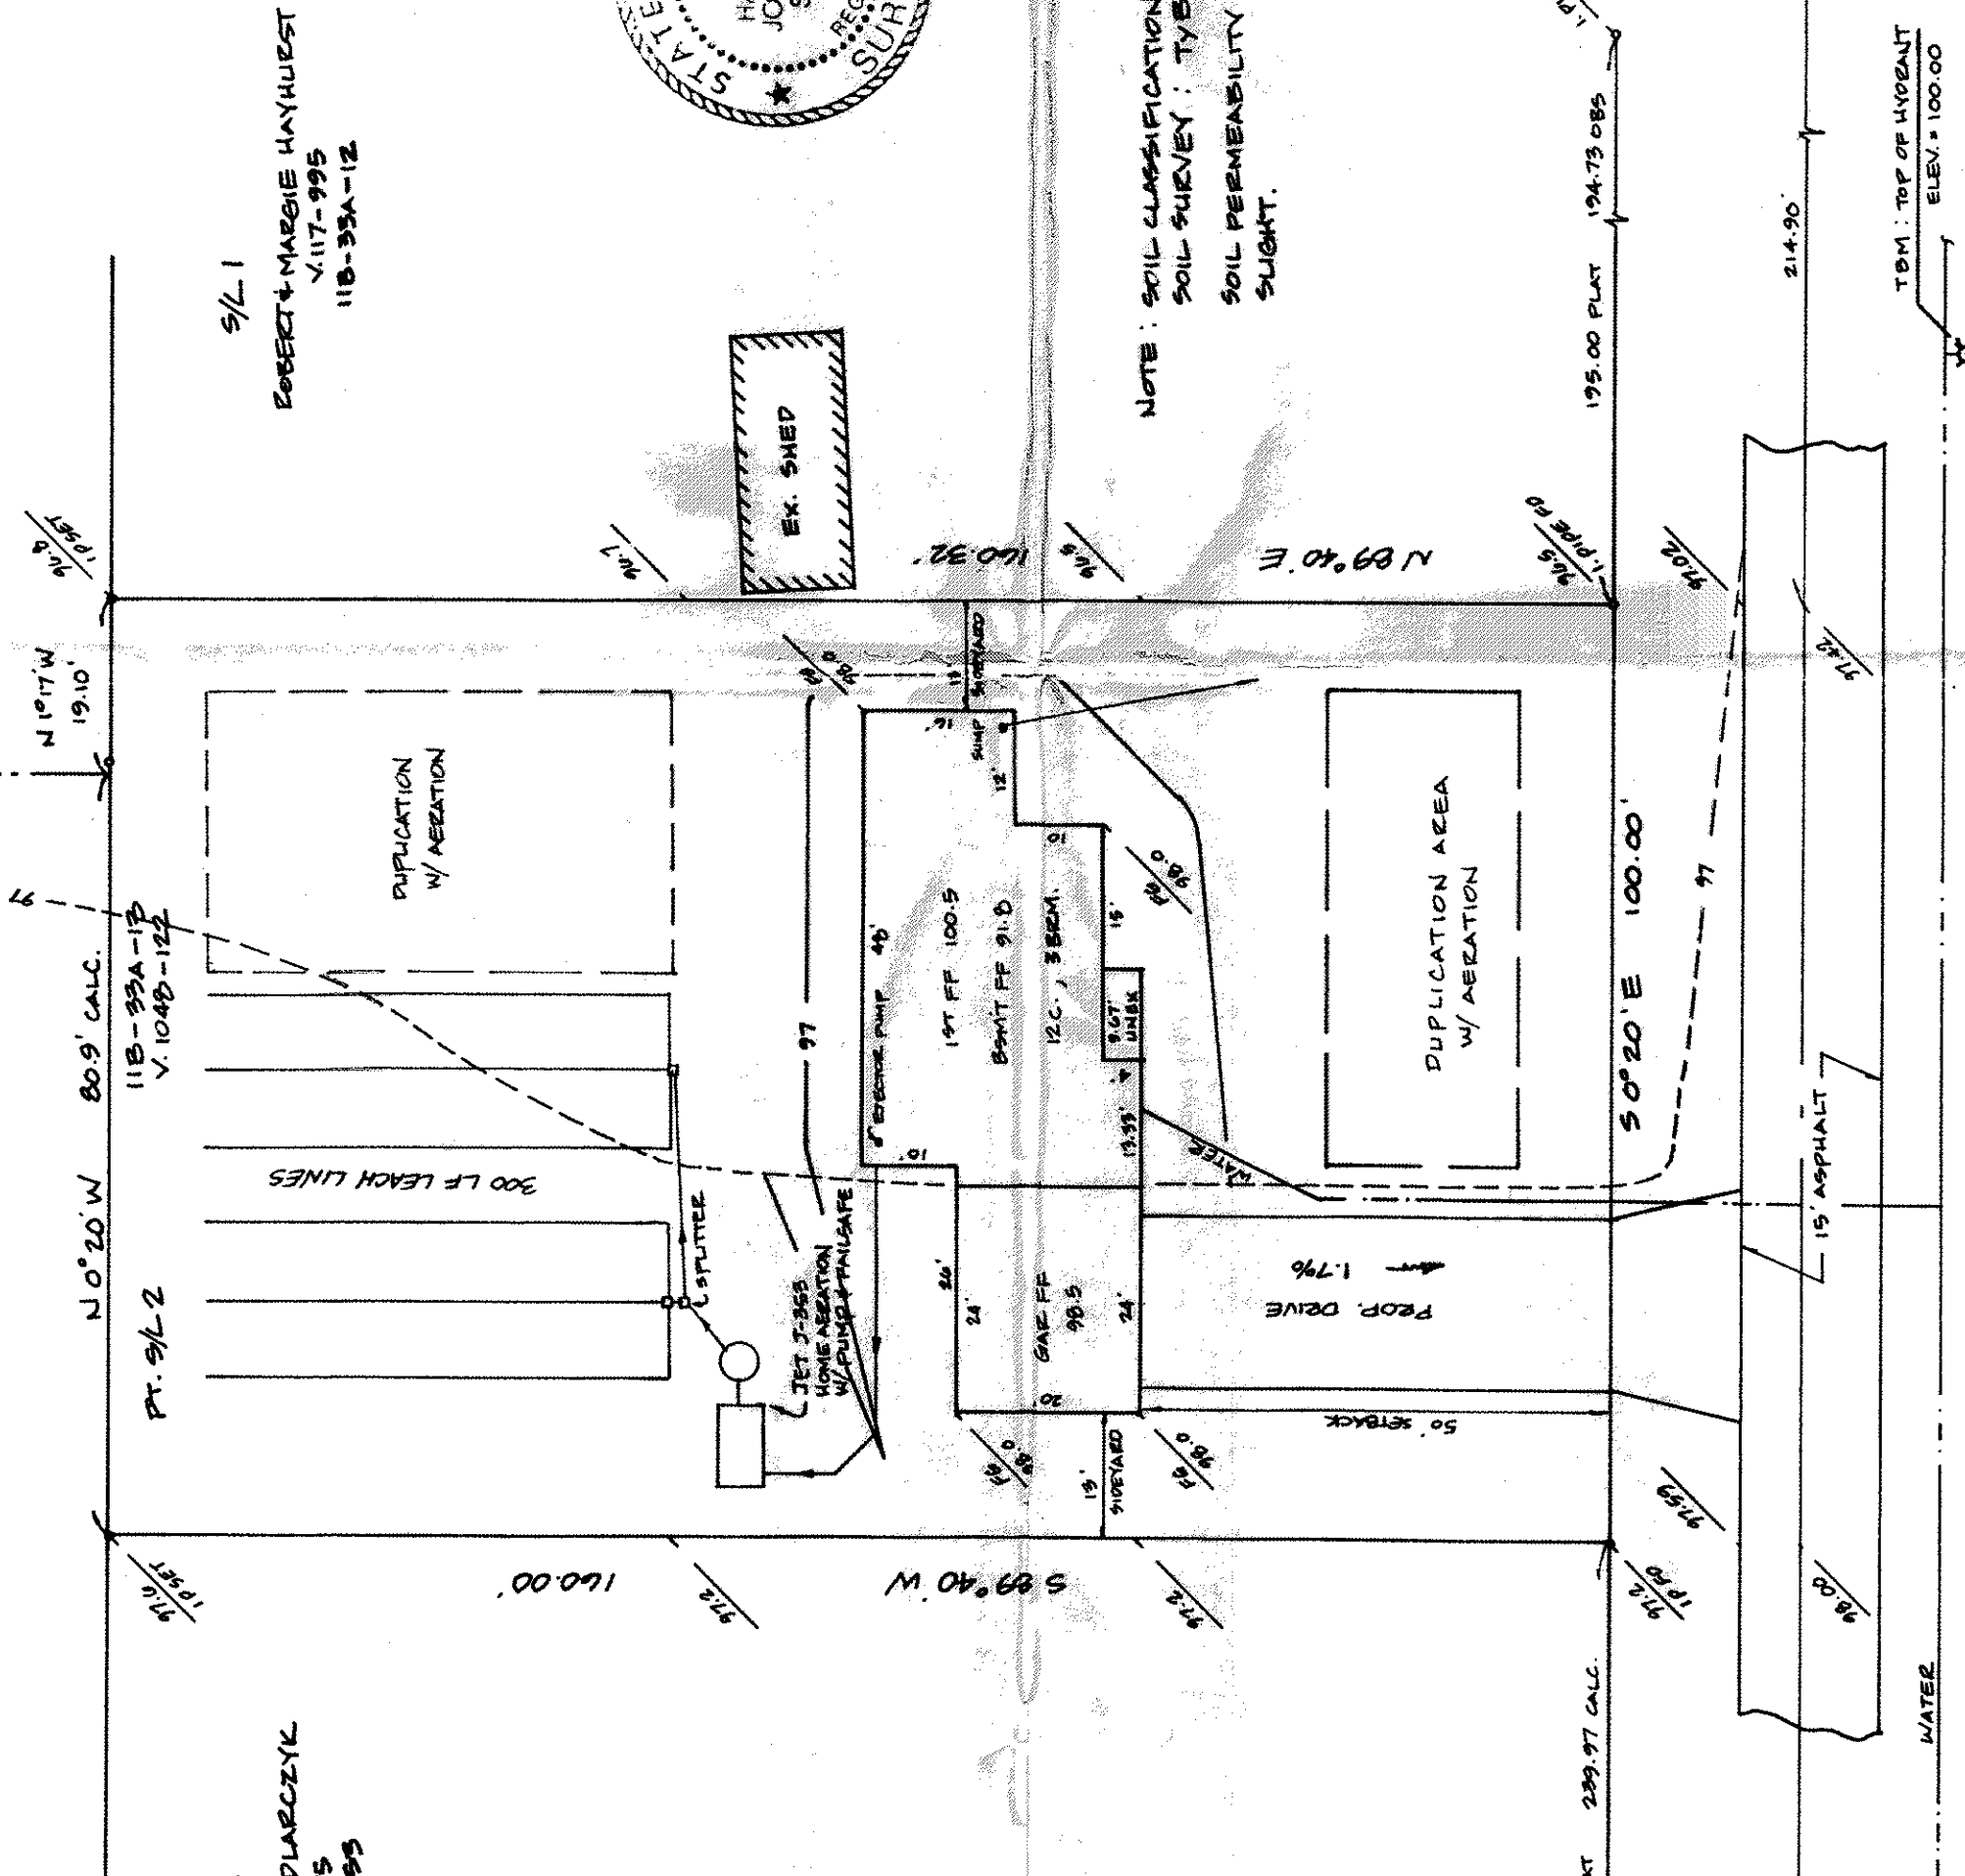

NOTE: SOIL CLASSIFICATION PER L.C.
SOIL SURVEY: TYS (TYNER)
SOIL PERMEABILITY CLASSIFICATION:
SLIGHT.



SITE PLAN

PAINESVILLE TOWNSHIP, LAKE COUNTY, OHIO
for: R.L. MOORE HOMES INC. 352-4994
CLIENT OWNER
7121 RAVENNA RD. CONCORD OH 44077
ADDRESS STREET CITY

NURSERIES SUBDIVISION
SUBDIVISION 9-144 NAME
PT. 5/12 VOL. 118-33A-13 PERM. PARCEL NO. 44077
SUBLOT NO. STREET

LEGEND

SANITARY MANHOLE
STORM MANHOLE
INLET OR CATCH BASIN
HYDRANT
EXISTING CONTOURS
PROPOSED CONTOURS
EXIST. ELEV. 100.0
100.0 PROP. ELEV.
WATER VALVE (GAS)
WATER METER (GAS)
AS BUILT ELEVATION
INDICATES
DIRECTION OF
SURFACE DRAINAGE

REMARKS

ALL BOUNDARY DATA SHOWN WAS OBTAINED FROM IDEEDS, RECORDED
SUBDIVISION PLAT OR OTHER PUBLIC RECORDS)
LOCATIONS AS SHOWN OF ADJACENT WELLS AND SEPTIC TANKS OBTAINED FROM
LAKE COUNTY HEALTH DEPARTMENT

DESIGN CERTIFICATION

THIS PLAT WAS PREPARED BY ME, AND IS CORRECT
TO THE BEST OF MY KNOWLEDGE AND BELIEF.

NAME SURVEYOR REGISTRATION NO. 8343

CHECK LIST

NO. OF BEDROOMS
DIMENSIONS
TIE TO NEAREST STREET
SUBLOT NO. PARCEL NO.
SURROUNDING OWNERS
BLDG. DIMENSIONS FIN. GR.
APRON TYPE FLR. GRADES
SIDEWALK TYPE WIDTH THICKNESS
ROCK OUTCROPPINGS
WATER MAIN SIZE, LOCATION
SAN. SEWER SIZE, GR. LOC.
SAN. MH. CAST. ELEV. INV. ELEV.
SAN. CONN. SIZE, LOC. DEPTH
STORM SEWER SIZE, GR. LOC.
STORM MH. CAST. ELEV. INV. ELEV.
PAV'T TYPE GRADE CURBS
GAS LINE LOC. SIZE PRESSURE
SEPTIC TANK LOCATION & DUPLICATION AREA
WELL LOCATION
ISOLATION RADIUS FROM WELL

PLAN PREPARED BY:

BABCOCK • JONES & ASSOCIATES, INC.
PAINESVILLE, OHIO

REVISIONS
NO. DATE BY
1 6/16/95
2
3
4
5
DRAWN BY P SCALE 1" = 20' PHONE NO. 357-1811
CHK'D. DATE 6/18/95 DRAWING NO.
CREW APP'D. 95-144
CHIEF

"AS BUILT" CERTIFICATION

I, HEREBY CERTIFY THAT THE CIRCLED GRADES ARE EXISTING
FINISH GRADES CHECKED IN THE FIELD ON 19
AND ARE CORRECT TO THE BEST OF MY KNOWLEDGE AND BELIEF.

REGISTERED SURVEYOR

A. To be brought to finished grade
1. Septic tank manhole covers
2. Spillway box cover
3. Distribution box cover
B. No footer drains or downspouts
to be discharged into septic tanks
C. All waste water to be discharged into
septic tanks

SEWAGE DISPOSAL PERMIT MUST BE
OBTAINED BY A LAKE COUNTY LICENSED
INSTALLER BEFORE INSTALLATION IS
STARTED.

LOW YIELD WATER
FIXTURES REQUIRED
ON ALL:

Shower Head
Toilet

Reviewed and Accepted
LAKE COUNTY GENERAL HEALTH DISTRICT
Date 6-16-95
JOEL LUCIA, R. S., M. P. H.
Health Commissioner
BY J. Lucia

"I, the undersigned hereby certify that
this topography indicated by 6", 1" or 2"
contours, and elevations shown hereon
represent an actual field survey made by
me on the 21st day of June, 1995
and that the elevations were taken at
appropriate intervals and that as of that
date they existed as indicated hereon."

THOMAS P. GILLES, P.E.
Lake County Engineer
Name
Reg. No. 6343

MORGAN DRIVE - 40