



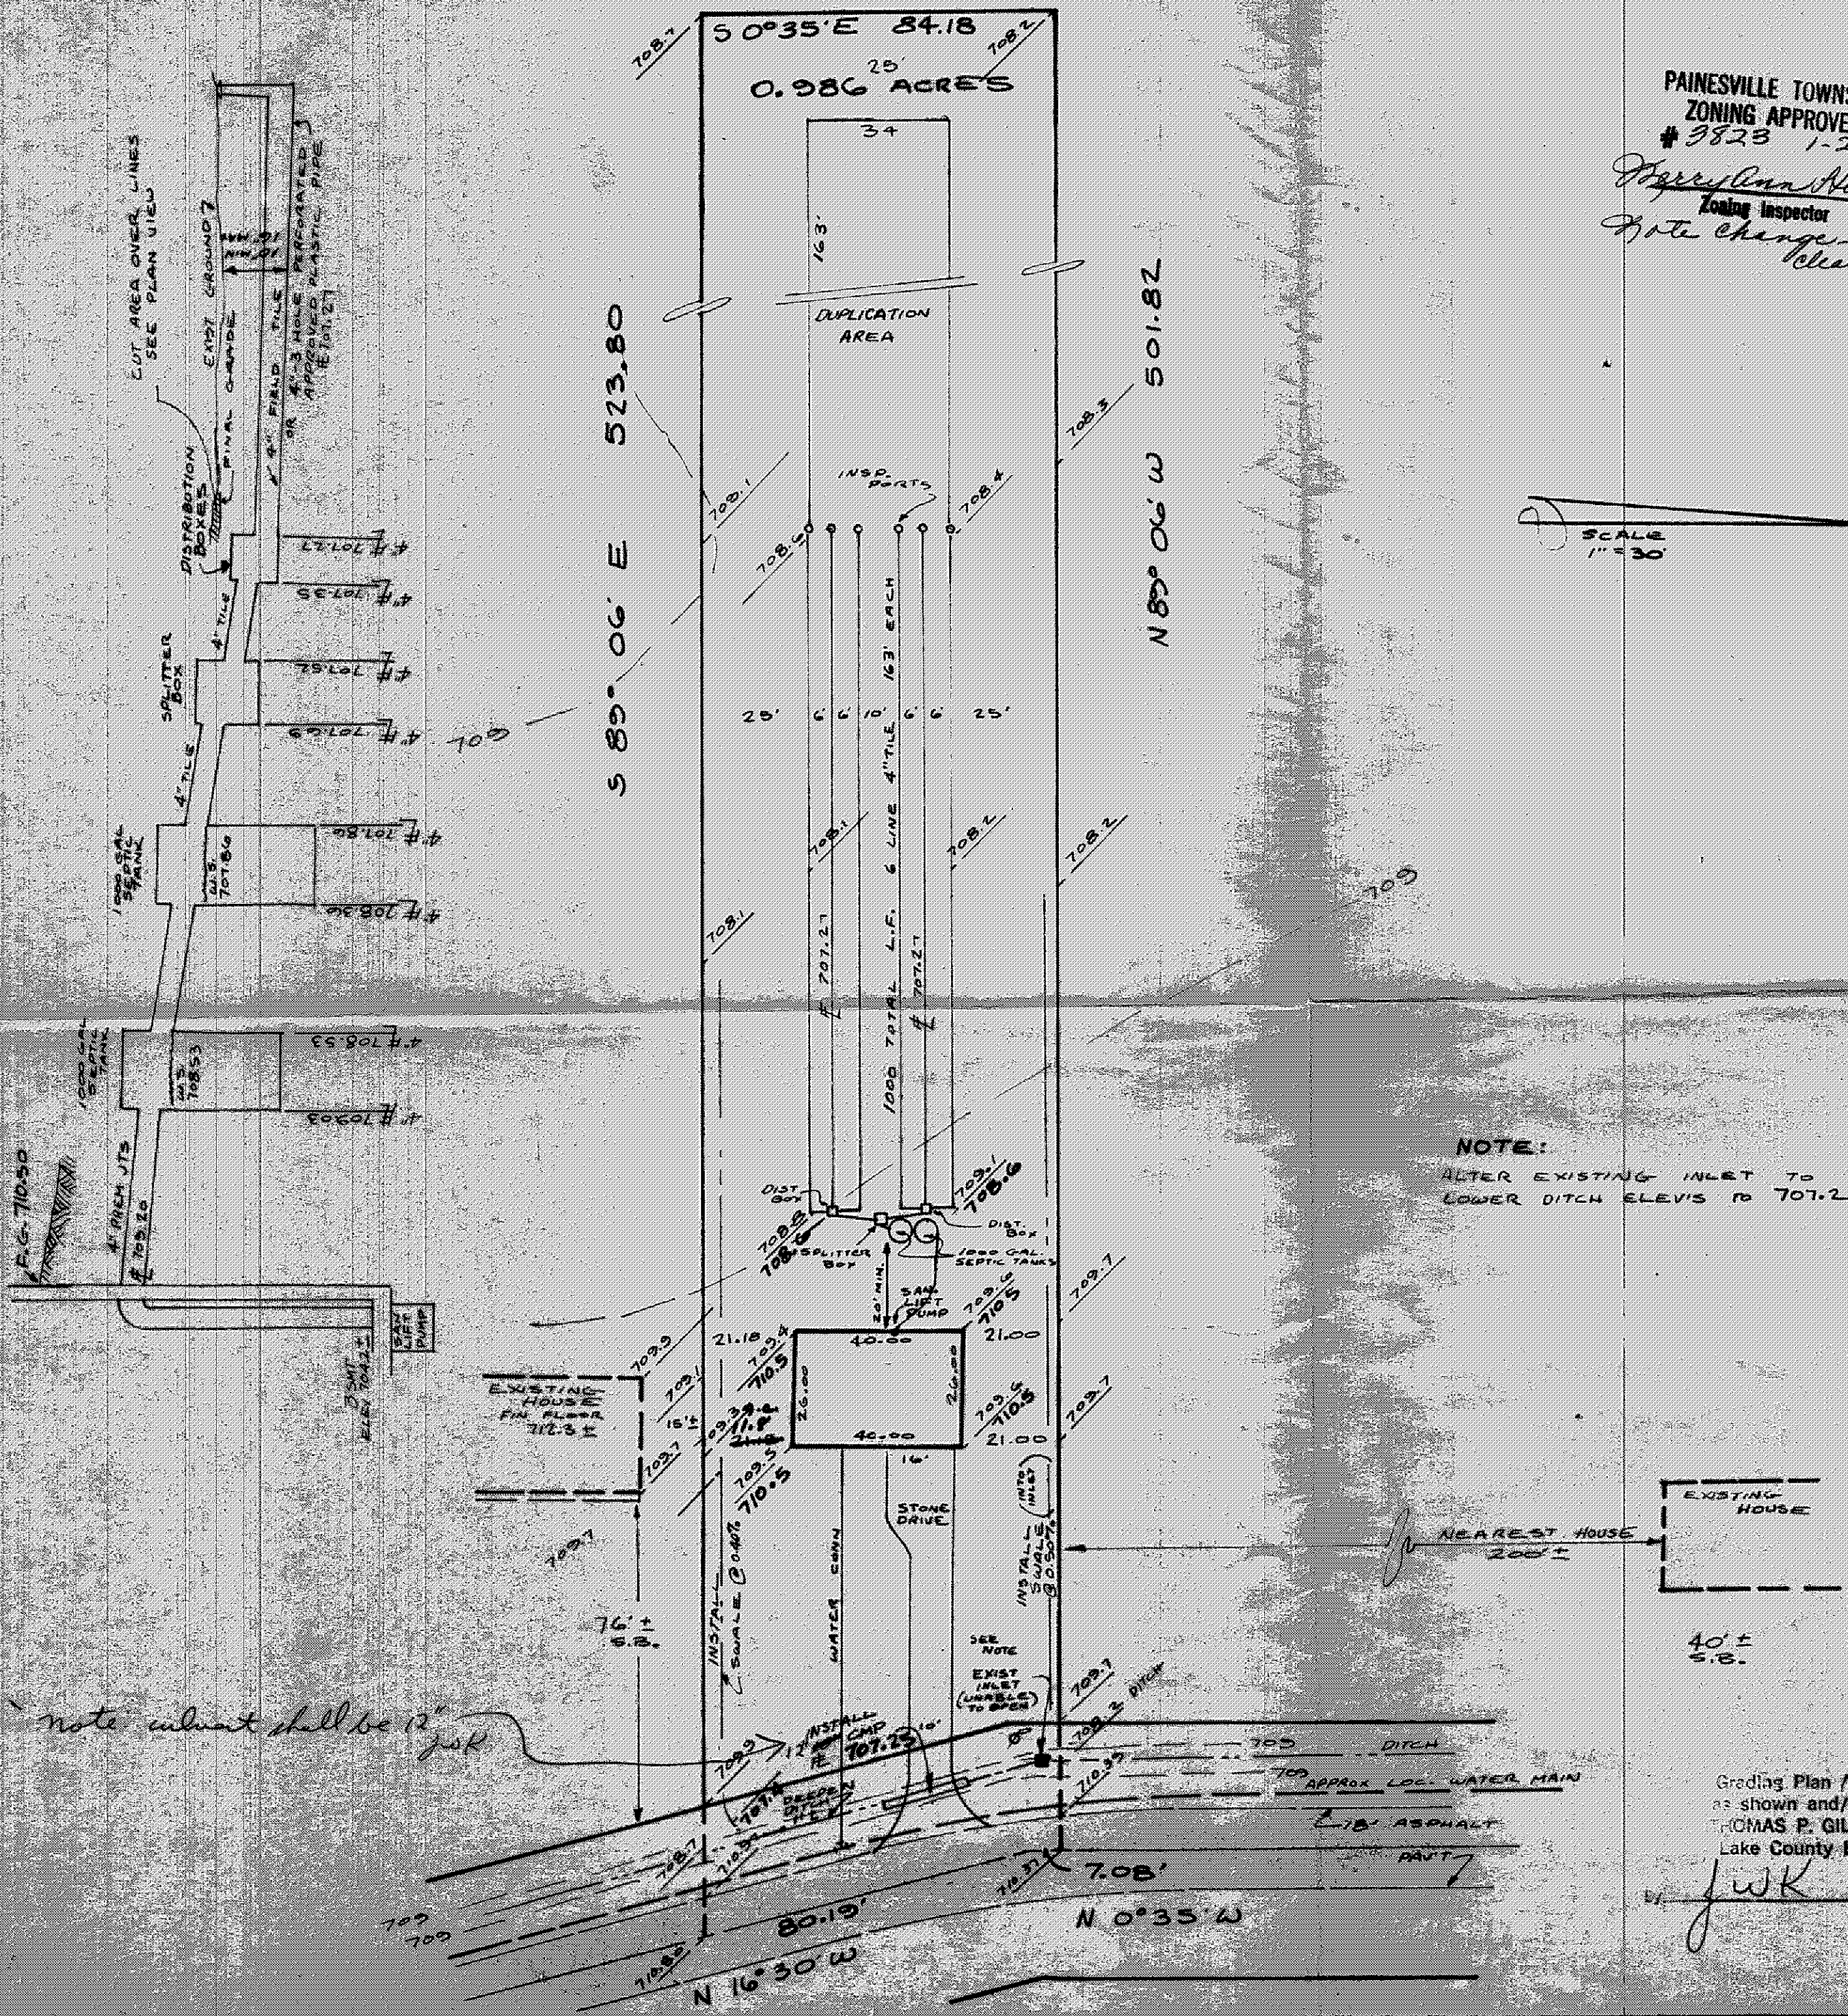

PAINESVILLE TOWNSHIP
 ZONING APPROVED
 # 3823 1-26-76
Harry Ann Henderson
 Zoning Inspector
 Note change left clearance

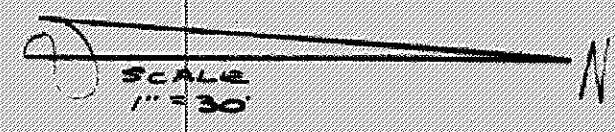

SITE PLAN

PAINESVILLE, OHIO LAKE COUNTY, OHIO

TOWNSHIP

for: **JOS. POROSTOSKY**
 CLIENT OWNER

ADDRESS STREET CITY ZIP

SUBDIVISION	NAME	LOT	TRACT
VOL. PG.		29	1
SUBLOT NO.	STREET	VOLUME	PAGE
		23A-15	PARK RD. EXT
		PERM. PARCEL NO.	STREET

LEGEND

SANITARY MANHOLE	WATER VALVE (GAS)
STORM MANHOLE	WATER METER (GAS)
INLET OR CATCH BASIN	AS BUILT ELEVATION
HYDRANT	
EXISTING CONTOURS	INDICATES DIRECTION OF SURFACE DRAINAGE
PROPOSED CONTOURS	
EXIST. ELEV.	
100.0	
100.0	
100.0	

REMARKS

ALL BOUNDARY DATA SHOWN WAS OBTAINED FROM IDEEDS, RECORDED SUBDIVISION PLAT OR OTHER PUBLIC RECORDS

LOCATIONS AS SHOWN OF ADJACENT WELLS AND SEPTIC TANKS OBTAINED FROM LAKE COUNTY HEALTH DEPARTMENT

DESIGN CERTIFICATION

THIS PLAT WAS PREPARED BY ME, AND IS CORRECT TO THE BEST OF MY KNOWLEDGE AND BELIEF.

Richard J. Debevec PS#5244

NAME SURVEYOR REGISTRATION NO.


CHECK LIST

NO. OF BEDROOMS	WATER MAIN SIZE, LOCATION
DIMENSIONS	SAN. SEWER SIZE, % GR. LOC.
BEARINGS	SAN. MH. CAST. ELEV. INV. ELEV.
TIE TO NEAREST STREET	SAN. CONN. SIZE, LOC. DEPTH
SUBLOT NO. PARCEL NO.	STORM SEWER SIZE, % GR. LOC.
SURROUNDING OWNERS	STORM MH. CAST. ELEV. INV. ELEV.
BLDG. DIMENSIONS FIN. GR.	PAV'T. TYPE GRADE CURBS
BLDG. TIES FLR. GRADES	GAS LINE LOC. SIZE PRESSURE
APPROX. TYPE WIDTH THICKNESS	SEPTIC TANK LOCATION & DUPLICATION AREA
SIDEWALK TYPE DIA. LENGTH	WELL LOCATION
CULVERT TYPE DIA. LENGTH	ISOLATION RADIUS FROM WELL
ROCK OUTCROPPINGS	

REVISIONS			PLAN PREPARED BY:	
NO.	DATE	BY	DEBEVEC - SALO & ASSOCIATES, INC.	
1			130 EAST JACKSON ST. PAINESVILLE, OHIO	
2			DRAWN BY <i>PP</i>	SCALE 1"=30' PHONE NO.
3			CHK'D	DATE JAN 9 75 DRAWING NO.
4			CREW CHIEF	APP'D. 4581

"AS BUILT" CERTIFICATION

I, HEREBY CERTIFY THAT THE CIRCLED GRADES ARE EXISTING FINISH GRADES CHECKED IN FIELD ON 19 BY SURVEYING AND ARE CORRECT TO THE BEST OF MY KNOWLEDGE AND BELIEF.

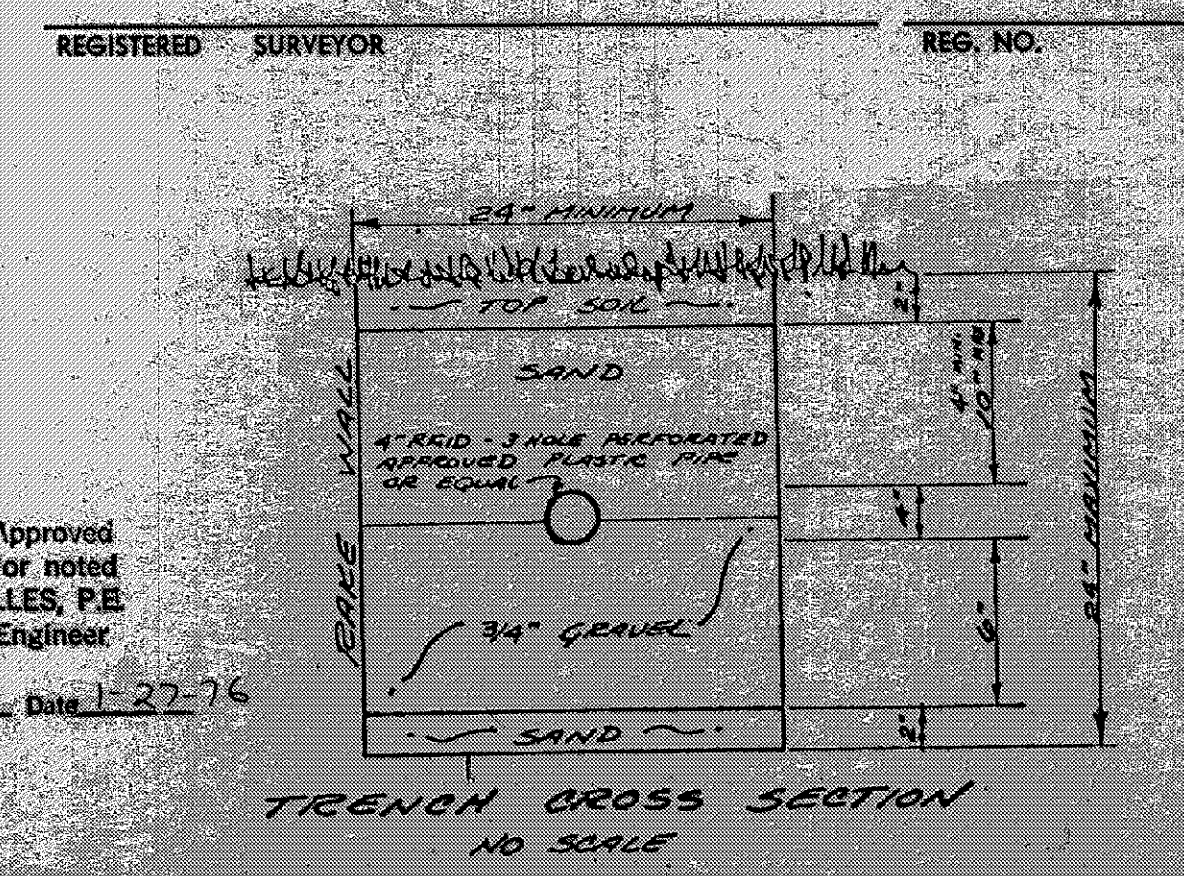

Grading Plan Approved
 as shown and/or noted
 THOMAS P. GILLES, P.E.
 Lake County Engineer

JWK Date 1-27-76