


5/107
VACANT



5/109
VACANT

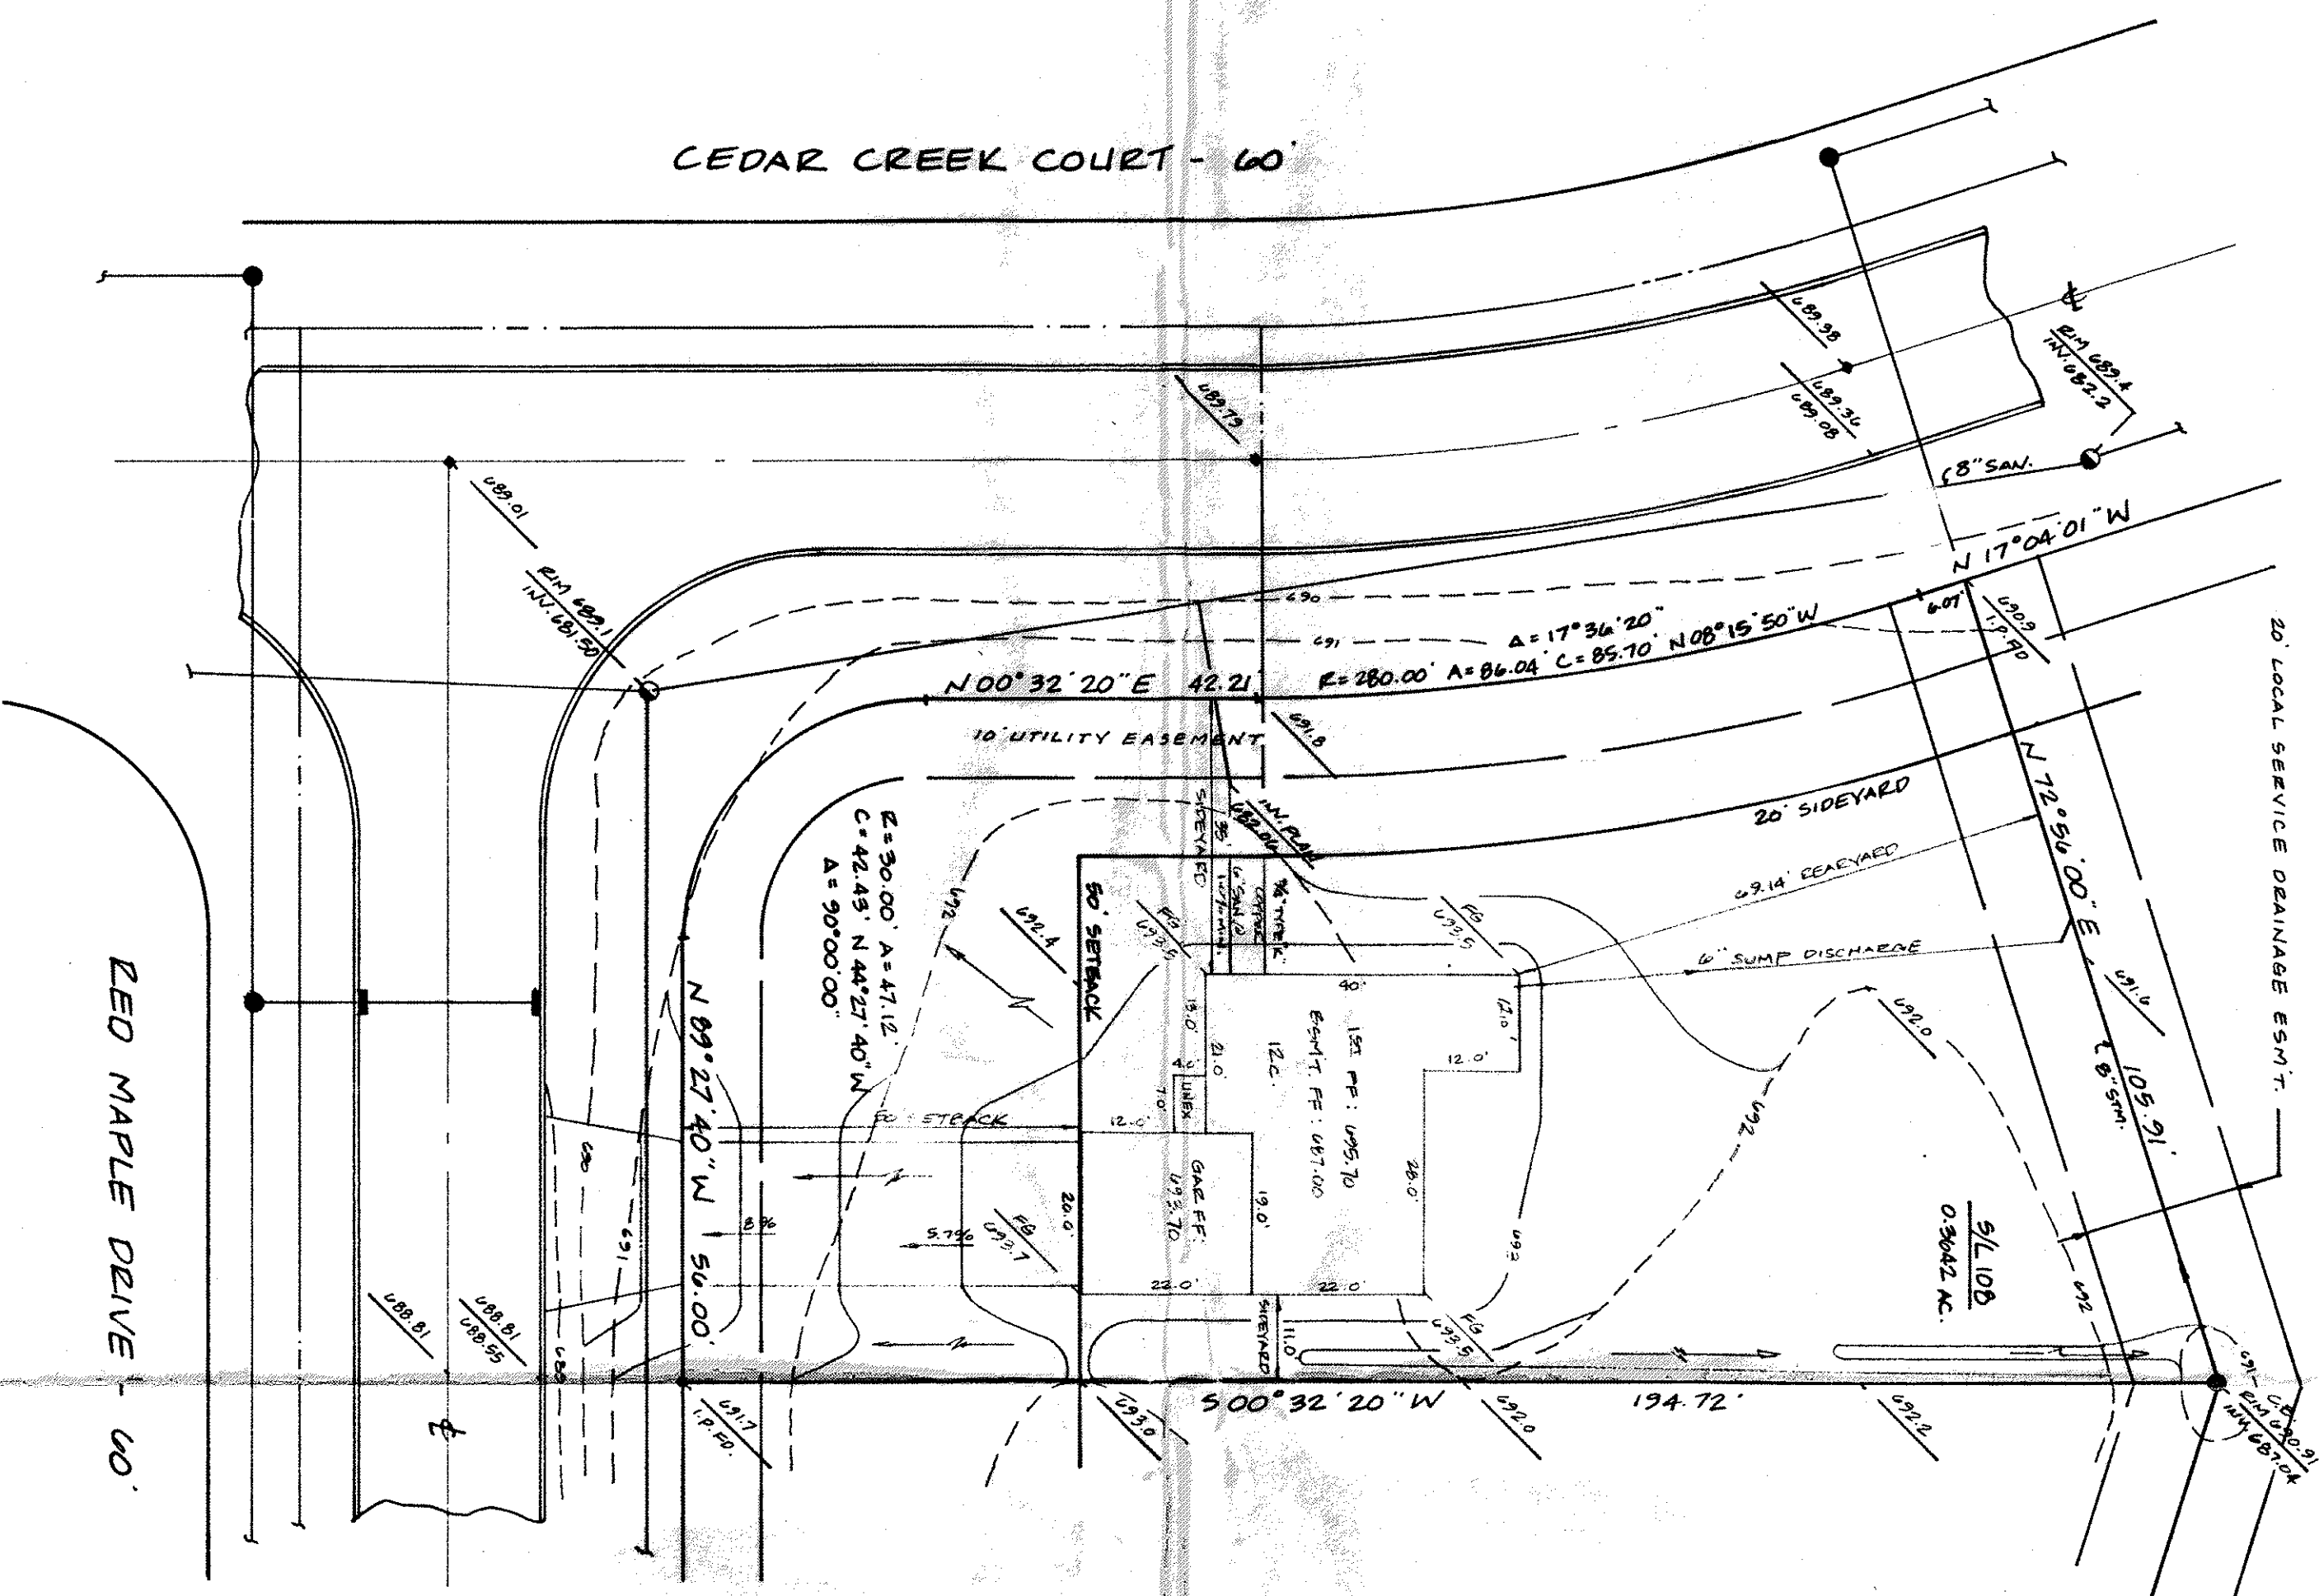

SITE PLAN

PAINESVILLE TWP., LAKE COUNTY, OHIO

for: E.L. MOORE HOMES INC.
CLIENT OWNER

1387 Red Maple Dr.
ADDRESS STREET CITY ZIP

CEDAR GLEN PHASE I
 SUBDIVISION 21-29 NAME
 100 VOL. 20
 SUBLOT NO. CEDAR MARE DR.
 STREET
 LOT
 VOLUME
 PERM. PARCEL NO.
 TRACT
 PAGE
 STREET

LEGEND

SANITARY	MANHOLE	WATER VALVE (GAS)	---
STORM	MANHOLE	WATER METER (GAS)	---
INLET OR CATCH BASIN	---	AS BUILT ELEVATION	---
HYDRANT	---	INDICATES	---
EXISTING CONTOURS	---	DIRECTION OF	---
PROPOSED CONTOURS	---	SURFACE DRAINAGE	---
EXIST. ELEV.	100.0		
	100.0		
	PROP. ELEV.		

REMARKS

ALL BOUNDARY DATA SHOWN WAS OBTAINED FROM (DEEDS, RECORDED
SUBDIVISION PLAT OR OTHER PUBLIC RECORDS)

LOCATIONS AS SHOWN OF ADJACENT WELLS AND SEPTIC TANKS OBTAINED FROM
LAKE COUNTY HEALTH DEPARTMENT

DESIGN CERTIFICATION

THIS PLAT WAS PREPARED BY ME, AND IS CORRECT
TO THE BEST OF MY KNOWLEDGE AND BELIEF

NAME	SURVEYOR	REGISTRATION	NO.

CHECK LIST

NO. OF BEDROOMS	NO. OF BATHROOMS	NO. OF DIMENSIONS	BEARINGS	TIE TO NEAREST STREET	SUBLOT NO. PARCEL NO.	SURROUNDING OWNERS	BLDG. DIMENSIONS P.W. G/L	BLDG. TIERS P.W. GRADES	APPROX. TYPE WIDTH THICKNESS	BASEMENT TYPE MASONRY CONCRESS	UNDERLYING TYPE DIA. LENGTH	ROCK OUTCROPPINGS							
WATER MAIN SIZE	LOCATION	SAN. SEWER SIZE	% GR. LOC.	SAN. MH. CAST ELEV.	INV. ELEV.	SAN. CONN. SIZE	LOC. DEPTH	STORM SEWER SIZE	% GR. LOC.	STORM MH. CAST ELEV.	INV. ELEV.	PAVT. TYPE GRADE CURBS	GAS LINE LOC.	SIZE	PRESSURE	SEPTIC TANK LOCATION	DUPLICATION AREA	WELL LOCATION	ISOLATION RADIIUS FROM WELL

PLAN PREPARED BY:

BABCOCK • JONES & ASSOCIATES, INC.

PAINESVILLE, OHIO

CHK'D	DATE	DRAWING NO
✓	1-20	35/-181

CREW	PB	APP'D.	145
92-078-102			

CHIEF	DD		
-------	----	--	--

"AS BUILT" CERTIFICATION

I, HEREBY CERTIFY THAT THE CIRCLED GRADES ARE EXISTING
FINISH GRADES CHECKED IN THE FIELD ON _____, 19____,
AND ARE CORRECT TO THE BEST OF MY KNOWLEDGE AND BELIEF.

REGISTERED SURVEYOR

REG. NO.

BENCHMARK: 4-4 RED MAPLE DR. & CEDAR CREEK CT

ELEV. = 689.01

COSTING PLAN Approved
 CROWN ENDOR/JOLES
 THOMAS P. GILES, INC.
 Local County Engineer
 6JH 000 172985
 By _____
 POWER EGS to 673-0

ROOF DRAINS
SHALL DISCHARGE
TO SPLASH BLOCKS.

APPROVED
PAINESVILLE TOWNSHIP
ZONING DEPARTMENT
9-27-10 *[Signature]*