

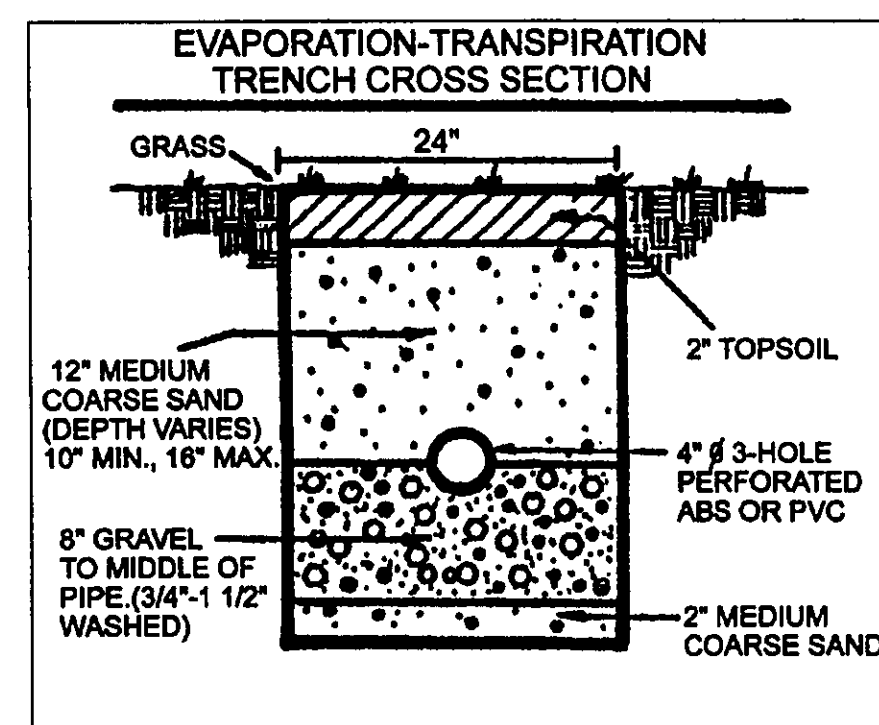


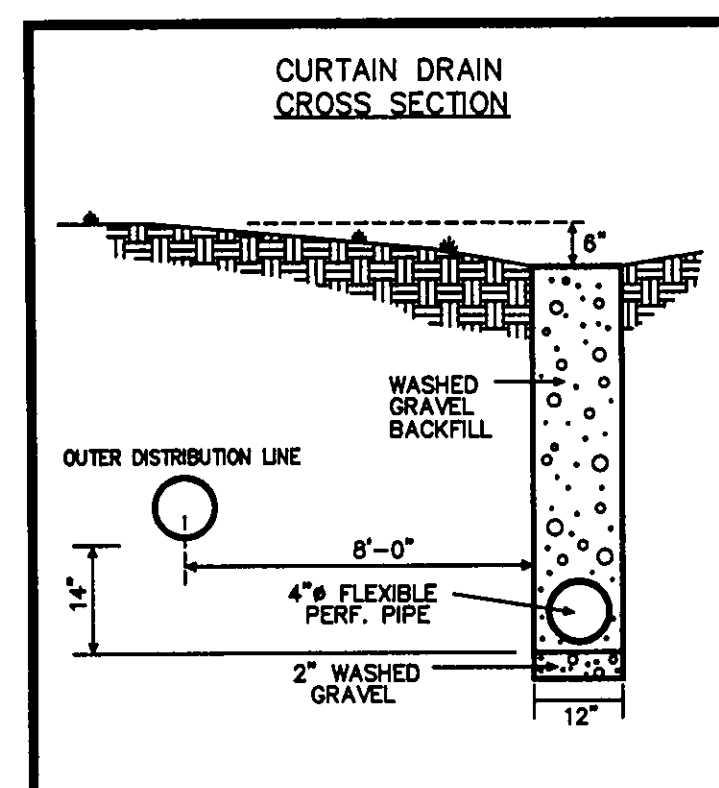

REVIEWED AND ACCEPTED
LAKE COUNTY GENERAL
HEALTH DISTRICT

Date: 5-7-99
By: David B. Norris

SEWAGE DISPOSAL PERMIT MUST BE
OBTAINED BY A LAKE COUNTY LICENSED
INSTALLER BEFORE INSTALLATION IS
STARTED.

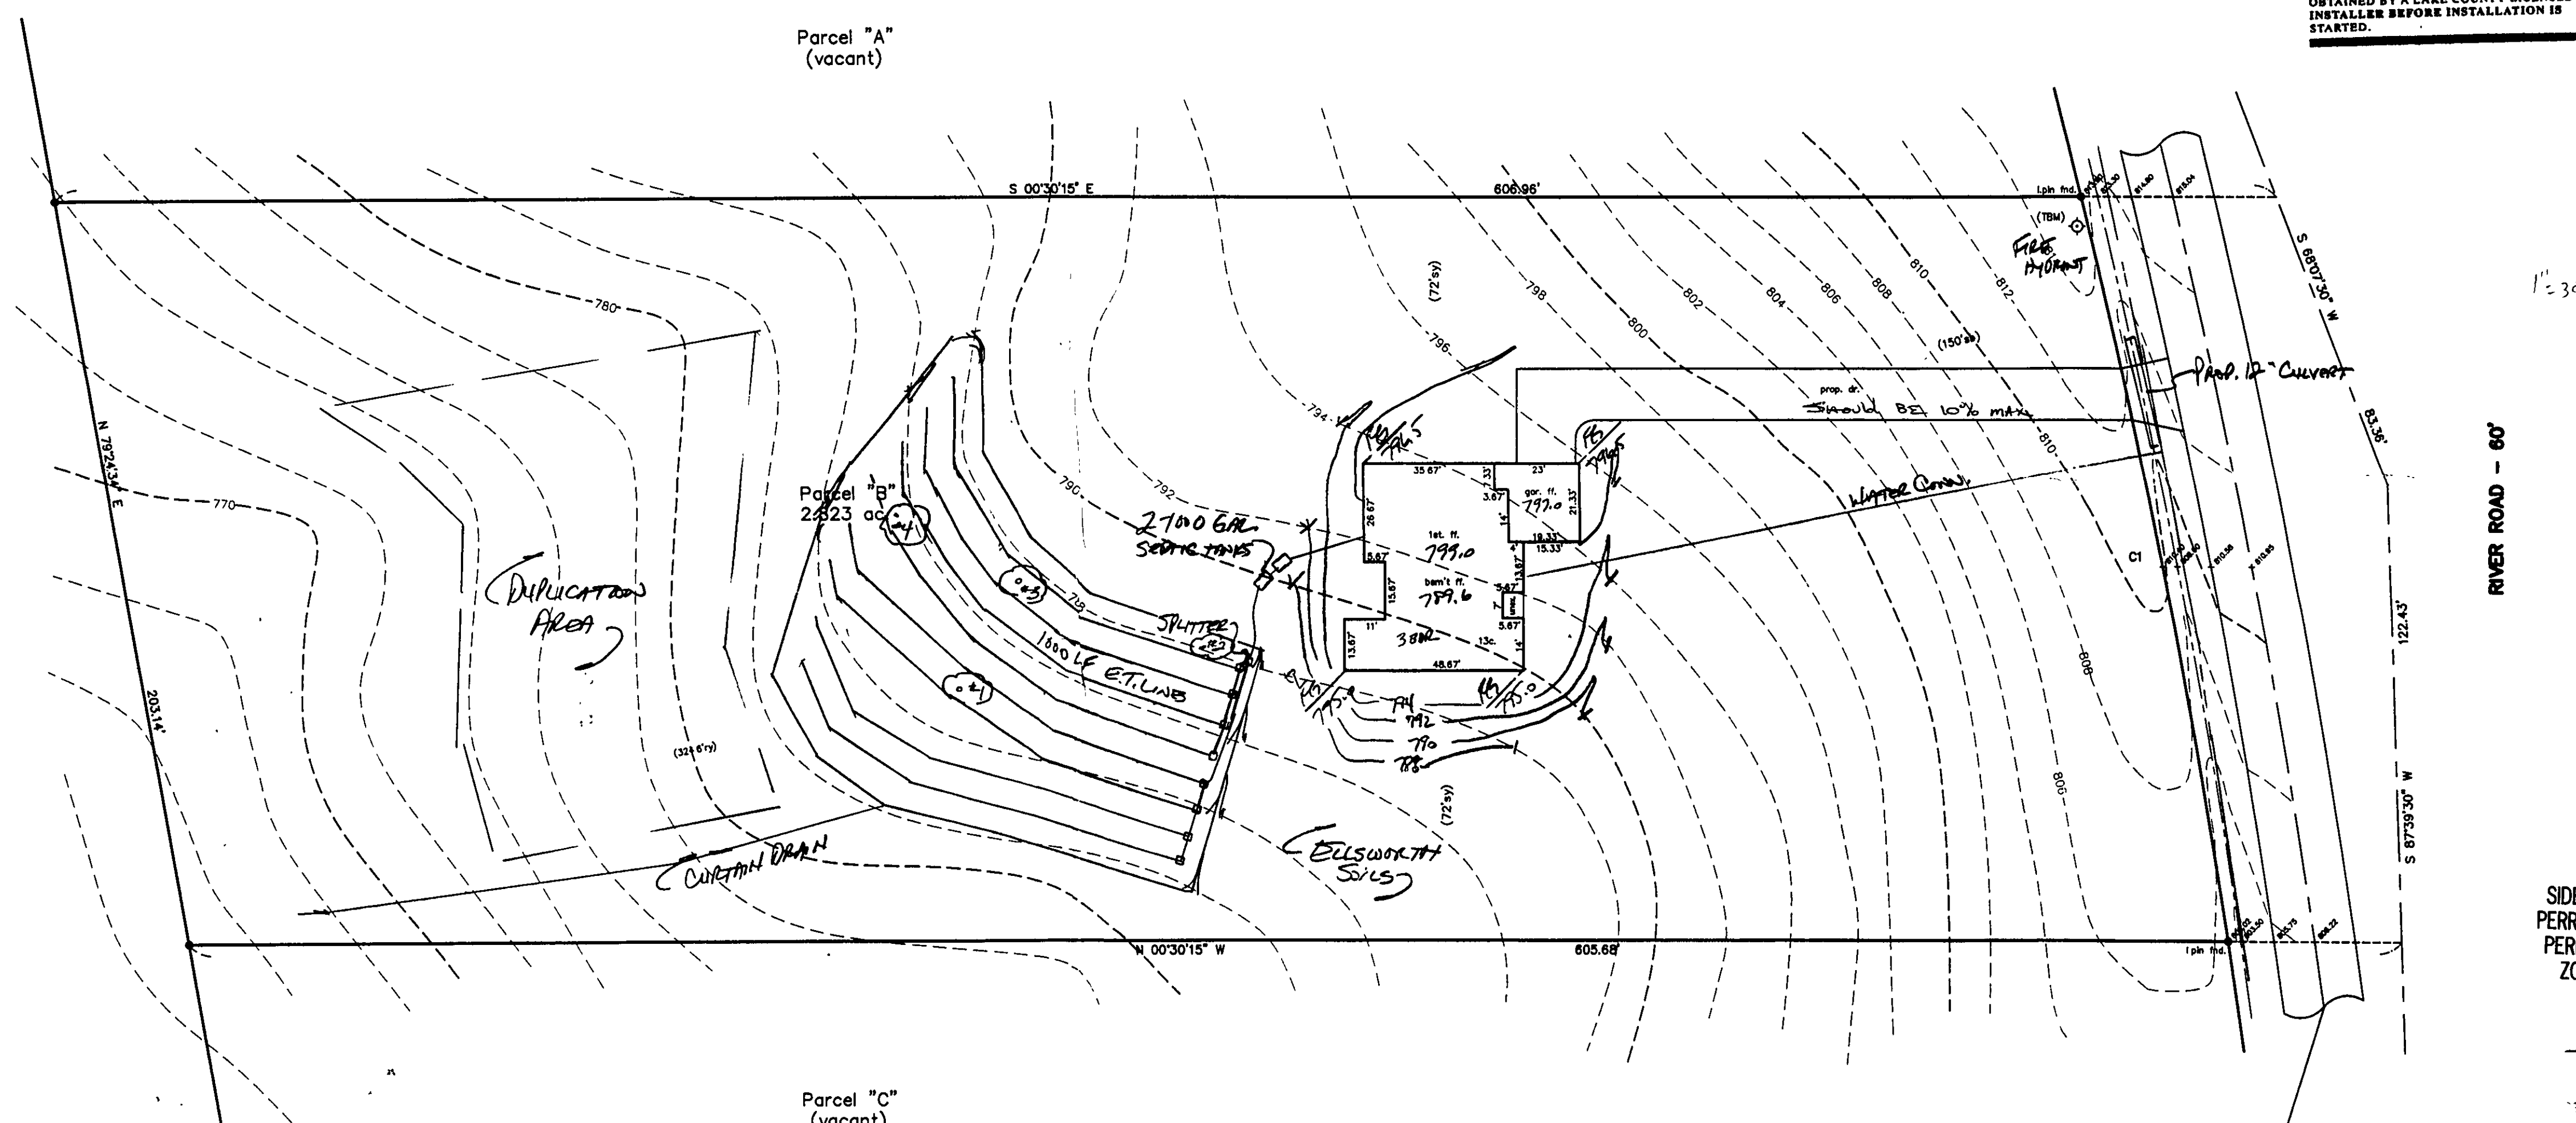



APPROVED
SIDE LINES & SET BACK
PERRY TOWNSHIP ZONING
PERMIT NO. 687
ZONING INSPECTOR

County Engineer
AS P. GILLES
THOMAS P. GILLES, P.E.
Lake County Engineer

Grading Plan Approved
as shown and/or noted
THOMAS P. GILLES, P.E.
Lake County Engineer

By: [Signature] Date: 5/11/99
SEWER SHOULD BE 10% MAX. GRADE

C1: R=2323.81'
L=204.08'
C=204.01'
N78°07'03"E

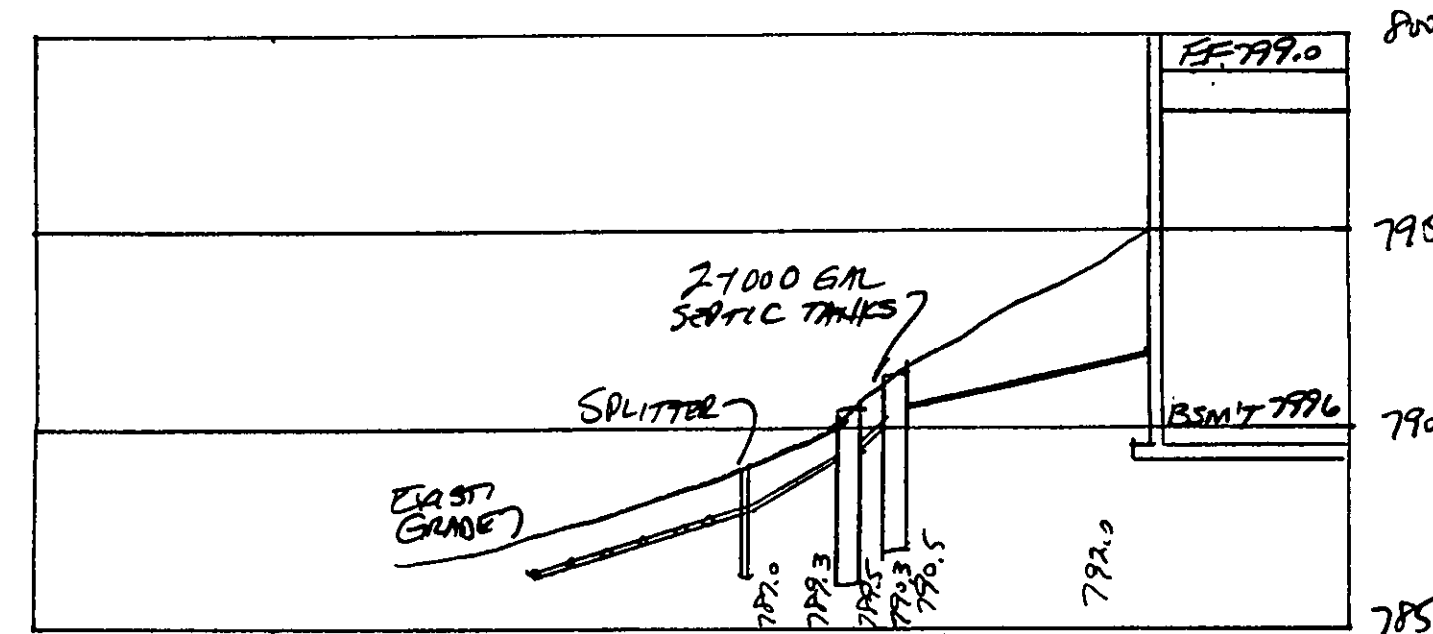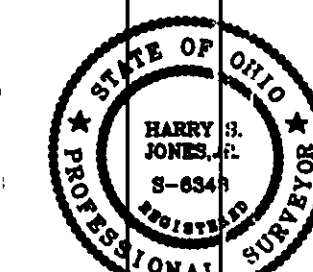

"I, the undersigned hereby certify that this topography indicated by 6", 1", or 2" contours, and elevations shown hereon represent an actual field survey made by me on the 25th day of March, 1999 and that the elevations were taken at appropriate intervals and that as of that date they existed as indicated hereon."

Harry Jones #6343
Name Reg. No.

TBM-TOP OF HYDRANT
ELEV.=816.28

REV. NO.	DESCRIPTION	DATE	BY	CHK'D
1	Revised Sewer	5/6/99	HJ	HJ

babcock BABCOCK, JONES AND ASSOCIATES, INC
CIVIL ENGINEERS - SURVEYORS - LAND PLANNERS
PAINESVILLE OHIO 44077

DATE	3/24/99
DESIGN BY	H.J.
DRAWN BY	T.R.
APPROVED BY	H.J.

SITE PLAN
FOR
NAUGHTON BUILDERS
HIP LAKE COUNTY

SCALE	1"=30'
JOB NO.	99-061-B
SHEET	1 OF 1