


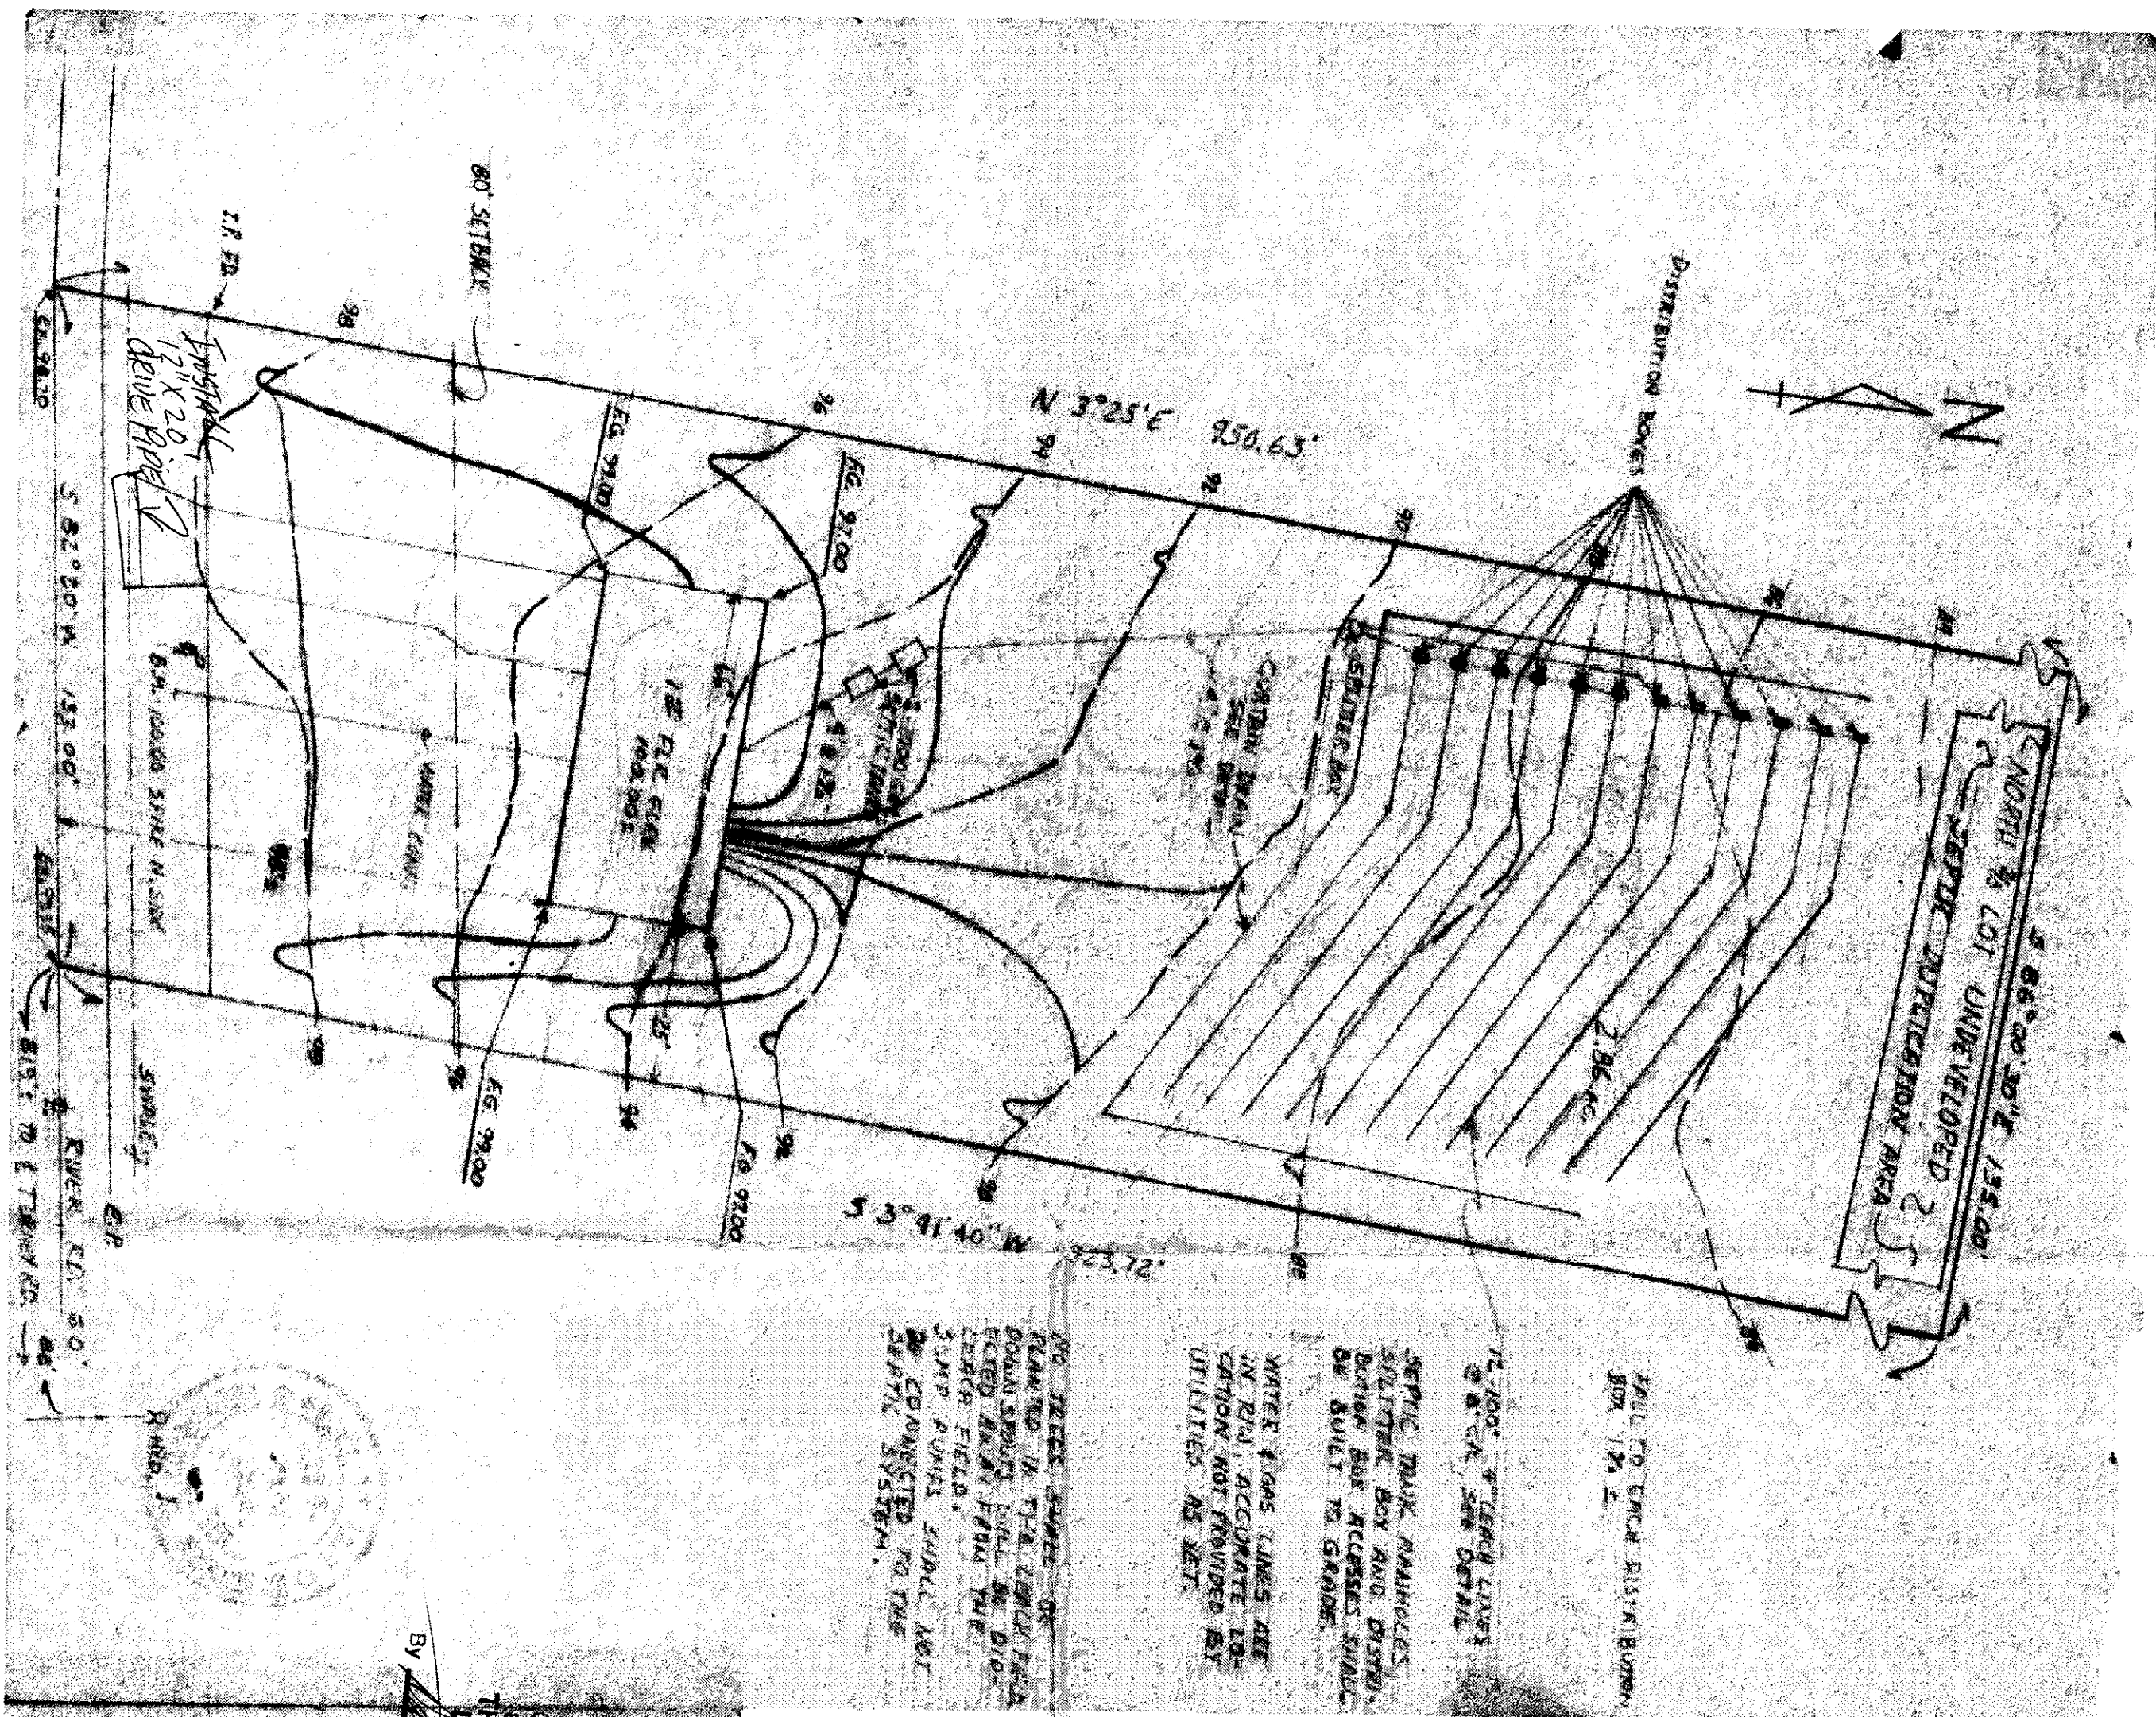

WALL TO CURB DISTANCE BOX 12' L.


12' R.C. CURB SEE DETAIL

SEPTIC TANK MANHOLES, SPLITTER BOX AND DISTRIBUTION BOX ACCESS SHALL BE BUILT TO GRADE.

WATER & GAS LINES ARE IN R/W, ACCURATE LOCATION NOT PROVIDED BY UTILITIES AS YET.

NO TREES, SHRUBS OR PLANTS IN THE LENGTH OF DOWN SPOUT SHALL BE LOCATED WITHIN FIELD THE 30' RADIUS SHALL NOT BE CONNECTED TO THE SEPTIC SYSTEM.

TRENCH DETAIL

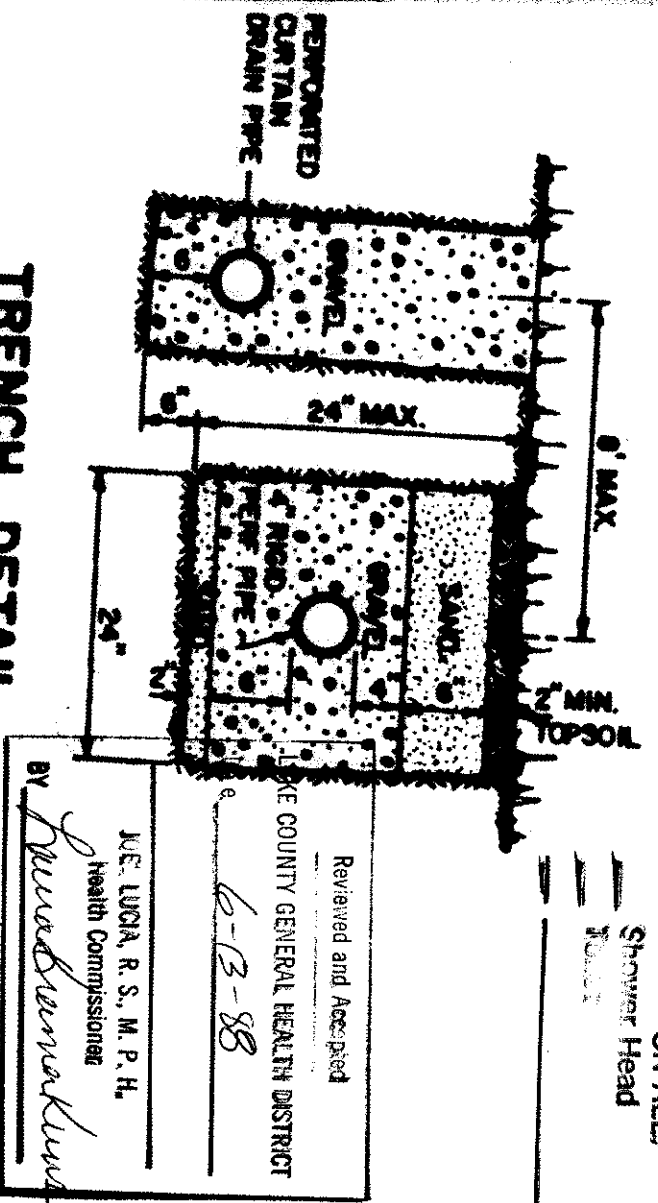

SEWAGE DISPOSAL PERMITS OBTAINED BY A LAKE COUNTY INSTALLER BEFORE INSTALLATION STARTED.

LOW YIELD WATER FIXTURES REQUIRED ON ALL

Reviewed and Accepted
LAKE COUNTY GENERAL HEALTH DISTRICT
6-13-88
J.E. LUCA, R.S., M.P.H.
Health Commissioner
BY: *Quadenklu*

- A. To be brought to finished grade
 1. Septic tank manhole covers
 2. Splitter box cover
 3. Distribution box cover
- B. No footer drains or overflows to be discharged into septic tanks
- C. All waste water to be discharged into septic tanks

SITE PLAN
FOR
JAMES & LYNN MAES
PERM. PARCEL 3A-70-34
PERRY TWP OHIO
DATE MAY, 1988
SCALE 1"=30'

Grading Plan Approved as shown and/or noted
THOMAS P. GILLES, P.E.
Lake County Engineer
By: *David [Signature]* Date 6/1/88

SEPTIC SYSTEM REVISIONS: JUNE 6, 1988

[Signature] P.E. 6/13/88
D-35060 Ned J. Foley

APPROVED
SIDE LINES & SET BACK
PERRY TOWNSHIP ZONING
PERMIT NO. 4743
ZONING INSPECTOR
Alan King