


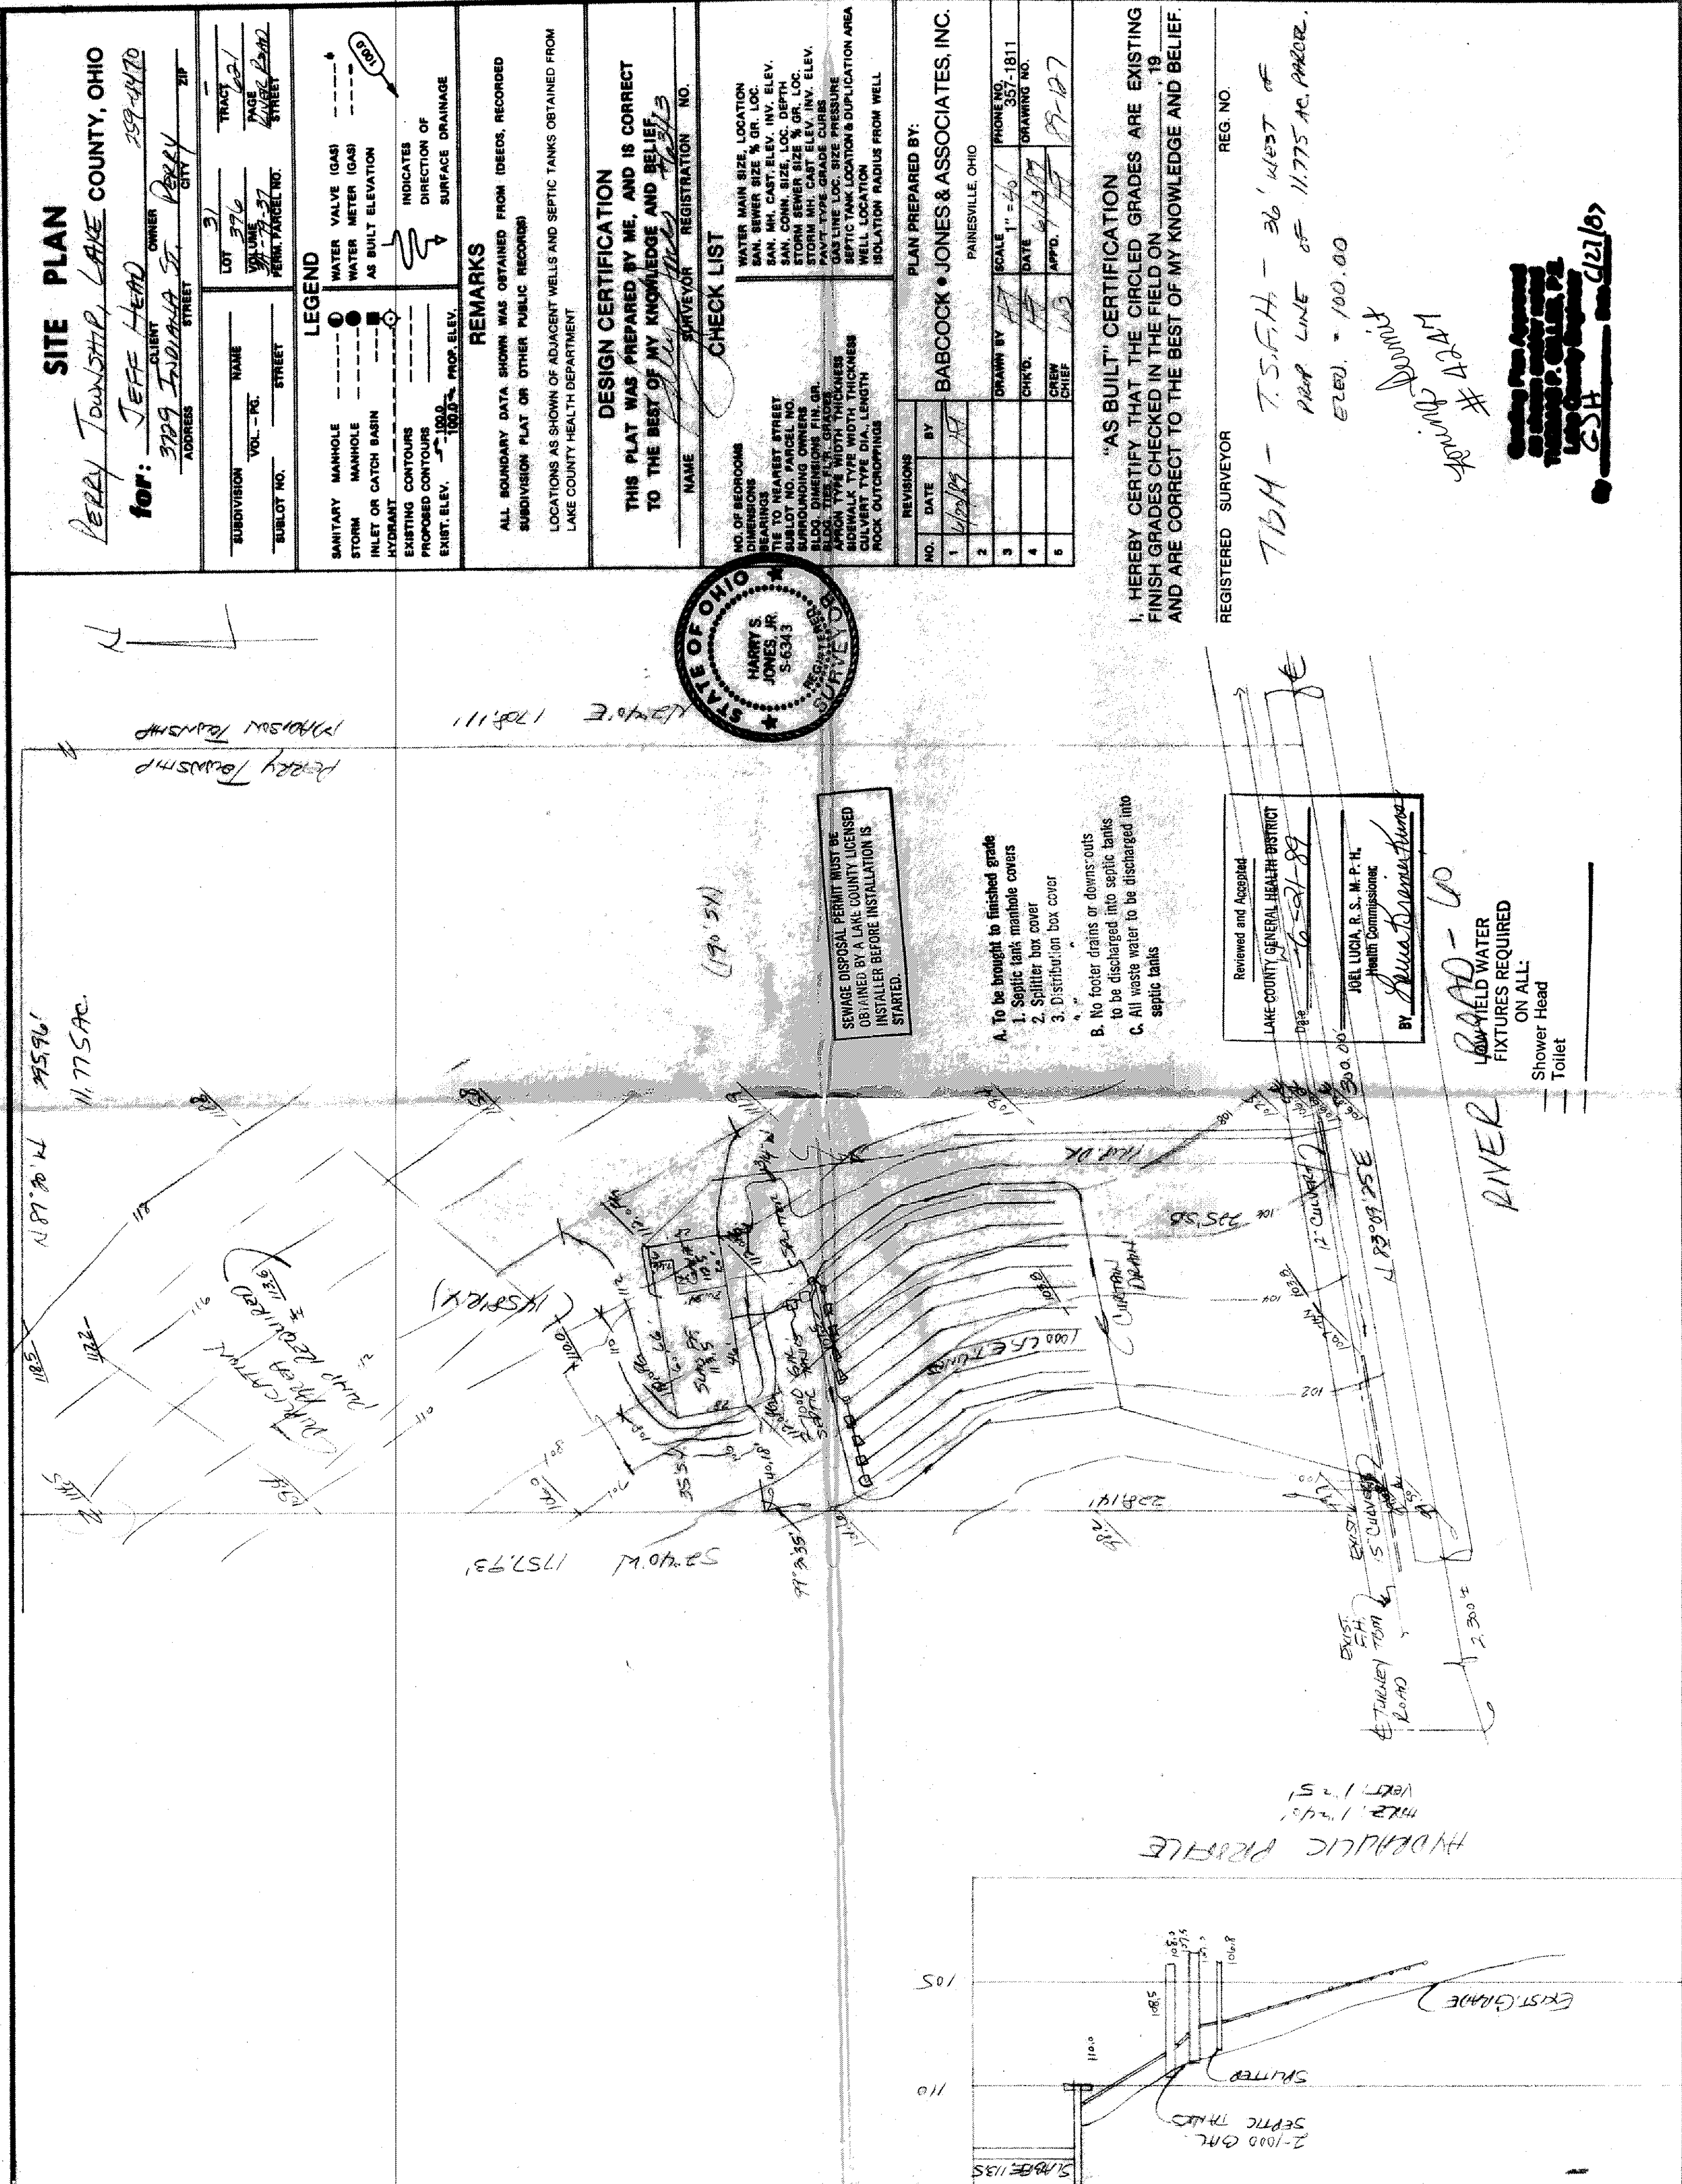

SITE PLAN

for: **JEFF HEAD**
OWNER
3799 INDIANA ST. PERRY
ADDRESS CITY ZIP

SUBDIVISION	NAME	LOT	TRACT
VOL. - PG.	STREET	376	221
SUBLOT NO.		VOLUME	PAGE
		44-19-37	1000000000
		PERM. PARCEL NO.	STREET

LEGEND

SANITARY MANHOLE	WATER VALVE (GAS)
STORM MANHOLE	WATER METER (GAS)
INLET OR CATCH BASIN	AS BUILT ELEVATION
HYDRANT	INDICATES DIRECTION OF SURFACE DRAINAGE
EXISTING CONTOURS	
PROPOSED CONTOURS	
EXIST. ELEV. -100.0	
PROP. ELEV. -100.0	

REMARKS

ALL BOUNDARY DATA SHOWN WAS OBTAINED FROM IDEEDS, RECORDED SUBDIVISION PLAT OR OTHER PUBLIC RECORDS

LOCATIONS AS SHOWN OF ADJACENT WELLS AND SEPTIC TANKS OBTAINED FROM LAKE COUNTY HEALTH DEPARTMENT

DESIGN CERTIFICATION

THIS PLAT WAS PREPARED BY ME, AND IS CORRECT TO THE BEST OF MY KNOWLEDGE AND BELIEF

NAME: **Harry S. Jones, Jr.** SURVEYOR REGISTRATION NO. **5-6343**

CHECK LIST

NO. OF BEDROOMS	WATER MAIN SIZE, LOCATION
DIMENSIONS	SAN. SEWER SIZE, % GR. LOC.
BEARINGS	SAN. MH. CAST. ELEV. INV. ELEV.
TIE TO NEAREST STREET	SAN. CONN. SIZE, LOC. DEPTH
SUBLOT NO. PARCEL NO.	STORM SEWER SIZE, % GR. LOC.
SURROUNDING OWNERS	STORM MH. CAST. ELEV. INV. ELEV.
BLDG. DIMENSIONS FIN. GR.	PAV'T. TYPE GRADE CURBS
BLDG. TIE, ELEV. GRADES	SEPTIC TANK LOCATION & DUPLICATION AREA
APPROX. TYPE WIDTH THICKNESS	WELL LOCATION
SIDEWALK TYPE DIA. LENGTH	ISOLATION RADIUS FROM WELL
CULVERT TYPE DIA. LENGTH	
ROCK OUTCROPPINGS	

PLAN PREPARED BY:

BABCOCK & JONES & ASSOCIATES, INC.
PAINESVILLE, OHIO

NO.	DATE	BY
1	4/20/89	HT
2		
3		
4		
5		

DRAWN BY: **HT** SCALE: **1" = 40'** PHONE NO. **357-1811**

CHK'D: **HT** DATE: **4/23/89** DRAWING NO.

APP'D: **HT** CREW CHIEF: **103** 89-127

"AS BUILT" CERTIFICATION


I, HEREBY CERTIFY THAT THE CIRCLED GRADES ARE EXISTING FINISH GRADES CHECKED IN THE FIELD ON **19** AND ARE CORRECT TO THE BEST OF MY KNOWLEDGE AND BELIEF.

REGISTERED SURVEYOR REG. NO.

TBM - T.S.F.H. - 36' WEST OF
PROP. LINE OF 11.775 AC. PARCE.
ELEV. - 100.00

Demond
Young #4247

Sealing Plan Approved
as shown water main
11.775 AC. PARCE.
LAKE COUNTY ENGINEER
12/21/87

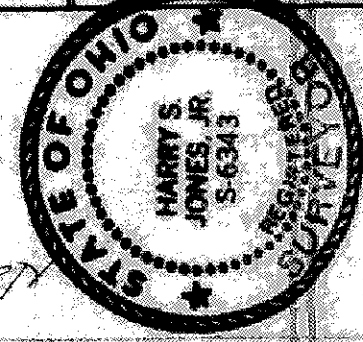

SEWAGE DISPOSAL PERMIT MUST BE OBTAINED BY A LAKE COUNTY LICENSED INSTALLER BEFORE INSTALLATION IS STARTED.

- A. To be brought to finished grade**
1. Septic tank manhole covers
 2. Splitter box cover
 3. Distribution box cover
- B. No footer drains or downspouts to be discharged into septic tanks**
- C. All waste water to be discharged into septic tanks**

Reviewed and Accepted

LAKE COUNTY GENERAL HEALTH DISTRICT

Date: **6-24-89**

JOEL LUCIA, R. S. M. P. H.
Health Commissioner

BY: *Joel Lucia*

RIVER ROAD - 60

LOW FIELD WATER

FIXTURES REQUIRED

ON ALL:

- Shower Head
- Toilet

