


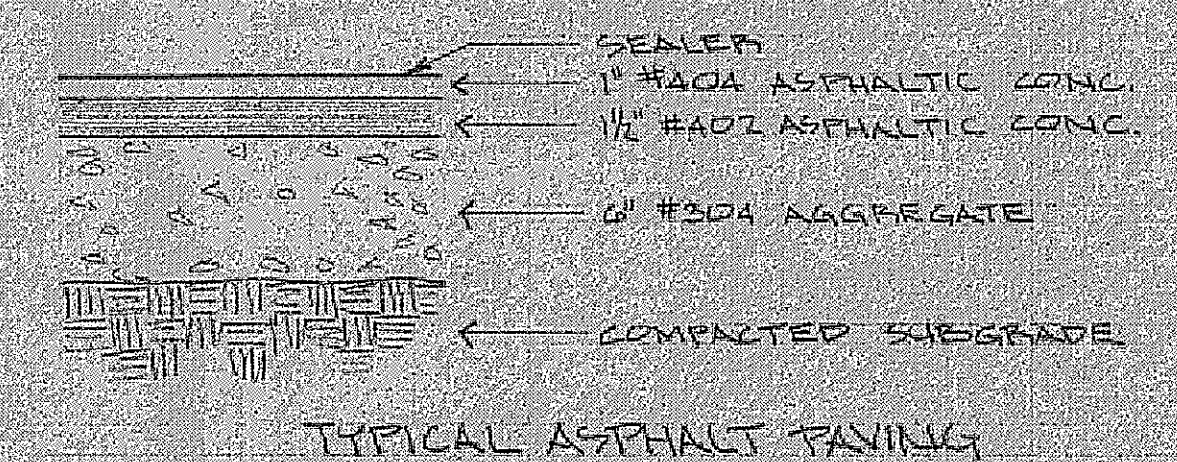



CODE CLASSIFICATION
USE GROUP D - BUSINESS
CONSTRUCTION - TYPE A-B UNPROTECTED
ALLOWABLE AREA - 7100 SQ. FT. (TABULAR)
ACTUAL AREA - 3024 SQ. FT.

INDEX OF DRAWINGS	
DWG. NO.	DESCRIPTION
A-1	SITE PLAN & INDEX OF DRAWINGS
A-2	FOUNDATION PLAN & DETAILS
A-3	FLOOR PLAN
A-4	ROOF PLAN & FRAMING PLAN & DETAILS
A-5	BUILDING SECTIONS
A-6	WALL SECTIONS & DETAILS
A-7	BUILDING ELEVATIONS
A-8	ROOM FINISH, DOOR AND WINDOW SCHEDULES
M-1	MECHANICAL & PLUMBING PLAN
M-2	CATALOG, DIAGRAM, FIXTURE & EQUIP. SCHEDULES
E-1	LIGHTING & POWER PLAN
E-2	ELECTRICAL SITE PLAN, LEGEND & FIXTURE SCHEDULE
S-1	SANITARY FORCE MAIN PLAN & PROFILE
S-2	SANITARY FORCE MAIN PLAN & PROFILE

SITE PLAN

- NOTES**
- REMOVE AND STOCK PILE TOPSOIL FROM BUILDING AND DRIVE AREAS.
 - GENERAL CONTRACTOR TO ESTABLISH BUILDING LINES AND GRADES. ALL WALKS, DRIVES & PAVED AREAS SHALL BE STAKED AND APPROVED BY ARCHITECT BEFORE CONSTRUCTION.
 - SEE ARCHITECTURAL DRAWINGS FOR BUILDING DIMENSIONS. DIMENSIONS GIVEN TO OUTSIDE OF FOUNDATION WALLS UNLESS OTHERWISE NOTED.
 - REMOVE ALL EXCESS EARTH & BUILDING DEBRIS FROM SITE AFTER FINAL GRADING.
 - SPREAD TOP SOIL OVER ENTIRE AREA DISTURBED BY CONSTRUCTION.
 - FINAL GRADING TO BE PERFORMED SO THAT ALL SURFACE WATER DRAINS AWAY FROM BUILDING AREA.

BENCH MARK AT INTERSECTION OF SHEPARD RD. AND ACCESS DRIVE - 696.9

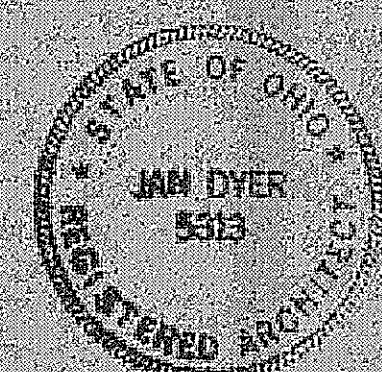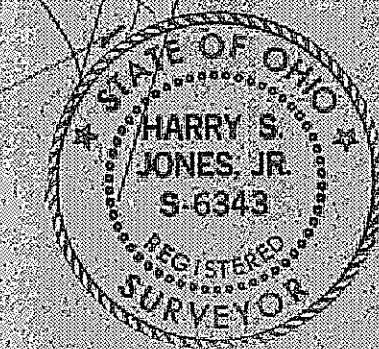

8430 MENTOR AVE.
MENTOR, OHIO

SQUARED CHANGE HOUSE & OFFICES
PERRY, OHIO
SCALE: 1"=50'
DATE: MARCH 01
APPROVED BY: [Signature]
DRAWN BY: JEFF WICK, P.E.
CALHUN CHEMICALS, INC.
PERRY, OHIO
SITE PLAN
DRAWING NUMBER OF: A-1.2

APPROVED
SIDE LINES & SET BACK
PERRY TOWNSHIP ZONING
PERMIT NO. 2465
ZONING INSPECTOR
[Signature]

Grading Plan Approved
as shown and/or noted
THOMAS P. GILLES, P.E.
Lake County Engineer
By: [Signature] Date: 4/16/11

PLAT LOCATION
LOT 21 PERRY TWP.
LAKE COUNTY, OHIO