


# TYPICAL LEACHING TRENCH CROSS SECTION

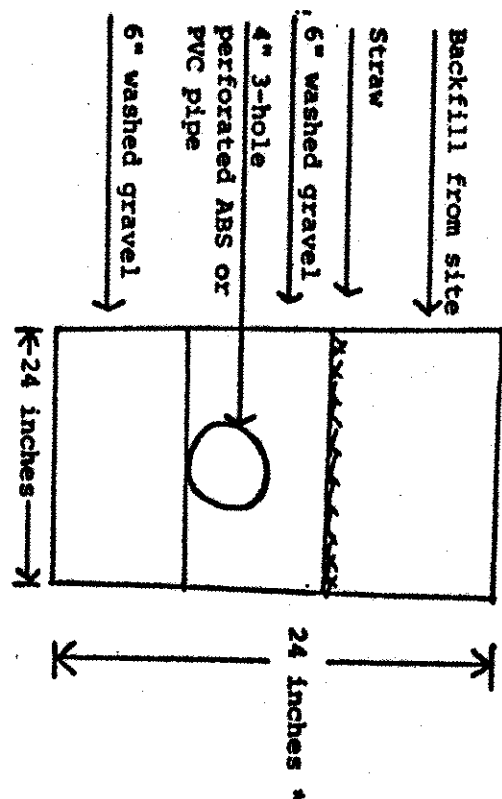

\* The standard leaching trench is 24 inches deep, however the trench can vary between 18 to 30 inches deep if necessary. Gravel require is standard - amount of backfill would vary.

- A. To be brought to finished grade**
1. Septic tank manhole covers
  2. Splitter box cover
  3. Distribution box cover
- B. No footer drains or downspouts to be discharged into septic tanks**
- C. All waste water to be discharged into septic tanks**

SEWAGE DISPOSAL PERMIT MUST BE OBTAINED BY A LAKE COUNTY LICENSED SURVEYOR BEFORE INSTALLATION IS STARTED.



Reviewed and Accepted  
 LAKE COUNTY GENERAL HEALTH DISTRICT  
 Date 10-5-93  
 JOEL LUCIA, R.S., M.P.H.  
 Health Commissioner  
 BY Don Lindsey

NO.	DATE	BY	REVISIONS
1	10-1-93	JB	
2			
3			
4			
5			


PLAN PREPARED BY:  
 BABCOCK • JONES & ASSOCIATES, INC.  
 PAINESVILLE, OHIO  
 DRAWN BY: SCALE: 1" = 30'  
 CHK'D: DATE: 9-24-93  
 CREW: KJ APP'D: 93-159

"AS BUILT" CERTIFICATION  
 I, HEREBY CERTIFY THAT THE CIRCLED GRADES ARE EXISTING FINISH GRADES CHECKED IN THE FIELD ON 19 19 19 AND ARE CORRECT TO THE BEST OF MY KNOWLEDGE AND BELIEF.

REGISTERED SURVEYOR REG. NO. 10493

TEMP. BENCHMARK: TOP OF HYDRAUNT 94.3

LOW YIELD WATER FIXTURES REQUIRED ON ALL:  
 Shower Head  
 Toilet

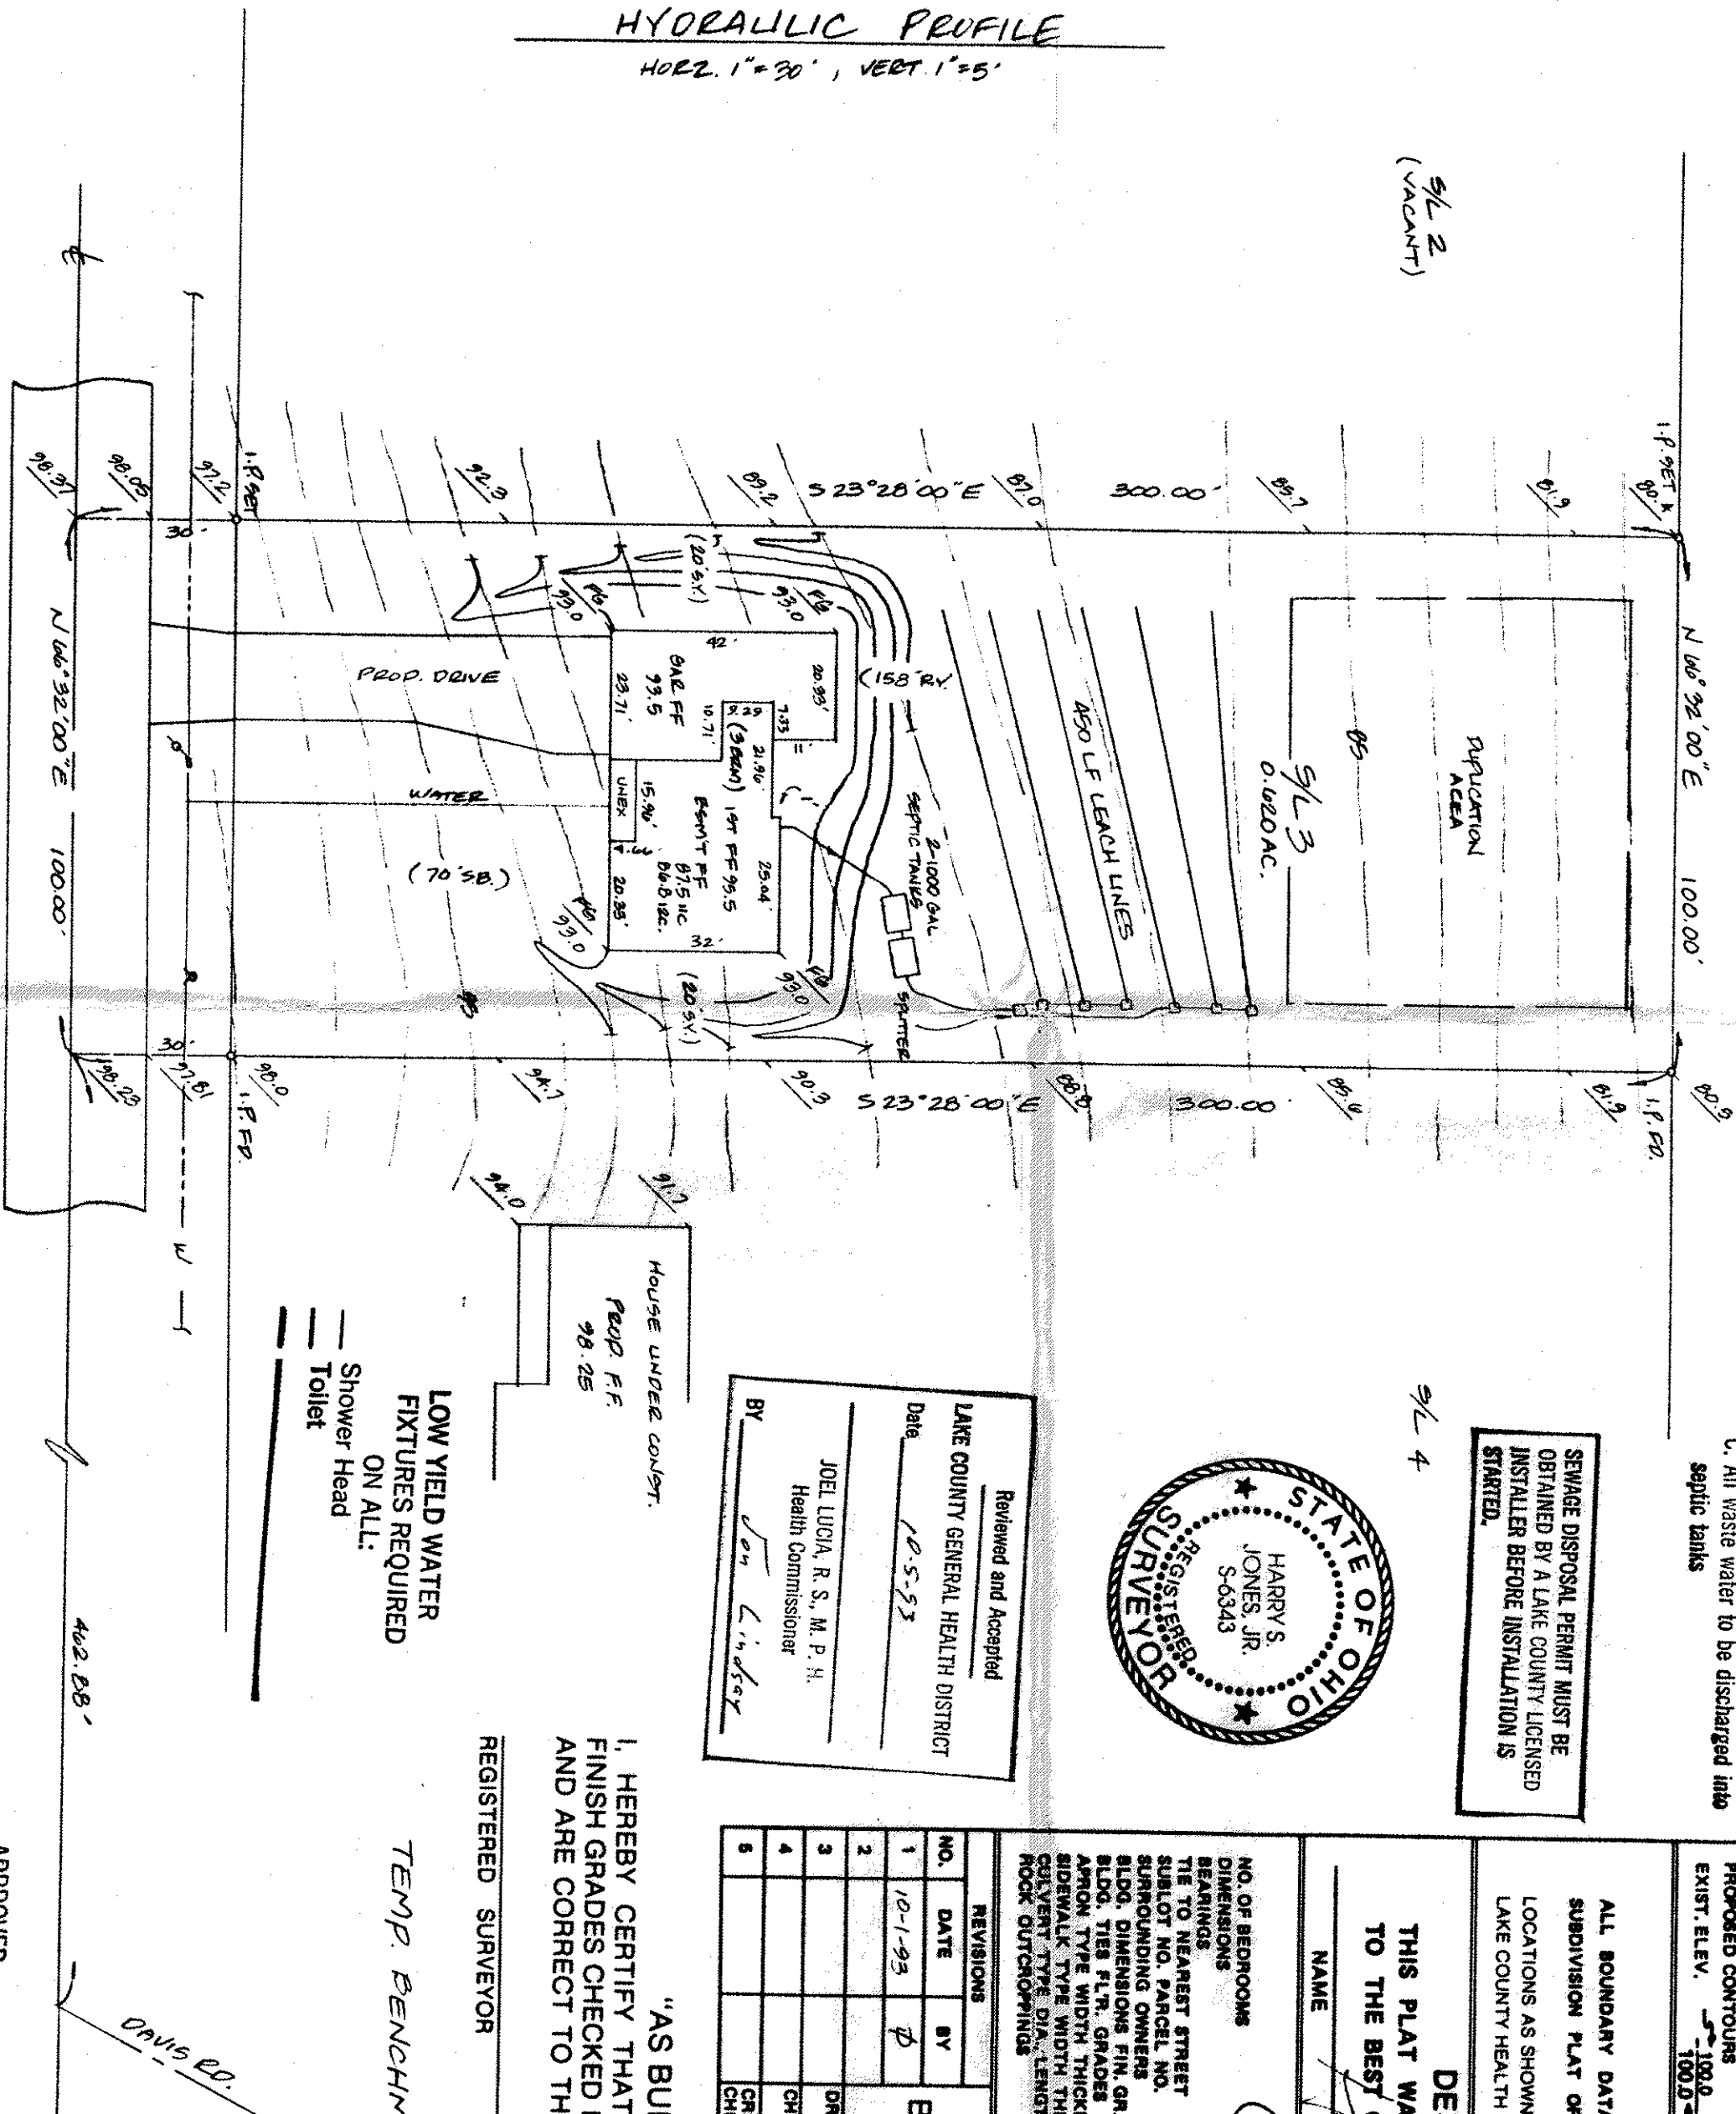

SOUTH RIDGE ROAD - 60

APPROVED  
 SIDE LINES & SET BACK  
 PERRY TOWNSHIP ZONING  
 PERMIT NO. 4718  
 ZONING INSPECTOR

## SITE PLAN

PERRY TWP., LAKE COUNTY, OHIO

for: THOMAS SNELL 639-2006

CLIENT: 78 LEE RD. PAINESVILLE OH 44077

SUBDIVISION	NAME	LOT	TRACT
3	VOL. 80		
SUBLOT NO.	2		
STREET	STREET		

SANITARY MANHOLE	WATER VALVE (GAS)
STORM MANHOLE	WATER METER (GAS)
INLET OR CATCH BASIN	AS BUILT ELEVATION
HYDRANT	INDICATES DIRECTION OF SURFACE DRAINAGE
EXISTING CONTOURS	
PROPOSED CONTOURS	
EXIST. ELEV.	100.0
PROP. ELEV.	100.0

REMARKS  
 ALL BOUNDARY DATA SHOWN WAS OBTAINED FROM (DEEDS, RECORDED SUBDIVISION PLAT OR OTHER PUBLIC RECORDS)  
 LOCATIONS AS SHOWN OF ADJACENT WELLS AND SEPTIC TANKS OBTAINED FROM LAKE COUNTY HEALTH DEPARTMENT

DESIGN CERTIFICATION  
 THIS PLAT WAS PREPARED BY ME, AND IS CORRECT TO THE BEST OF MY KNOWLEDGE AND BELIEF.  
 NAME: SURVEYOR REGISTRATION NO. 10303

### CHECK LIST

NO. OF BEDROOMS	WATER MAIN SIZE, LOCATION
	SEWER SIZE & GR. LOC.
	SAN. INH. CAST. ELEV. INV. ELEV.
	SAN. CONN. SIZE, LOC. DEPTH
	STORM INH. CAST. ELEV. INV. ELEV.
	STORM CONN. SIZE, LOC. DEPTH
	PAYT TYPE GRADE CURVES
	GAS LINE LOC. SIZE PRESSURE
	SEPTIC TANK LOCATION & DIMENSIONS
	WELL LOCATION
	ISOLATION RADIUS FROM WELL

"I, the undersigned hereby certify that this topography indicated by 5', 1' or 2' contours, and elevations shown hereon represent an actual field survey made by me on the 28th day of SEPT., 1993 and that the elevations were taken at appropriate intervals and that as of that date they existed as indicated hereon."

By: THOMAS P. GILLES, P.E.  
 Lake County Engineer  
 Date: 10-14-93