

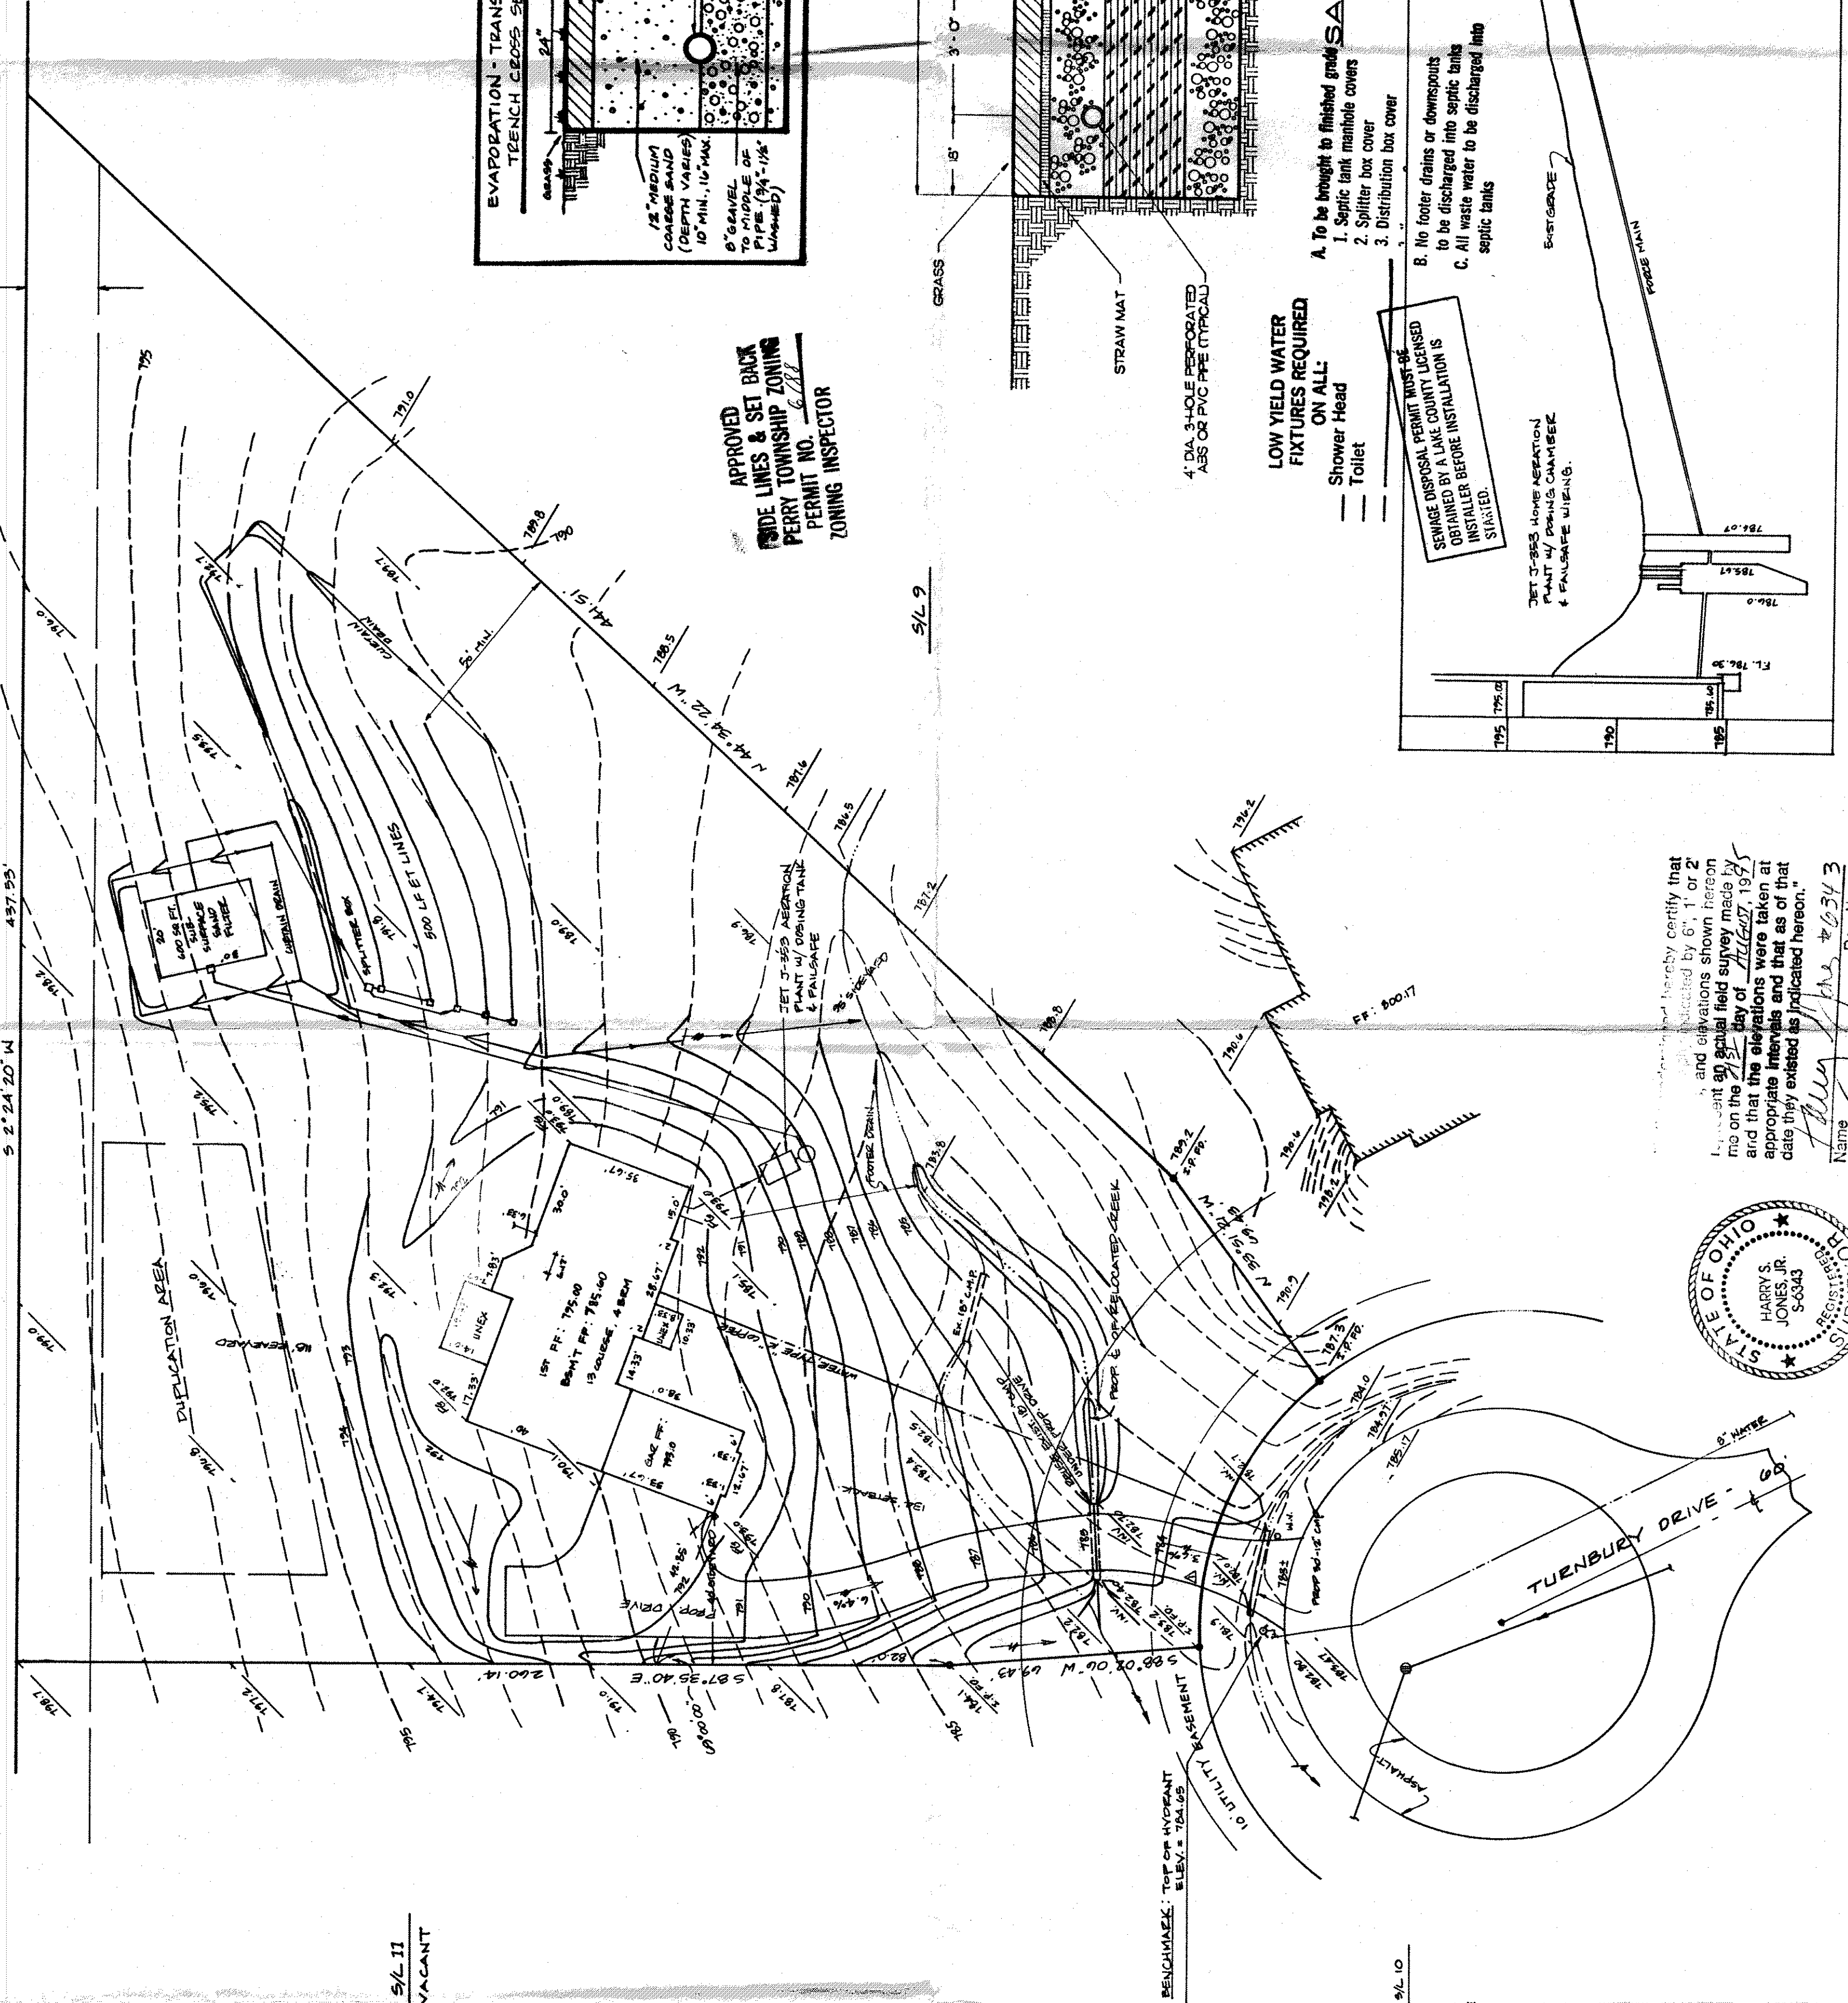



20' GASLINE EASEMENT

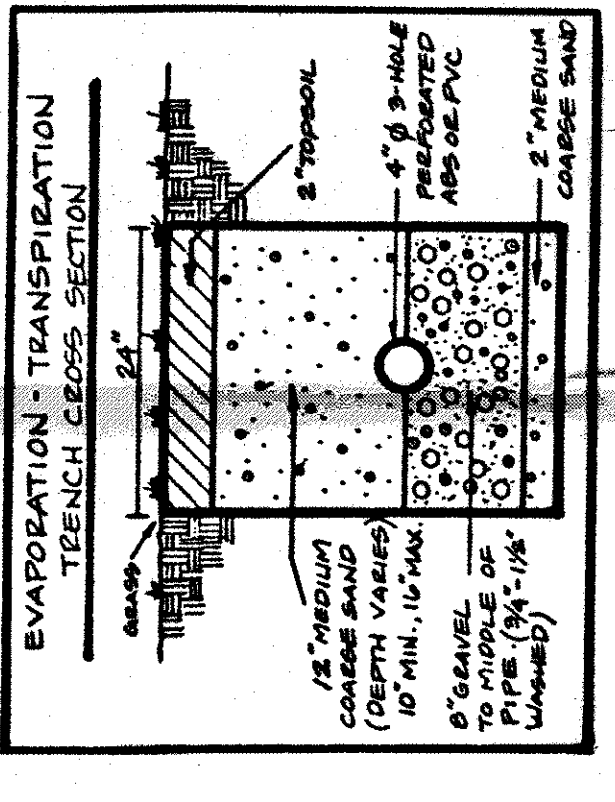

System is in accordance with overall on-site sewage disposal system plan.
System is different than shown on overall on-site sewage disposal system plan.

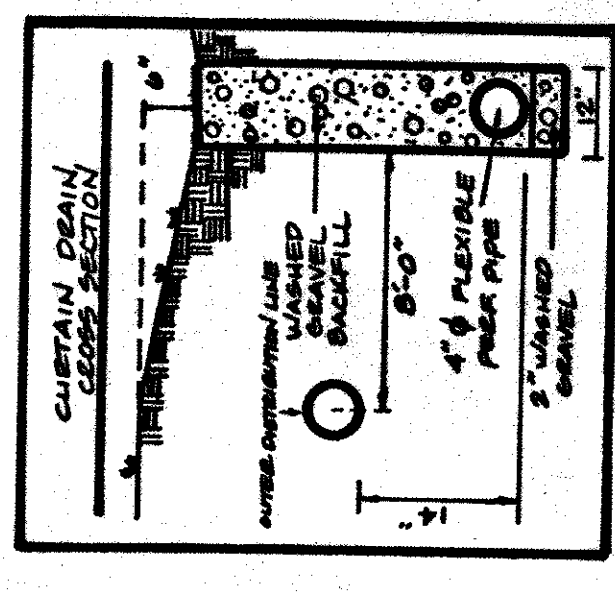


APPROVED
CODE LINES & SET BACK
PERY TOWNSHIP ZONING
PERMIT NO. 6-117
ZONING INSPECTOR

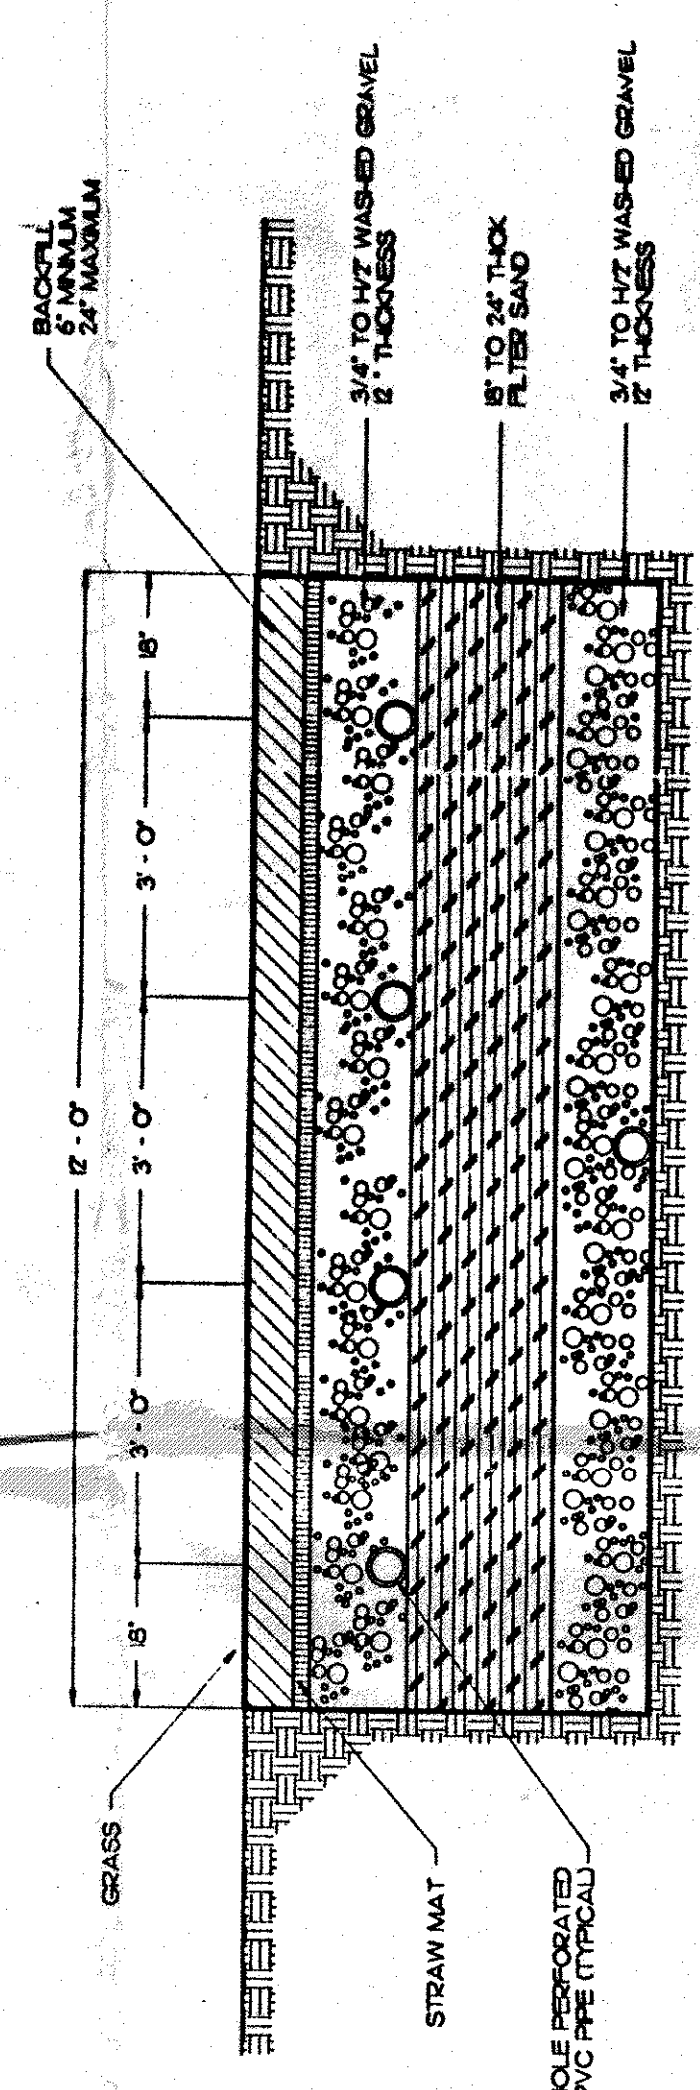

LOW YIELD WATER
FIXTURES REQUIRED
ON ALL:
Shower Head
Toilet

SEWER DISPOSAL PERMIT MUST BE
OBTAINED BY A LAND COUNTY LICENSED
INSTALLER BEFORE INSTALLATION IS
STARTED.

A. To be brought to finished grade
1. Septic tank manhole covers
2. Splitter box cover
3. Distribution box cover
B. No footer drains or downspouts
to be discharged into septic tanks
C. All waste water to be discharged into
septic tanks

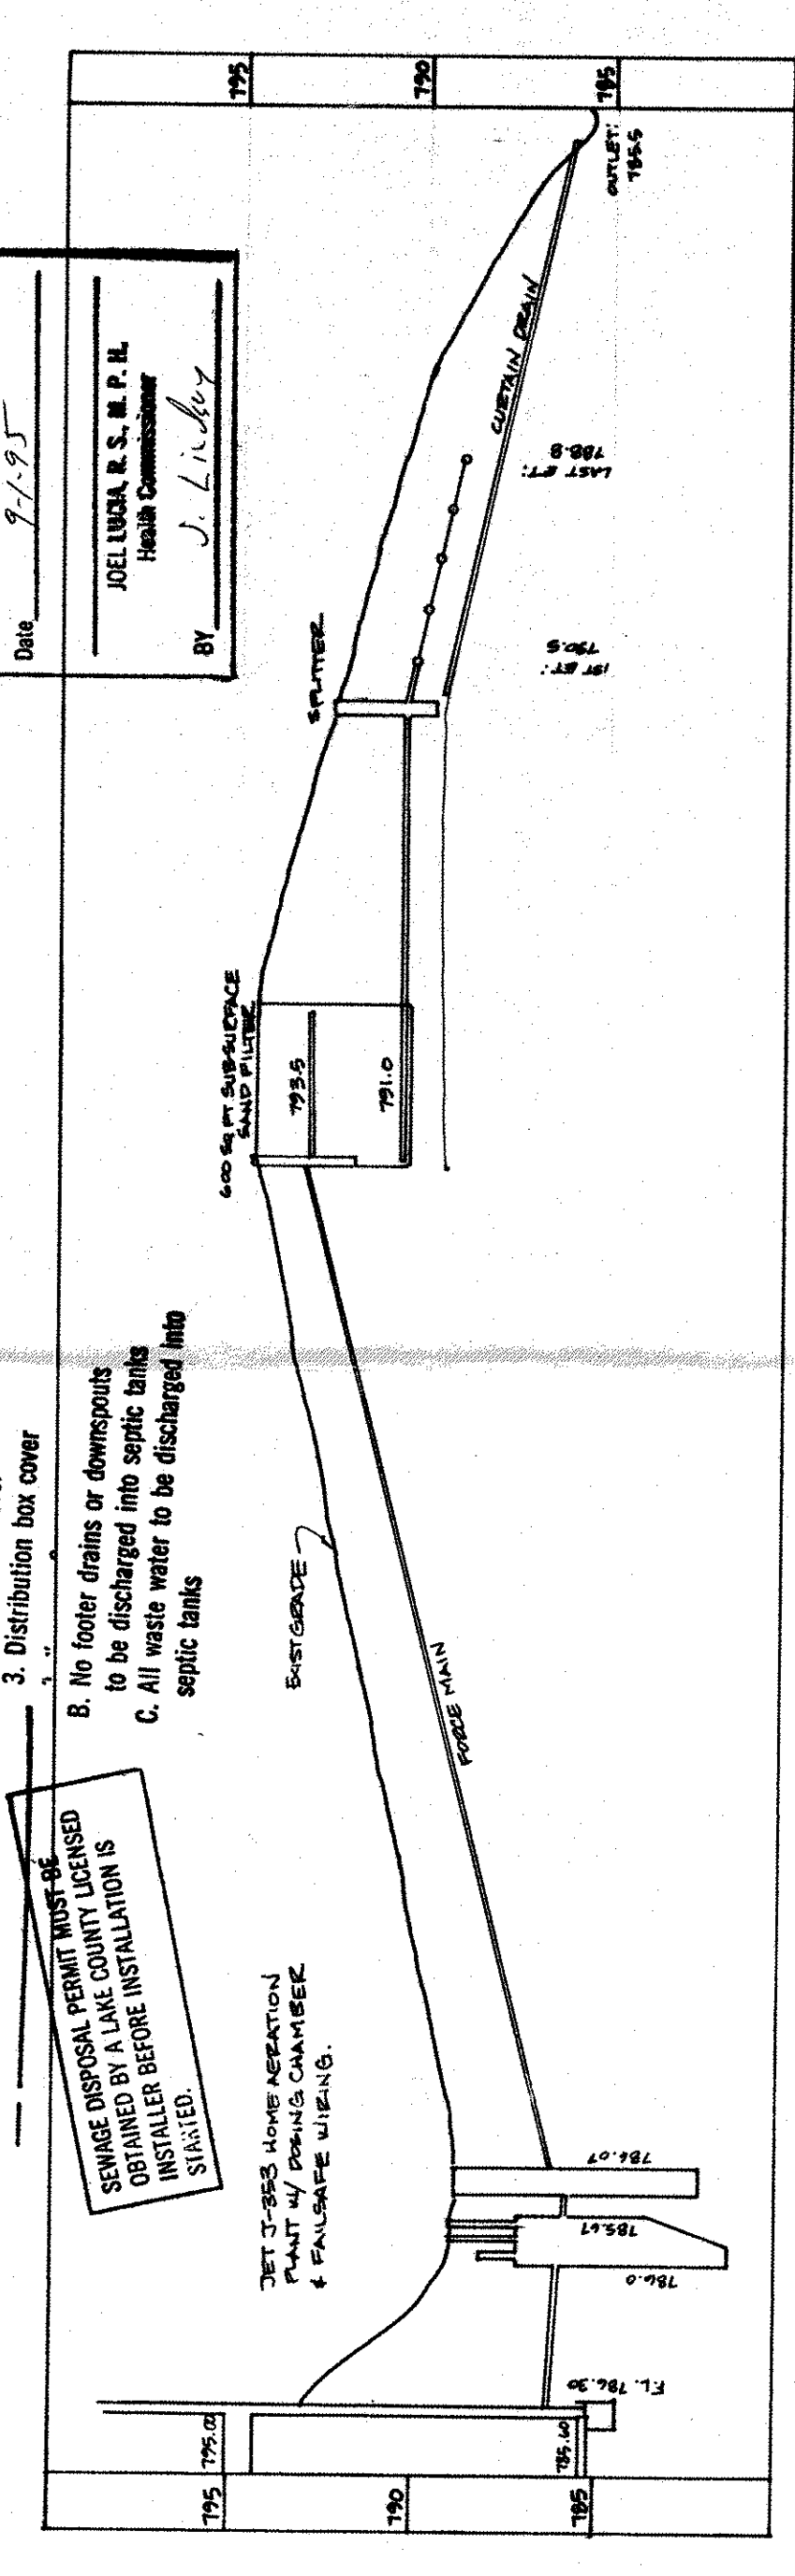

I, Harry S. Jones, Jr., hereby certify that
the above plan and elevations were prepared
by me or under my direct supervision and
that I am a duly licensed Professional Engineer
in the State of Ohio, License No. S-4343, and
that the elevations were taken at
appropriate intervals and that as of that
date they existed as indicated hereon.

Name Harry S. Jones, Jr. Reg. No. 4343

HYDRAULIC PROFILE
HORIZ. 1"=30' VERT. 1"=5'

REV. NO.	DESCRIPTION	DATE	BY	CHKD.

DATE	AUGUST 1995
DESIGN BY	AT
DRAWN BY	DL
APPROVED BY	AT

BABCOCK, JONES AND ASSOCIATES, INC.
CIVIL ENGINEERS - SURVEYORS - LAND PLANNERS
PAINESVILLE OHIO 44077

ROLAND REED

SITE PLAN FOR

96.10 TUENBURY SUBDIVISION 661.20 - 69.93
PERY TOWNSHIP LAKE COUNTY OHIO

SCALE 1"=30'
JOB NO. 95-243-10
SHEET 1 OF 1