

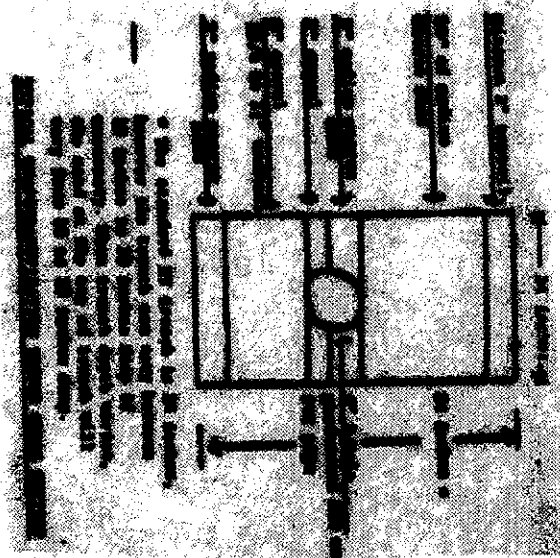
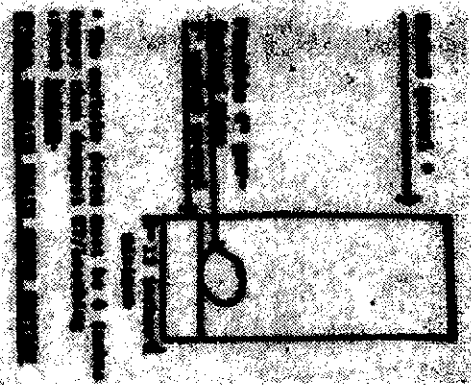


"I, the undersigned hereby certify that this topography indicated by 6", 1" or 2" contours, and elevations shown hereon represent an actual field survey made by me on the 15th day of March, 1991 and that the elevations were taken at appropriate intervals and that as of that date they existed as indicated hereon."


Reg. No.

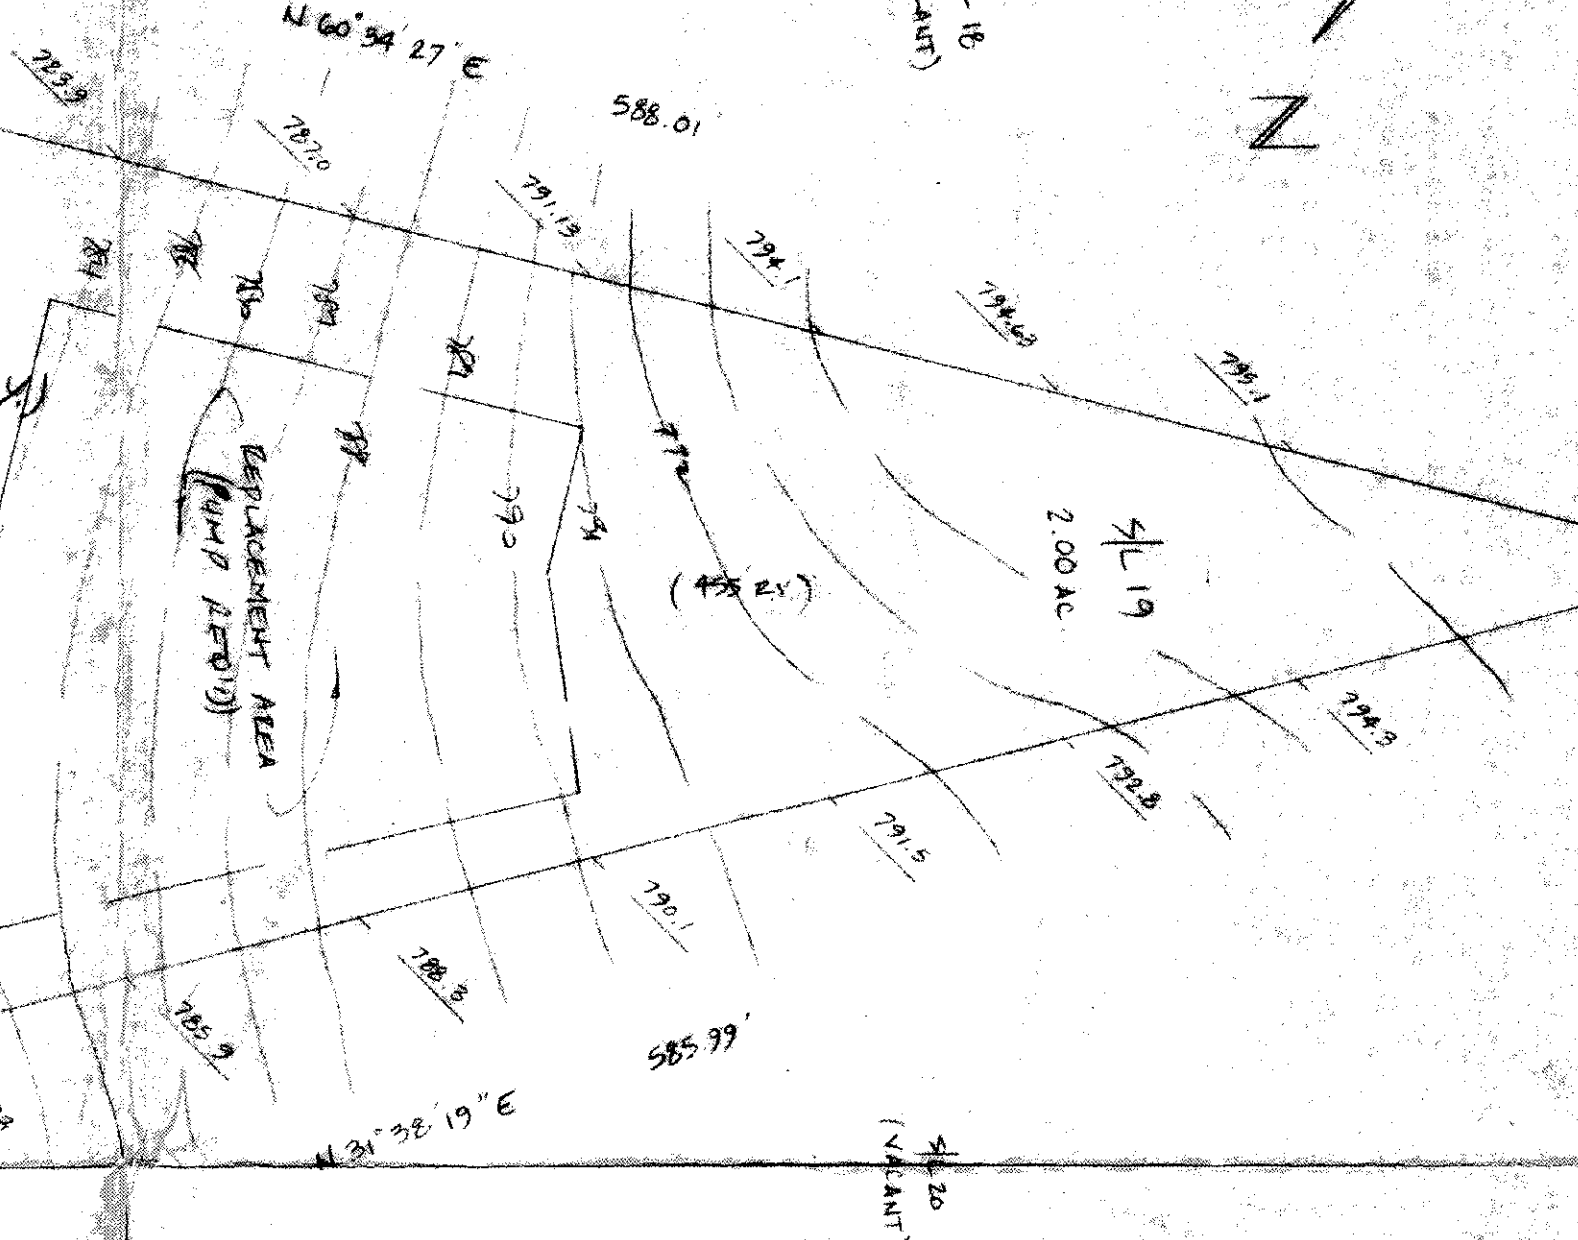

BRIDGEWATER AVENUE

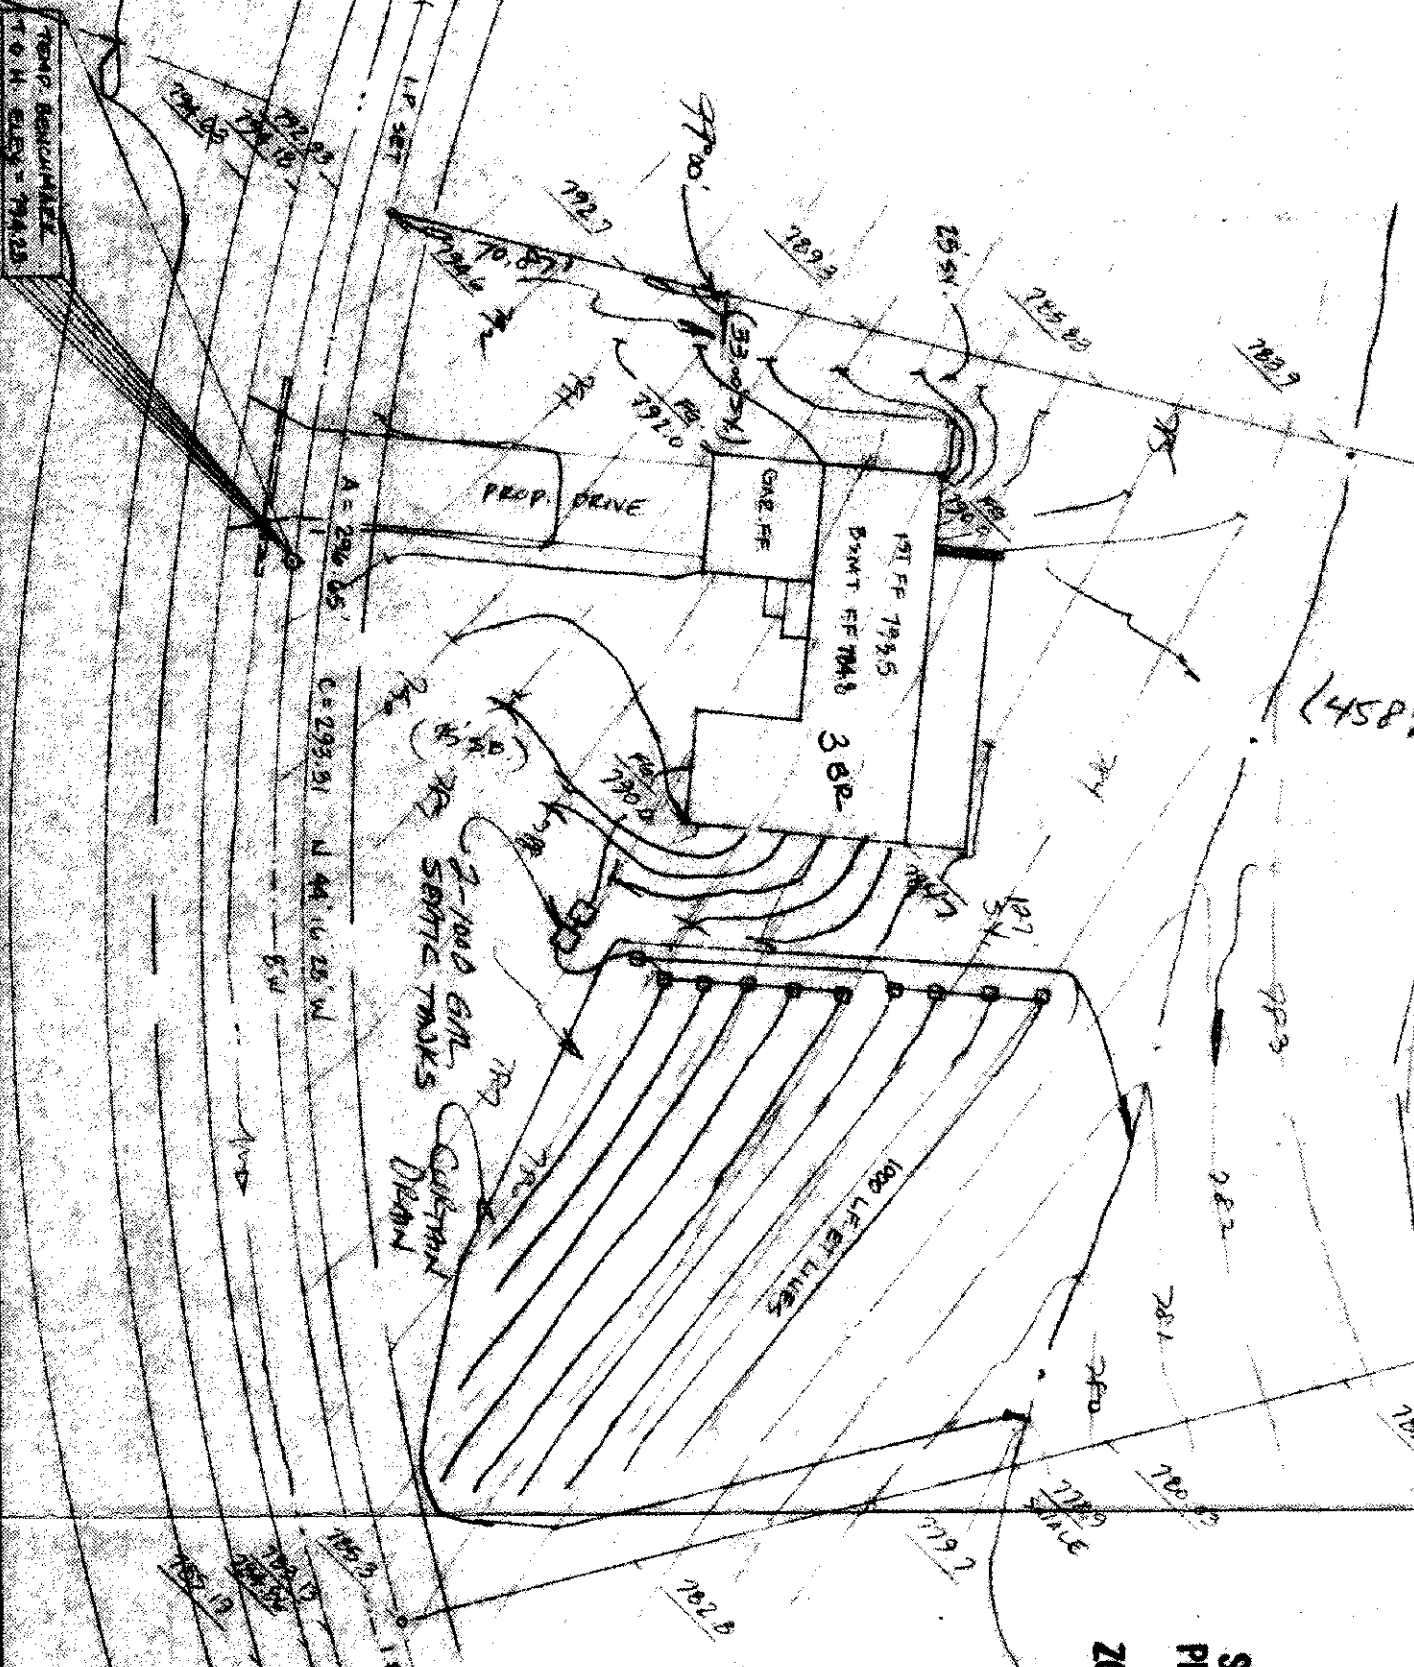

APPROVED
SIDE LINES & SET BACK
PERRY TOWNSHIP ZONING
PERMIT NO. 4492
ZONING INSPECTOR Don

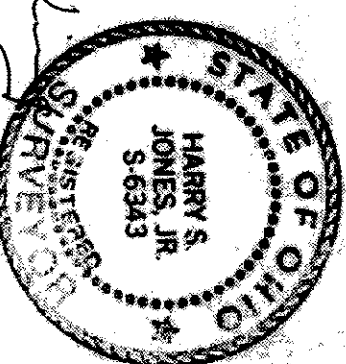

Reviewed and Accepted
LAKE COUNTY GENERAL HEALTH DISTRICT
Date April 10, 1991
JOEL LUCIA, R.S., M.P.H.
Health Commissioner
BY Wendy M. Jones

SEWAGE DISPOSAL PERMIT MUST BE
OBTAINED BY A LAKE COUNTY LICENSED
INSTALLER BEFORE INSTALLATION IS
STARTED.

1. To be brought to finished grade
2. Septic tank manhole covers
3. Distribution box cover

- A. No footer drains or downspouts
- B. No footer drains or downspouts
- C. All waste water to be discharged into septic tanks

WELLINGTON DRIVE - 60'

112" DRIVE

"AS BUILT" CERTIFICATION
I, HEREBY CERTIFY THAT THE CIRCLED GRADES ARE EXISTING
FINISH GRADES CHECKED IN THE FIELD ON 19
AND ARE CORRECT TO THE BEST OF MY KNOWLEDGE AND BELIEF.
REGISTERED SURVEYOR REG. NO. 357-1811

REVISIONS		PLAN PREPARED BY:	
NO.	DATE	BY	DATE
1			
2			
3			
4			
5			

CHECK LIST	
NO. OF BEDROOMS	WATER MAIN SIZE, LOCATION
NO. OF BATHS	SEWER SIZE, LOCATION
NO. OF KITCHENS	STORM SEWER SIZE, LOCATION
NO. OF GARAGES	STORM SEWER SIZE, LOCATION
NO. OF PORCHES	STORM SEWER SIZE, LOCATION
NO. OF DRIVEWAYS	STORM SEWER SIZE, LOCATION
NO. OF FENCES	STORM SEWER SIZE, LOCATION
NO. OF UTILITY LINES	STORM SEWER SIZE, LOCATION
NO. OF OTHER FEATURES	STORM SEWER SIZE, LOCATION

DESIGN CERTIFICATION
THIS PLAN WAS PREPARED BY ME, AND IS CORRECT
TO THE BEST OF MY KNOWLEDGE AND BELIEF.
NAME Harry S. Jones, Jr.
SURVEYOR REGISTRATION NO. 6343

REMARKS
ALL BOUNDARY DATA SHOWN WAS OBTAINED FROM 1980S, RECORDED
SURVEYOR'S PLAT ON OTHER PUBLIC RECORDS
LOCATIONS AS SHOWN OF ADJACENT WELLS AND SEPTIC TANKS OBTAINED FROM
LAKE COUNTY HEALTH DEPARTMENT

LEGEND	
BANITARY MANHOLE	WATER VALVE (GAS)
STORM MANHOLE	WATER METER (GAS)
INLET OR CATCH BASIN	AS BUILT ELEVATION
HYDRANT	INDICATES
EXISTING CONTOURS	DIRECTION OF
PROPOSED CONTOURS	SURFACE DRAINAGE
EXIST. ELEV.	
PROP. ELEV.	

SITE PLAN
PERRY TOWNSHIP, LAKE COUNTY, OHIO
for: MARLE ECKEL
OWNER
ADDRESS WELLINGTON DRIVE CITY WELLINGTON STATE OHIO
SUBJECT NO. 19 DATE 13-25-91 TRACT 19 PAGE 1
VOLUME 1 SHEET NO. 1 OF 1