
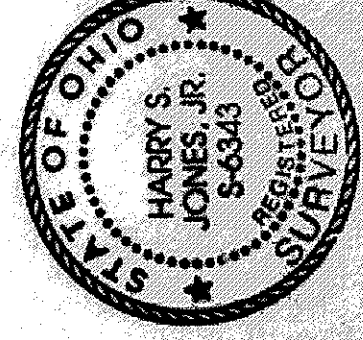
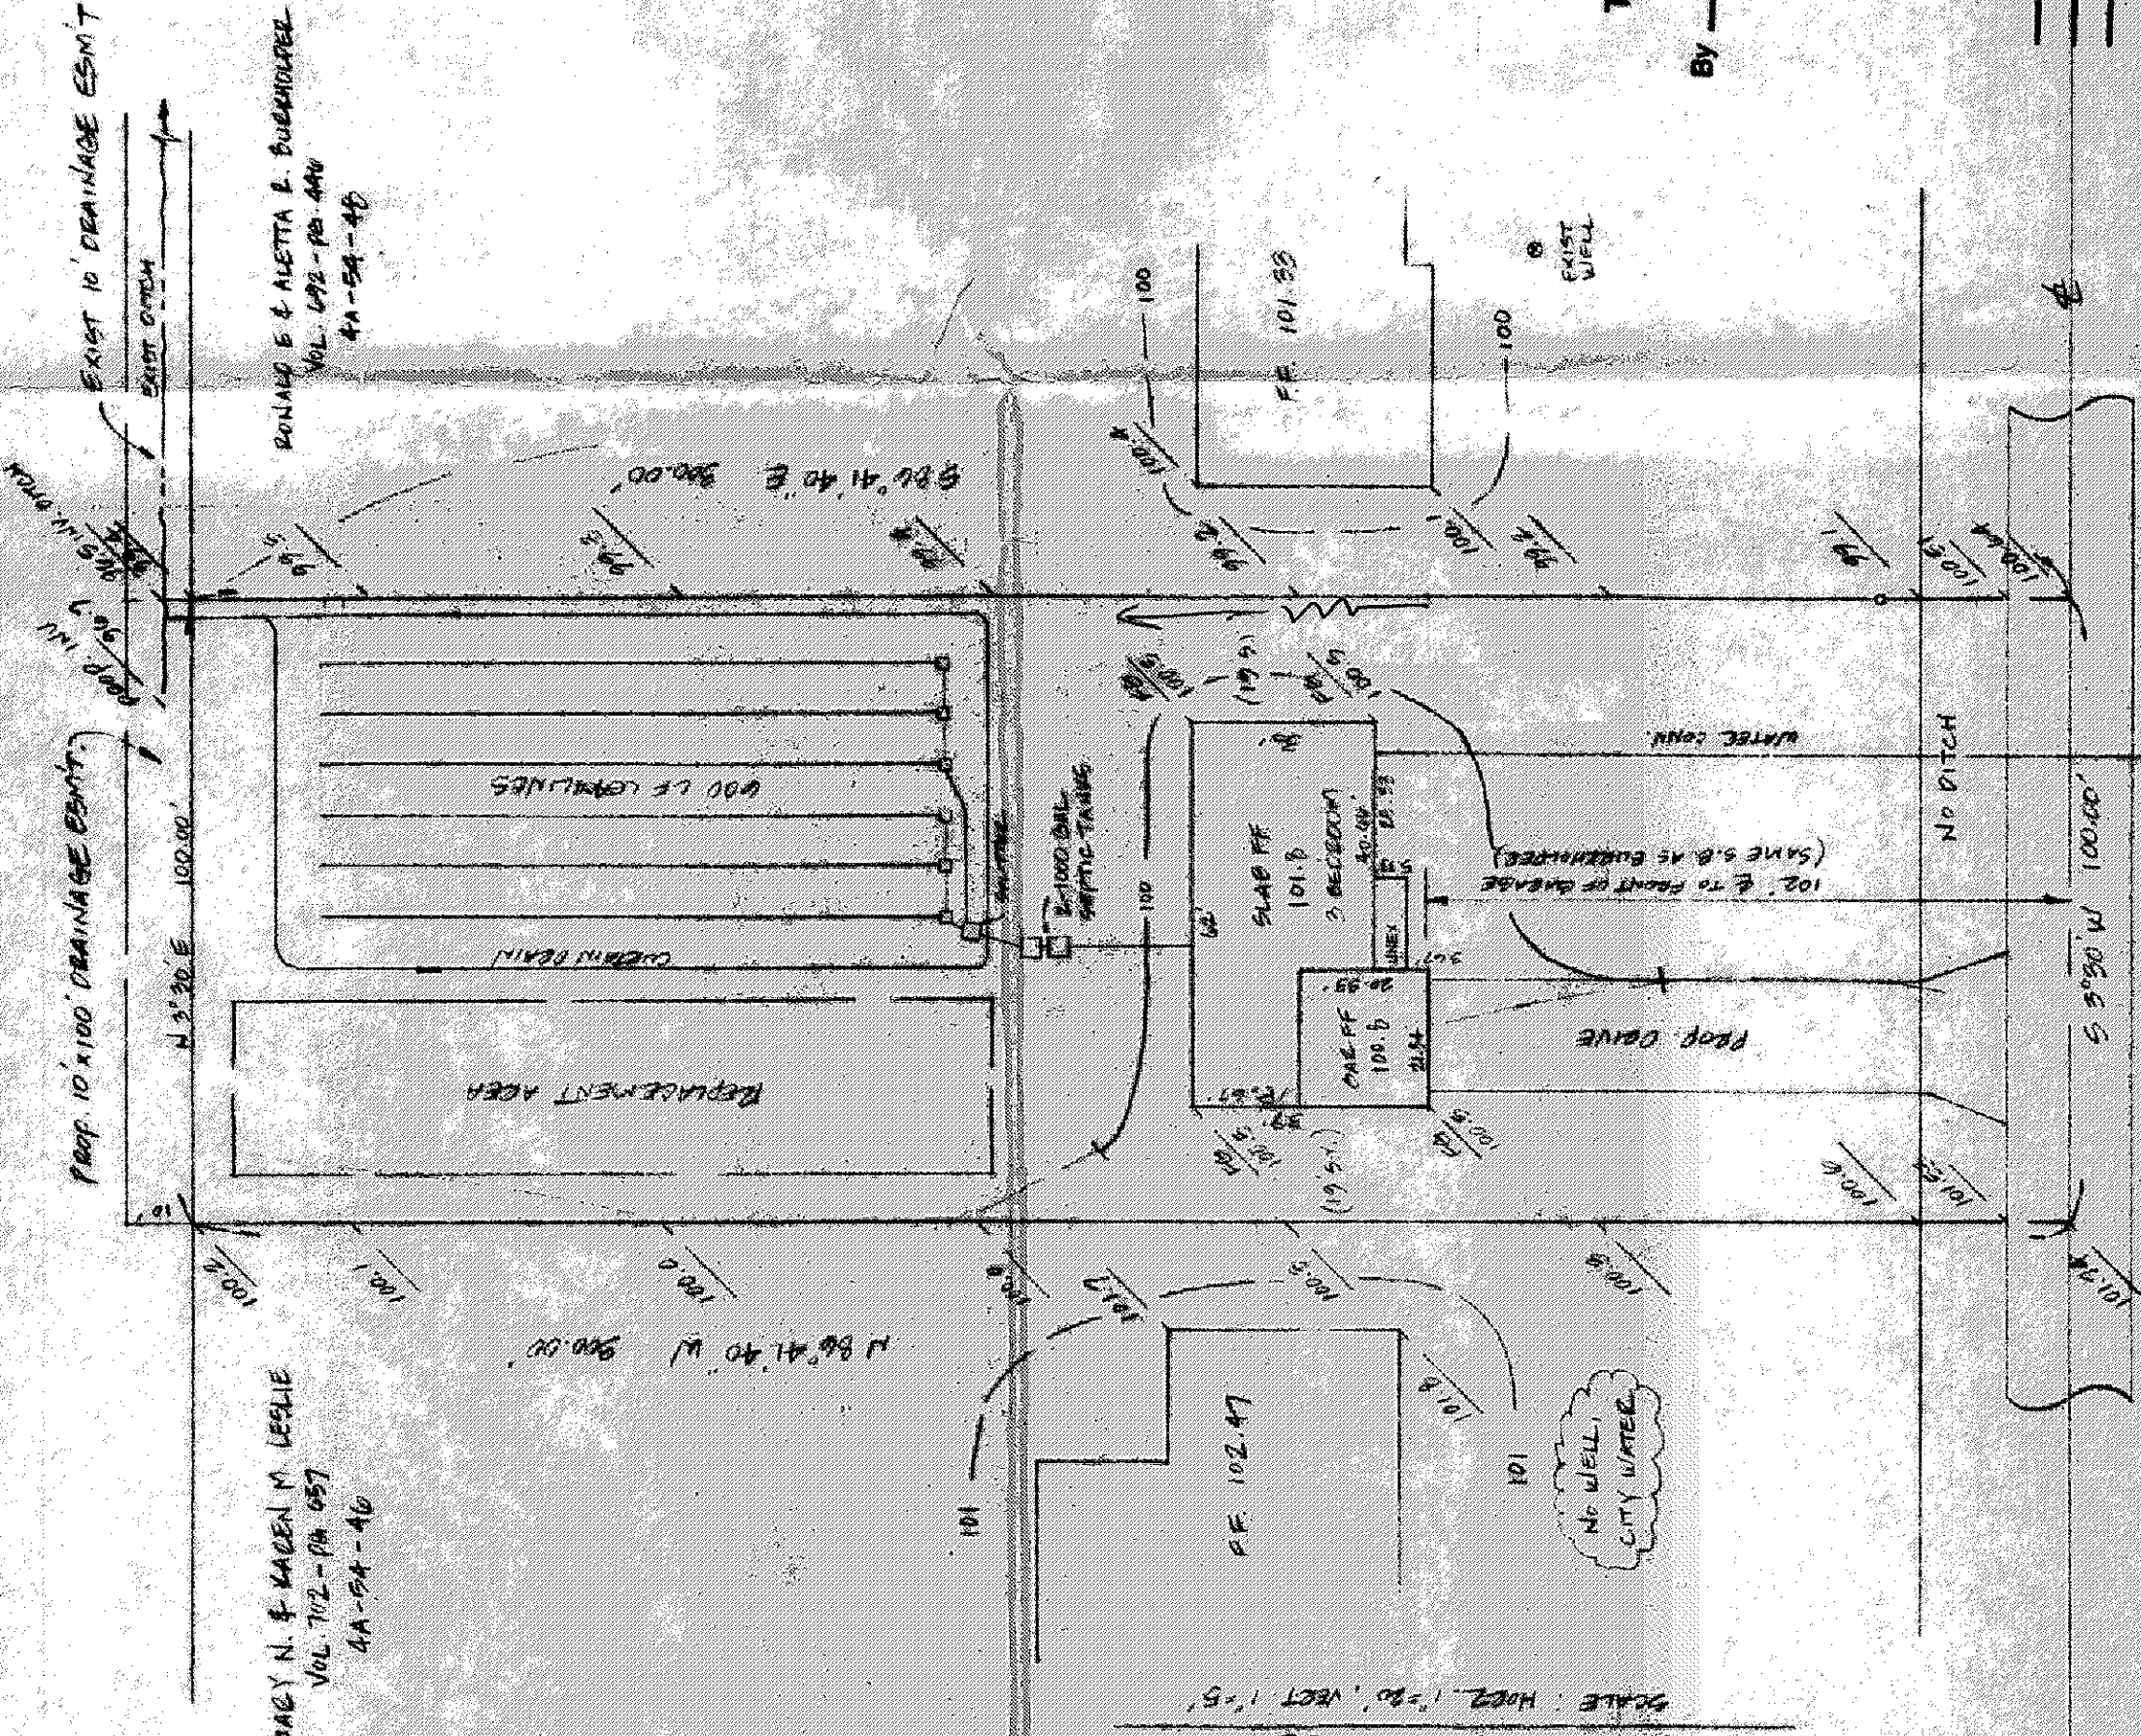
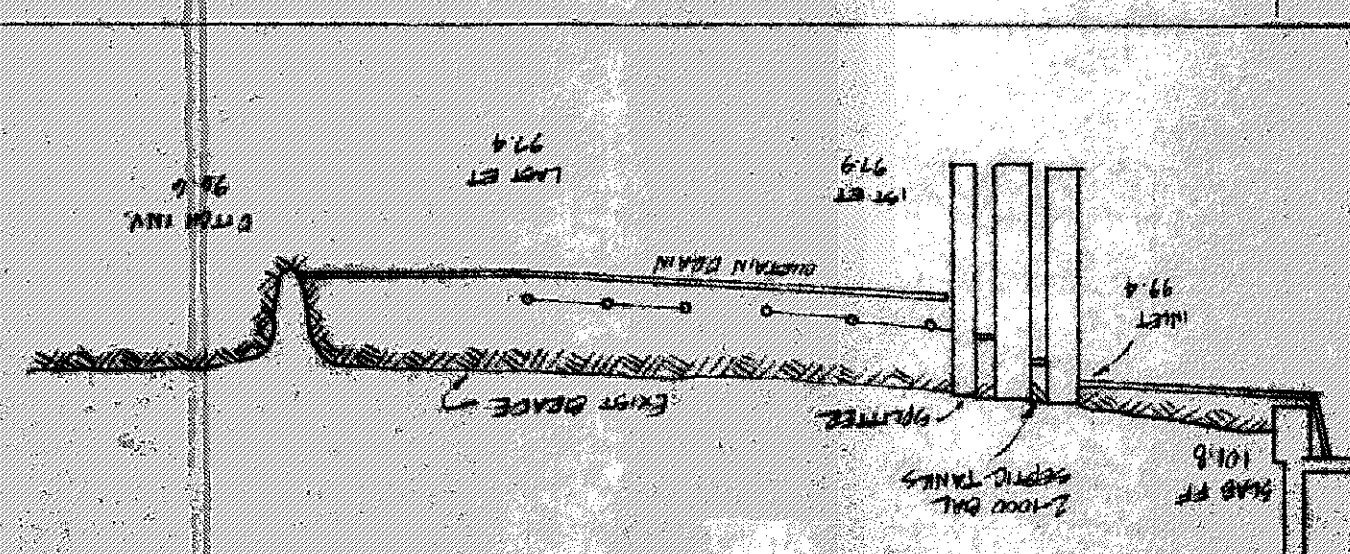
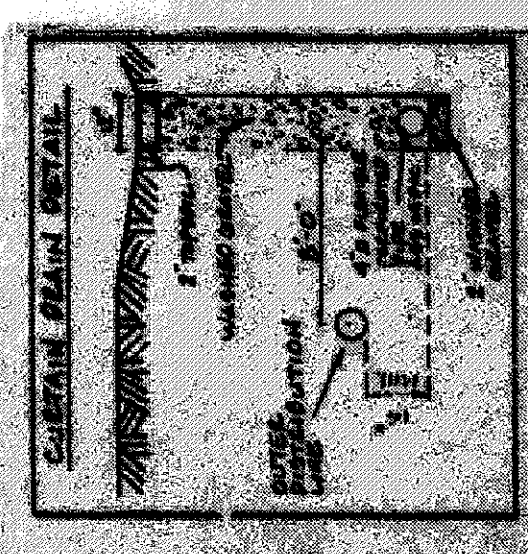


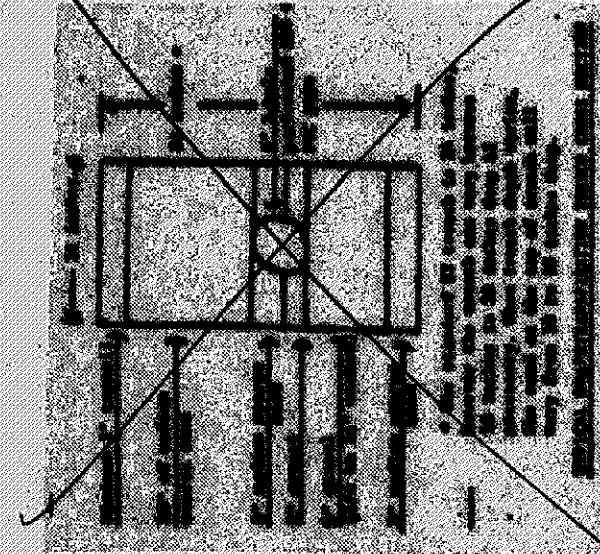

SITE PLAN
VILLAGE OF PERRY, LAKE COUNTY, OHIO
for: **NAUGHTON BUILDERS INC**
CLIENT

ADDRESS: STREET CITY ZIP
SUBDIVISION: NAME LOT 141 TRACT 114
VOLUME: 54-54 PAGE 114
SUBLOT NO. STREET

LEGEND
SANITARY MANHOLE
STORM MANHOLE
INLET OR CATCH BASIN
HYDRANT
EXISTING CONTOURS
PROPOSED CONTOURS
EXIST. ELEV. 100.0
PROP. ELEV. 100.0
WATER VALVE (GAS)
WATER METER (GAS)
AS BUILT ELEVATION
INDICATES DIRECTION OF SURFACE DRAINAGE

REMARKS
ALL BOUNDARY DATA SHOWN WAS OBTAINED FROM (DEEDS, RECORDED SUBDIVISION PLAT OR OTHER PUBLIC RECORDS)
LOCATIONS AS SHOWN OF ADJACENT WELLS AND SEPTIC TANKS OBTAINED FROM LAKE COUNTY HEALTH DEPARTMENT

DESIGN CERTIFICATION
THIS PLAN WAS PREPARED BY ME, AND IS CORRECT TO THE BEST OF MY KNOWLEDGE AND BELIEF.
NAME: **HARRY S. JONES, JR.**
SURVEYOR REGISTRATION NO. **8-6343**

CHECK LIST
NO. OF BEDROOMS
DIMENSIONS
TIE TO NEAREST STREET
SURLOT NO. PARCEL NO.
SURROUNDING OWNERS
BLDG. DIMENSIONS FIN. GR.
BLDG. TIES P.L.T. GRADES
APPROX. TYPE WIDTH THICKNESS
SIDEWALK TYPE DIA. LENGTH
CULVERT TYPE DIA. LENGTH
ROCK OUTCROPPINGS
WATER MAIN SIZE LOCATION
SAN. SEWER SIZE & GR. LOC.
SAN. MH. DIA. ELEV. INV. ELEV.
SAN. CONN. SIZE LOC. DEPTH
STORM SEWER SIZE & GR. LOC.
STORM MH. DIA. ELEV. INV. ELEV.
PAV'T TYPE GRADE CURVES
GAS LINE LOC. SIZE PRESSURE
SEPTIC TANK LOCATION & DUPLICATION AREA
WELL LOCATION
ISOLATION RADIUS FROM WELL

PLAN PREPARED BY:
BABCOCK • JONES & ASSOCIATES, INC.
PAINESVILLE, OHIO
DRAWN BY: **PH** SCALE: 1" = 30' PHONE NO. 357-1811
CHK'D: **PH** DATE: 6-5-92 DRAWING NO. 92-136
CREW CHIEF: **PH**

"AS BUILT" CERTIFICATION
I, HEREBY CERTIFY THAT THE CIRCLED GRADES ARE EXISTING FINISH GRADES CHECKED IN THE FIELD ON 19
AND ARE CORRECT TO THE BEST OF MY KNOWLEDGE AND BELIEF.
By: **THOMAS P. GILLES, P.E.** Date: 8/18/92
Lake County Engineer
REGISTERED SURVEYOR REG. NO.

T.E.M.: P.K. NAIL IN POLE, LOT NORTH OF NAUGHTON, 100.00.

SEWAGE DISPOSAL PERMIT MUST BE OBTAINED BY A LAKE COUNTY LICENSED INSTALLER BEFORE INSTALLATION IS STARTED.

Reviewed and Accepted
LAKE COUNTY GENERAL HEALTH DISTRICT
Date: August 17, 1992
JOEL LUCIA, R. S. M. P. H.
Health Commissioner
BY: **Nancy Means** Reg. No. 76343

LOW YIELD WATER FIXTURES REQUIRED ON ALL: Shower Head Toilet
A. To be brought to finished grade
1. Septic tank manhole covers
2. Splitter box cover
3. Distribution box cover
B. No footer drains or downspouts to be discharged into septic tanks
C. All waste water to be discharged into septic tanks