
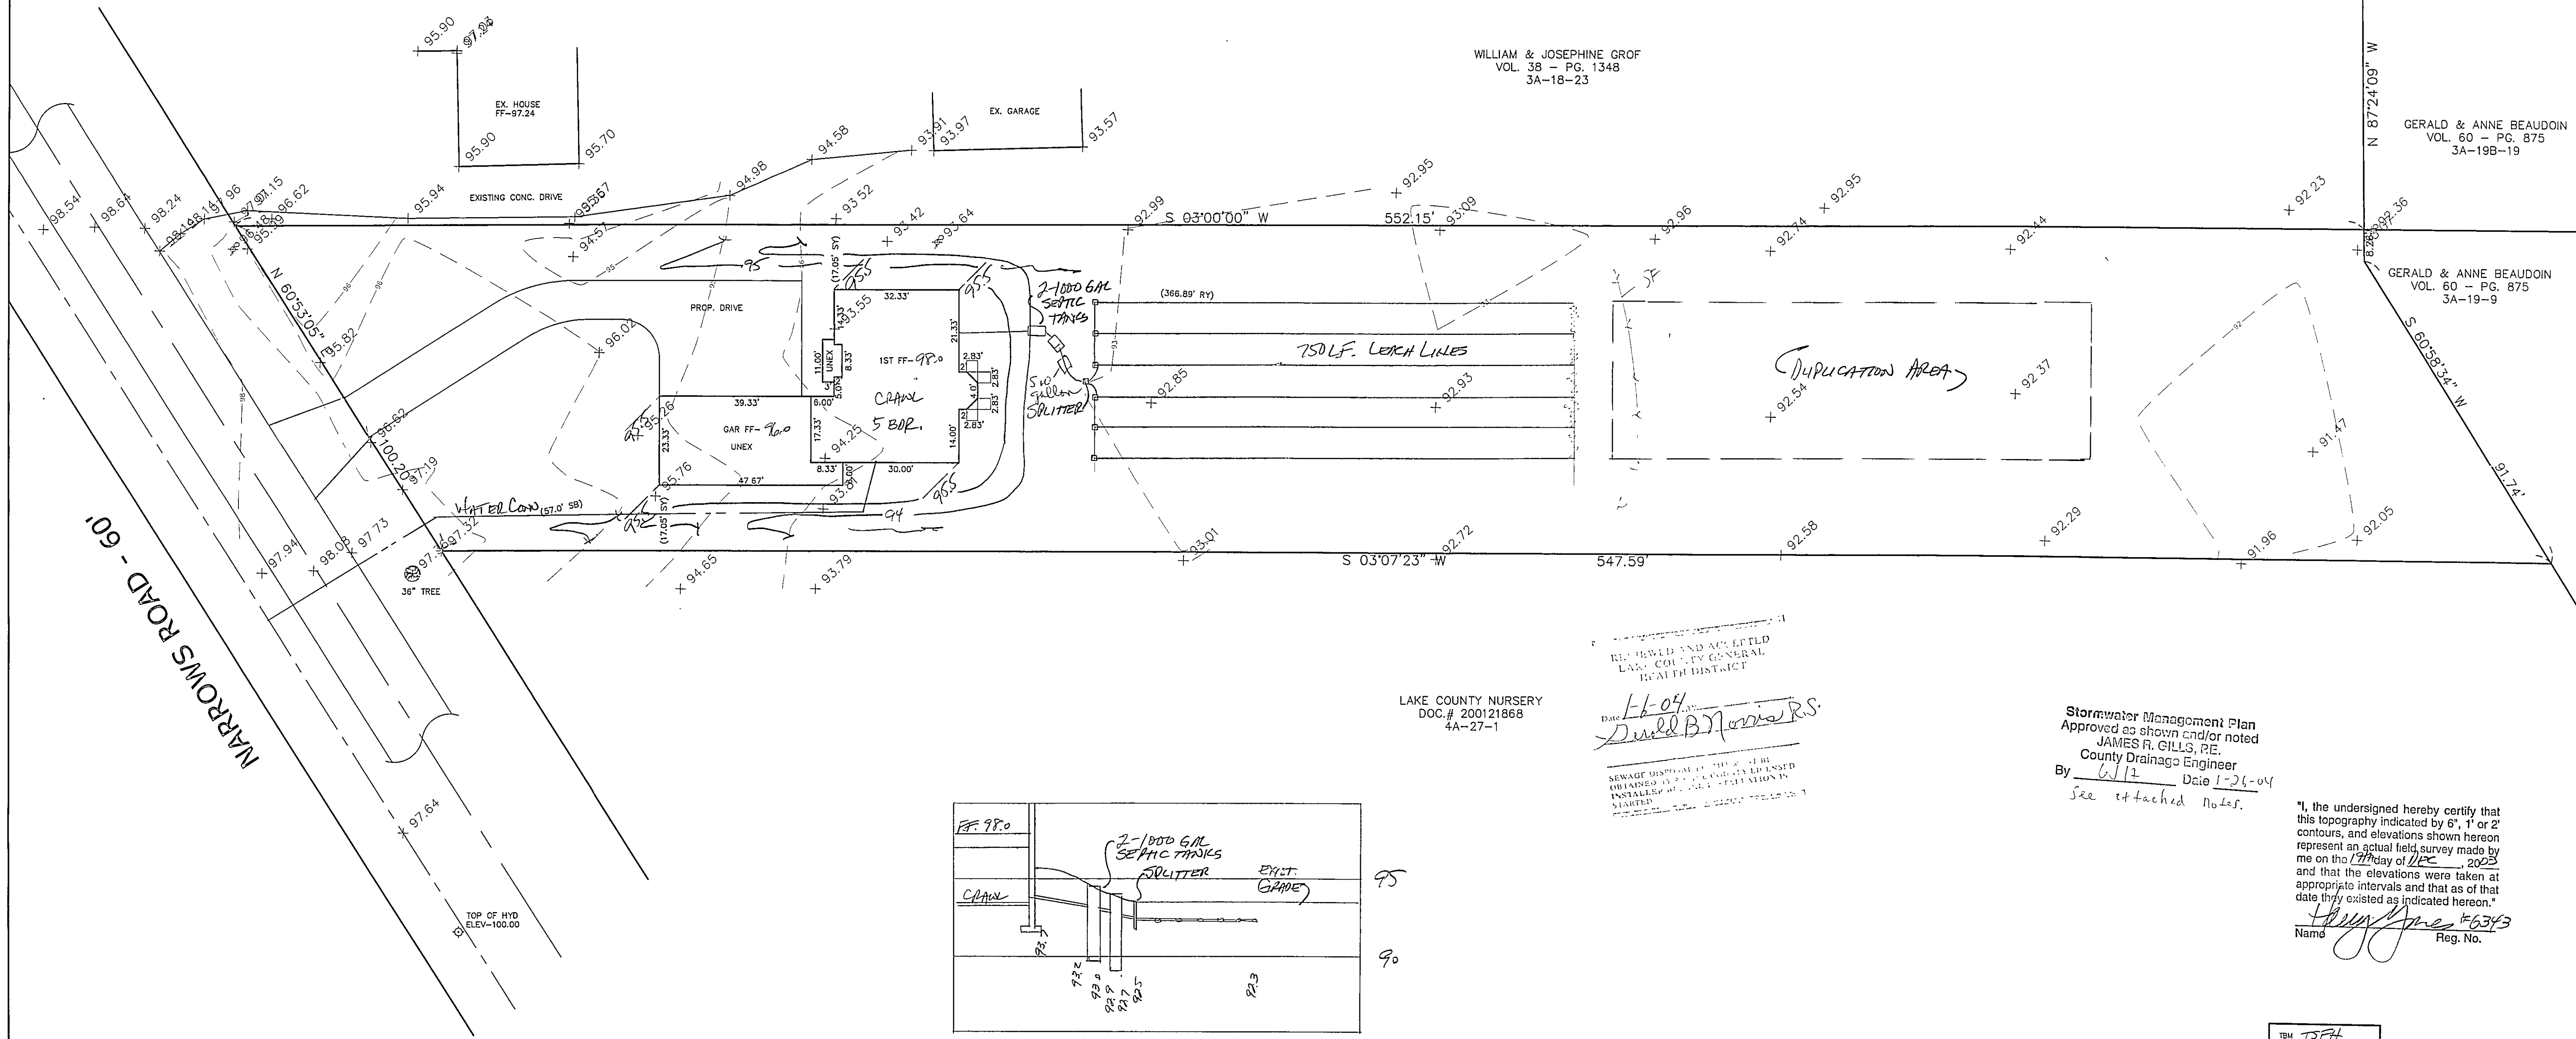


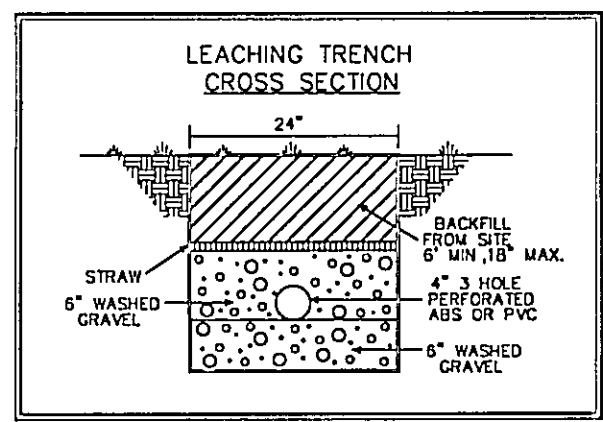


LAKE COUNTY NURSERY
DOC. # 200121868
4A-27-1

REVIEWED AND ACCEPTED
LAKE COUNTY GENERAL
HEALTH DISTRICT
Date 11-04-04
Daniel B. Jones R.S.
SEWAGE DISPOSAL SYSTEMS
OBTAINED BY FIELD SURVEY
INSTALLATION OF SEWAGE TREATMENT
STARTED

Stormwater Management Plan
Approved as shown and/or noted
JAMES R. GILLS, P.E.
County Drainage Engineer
By 6/1/04 Date 1-26-04
See attached Notes.


"I, the undersigned hereby certify that this topography indicated by 6", 1' or 2' contours, and elevations shown hereon represent an actual field survey made by me on the 17th day of APR, 2003 and that the elevations were taken at appropriate intervals and that as of that date they existed as indicated hereon."
Name Daniel B. Jones #6343 Reg. No.

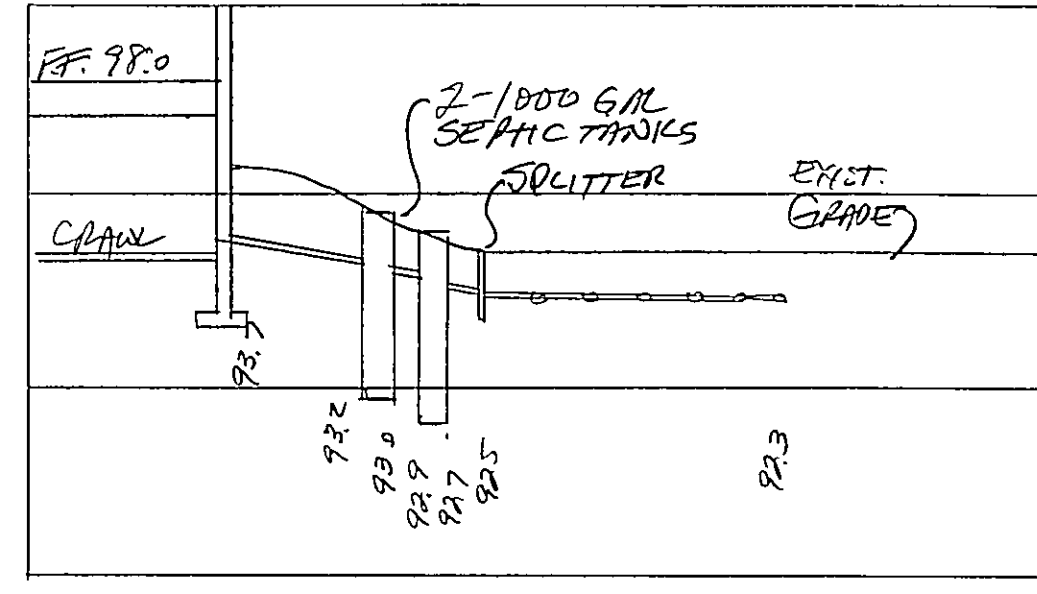

HYDRAULIC PROFILE
HORIZ: 1"=20' VERT: 1"=5'

TBM TSPH
ELEV= 100.00

EXISTING UTILITIES NOTE:
THE SIZE AND LOCATION, BOTH HORIZONTAL AND VERTICAL OF THE UNDERGROUND UTILITIES SHOWN HEREON, HAVE BEEN OBTAINED BY A SEARCH OF AVAILABLE RECORDS. VERIFICATION BY FIELD OBSERVATION HAS BEEN CONDUCTED WHERE PRACTICAL. HOWEVER, BABCOCK, JONES AND ASSOCIATES INC. DOES NOT GUARANTEE THE COMPLETENESS NOR ACCURACY THEREOF.

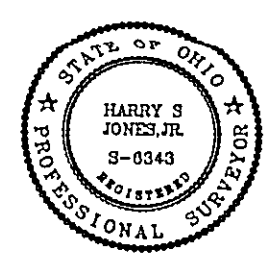

REV. NO.	DESCRIPTION	DATE	BY	CHK'D

BABCOCK, JONES AND ASSOCIATES, INC
CIVIL ENGINEERS - SURVEYORS - LAND PLANNERS
PAINESVILLE OHIO 44077

DATE 12/22/03
DESIGN BY HJ
DRAWN BY NS
APPROVED BY HJ

SITE PLAN FOR KNEZ CONSTRUCTION
PARCEL # 4A-27-5
PERRY TOWNSHIP LAKE COUNTY STATE OF OHIO

SCALE 1"=20'
JOB NO 03-306
SHEET 1 OF 1