




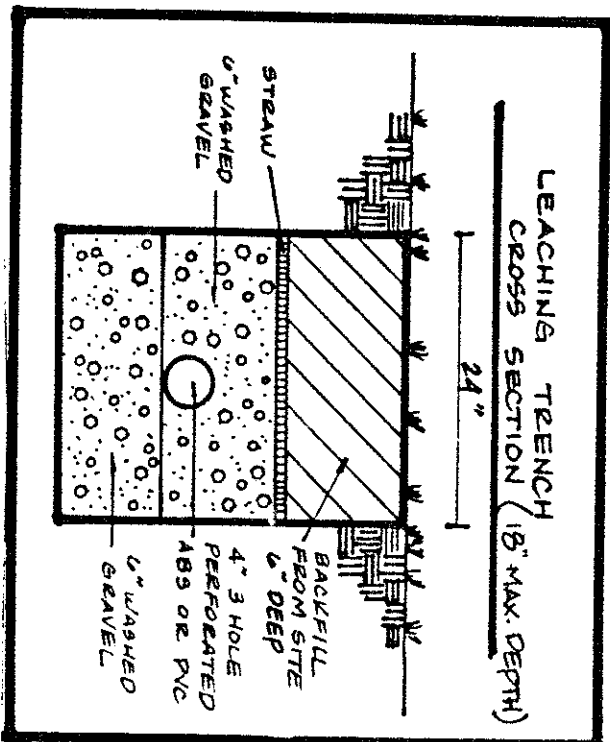

NOTE: SOIL CLASSIFICATION FOR P.P. # 4A-28-7 PER LAKE COUNTY SOIL SURVEY: ODB, CHISVILLE GRANULY LOAMY SAND.

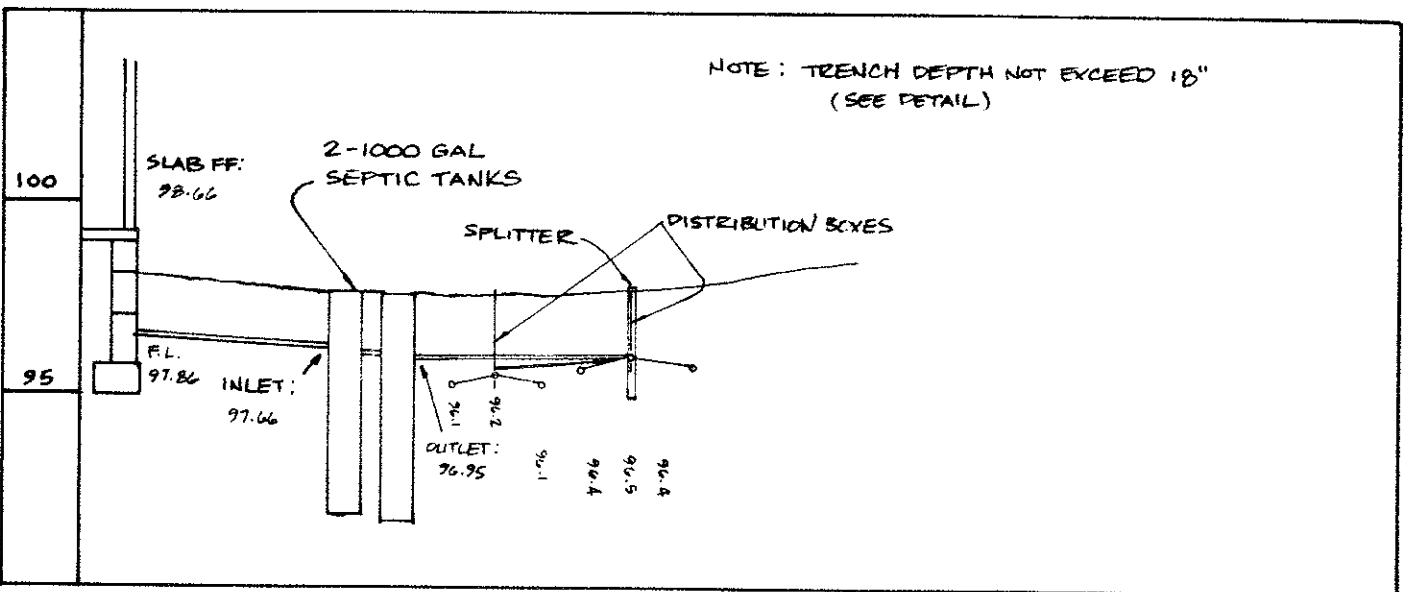

HYDRAULIC PROFILE
HORZ. 1"=20' , VERT. 1"=5'

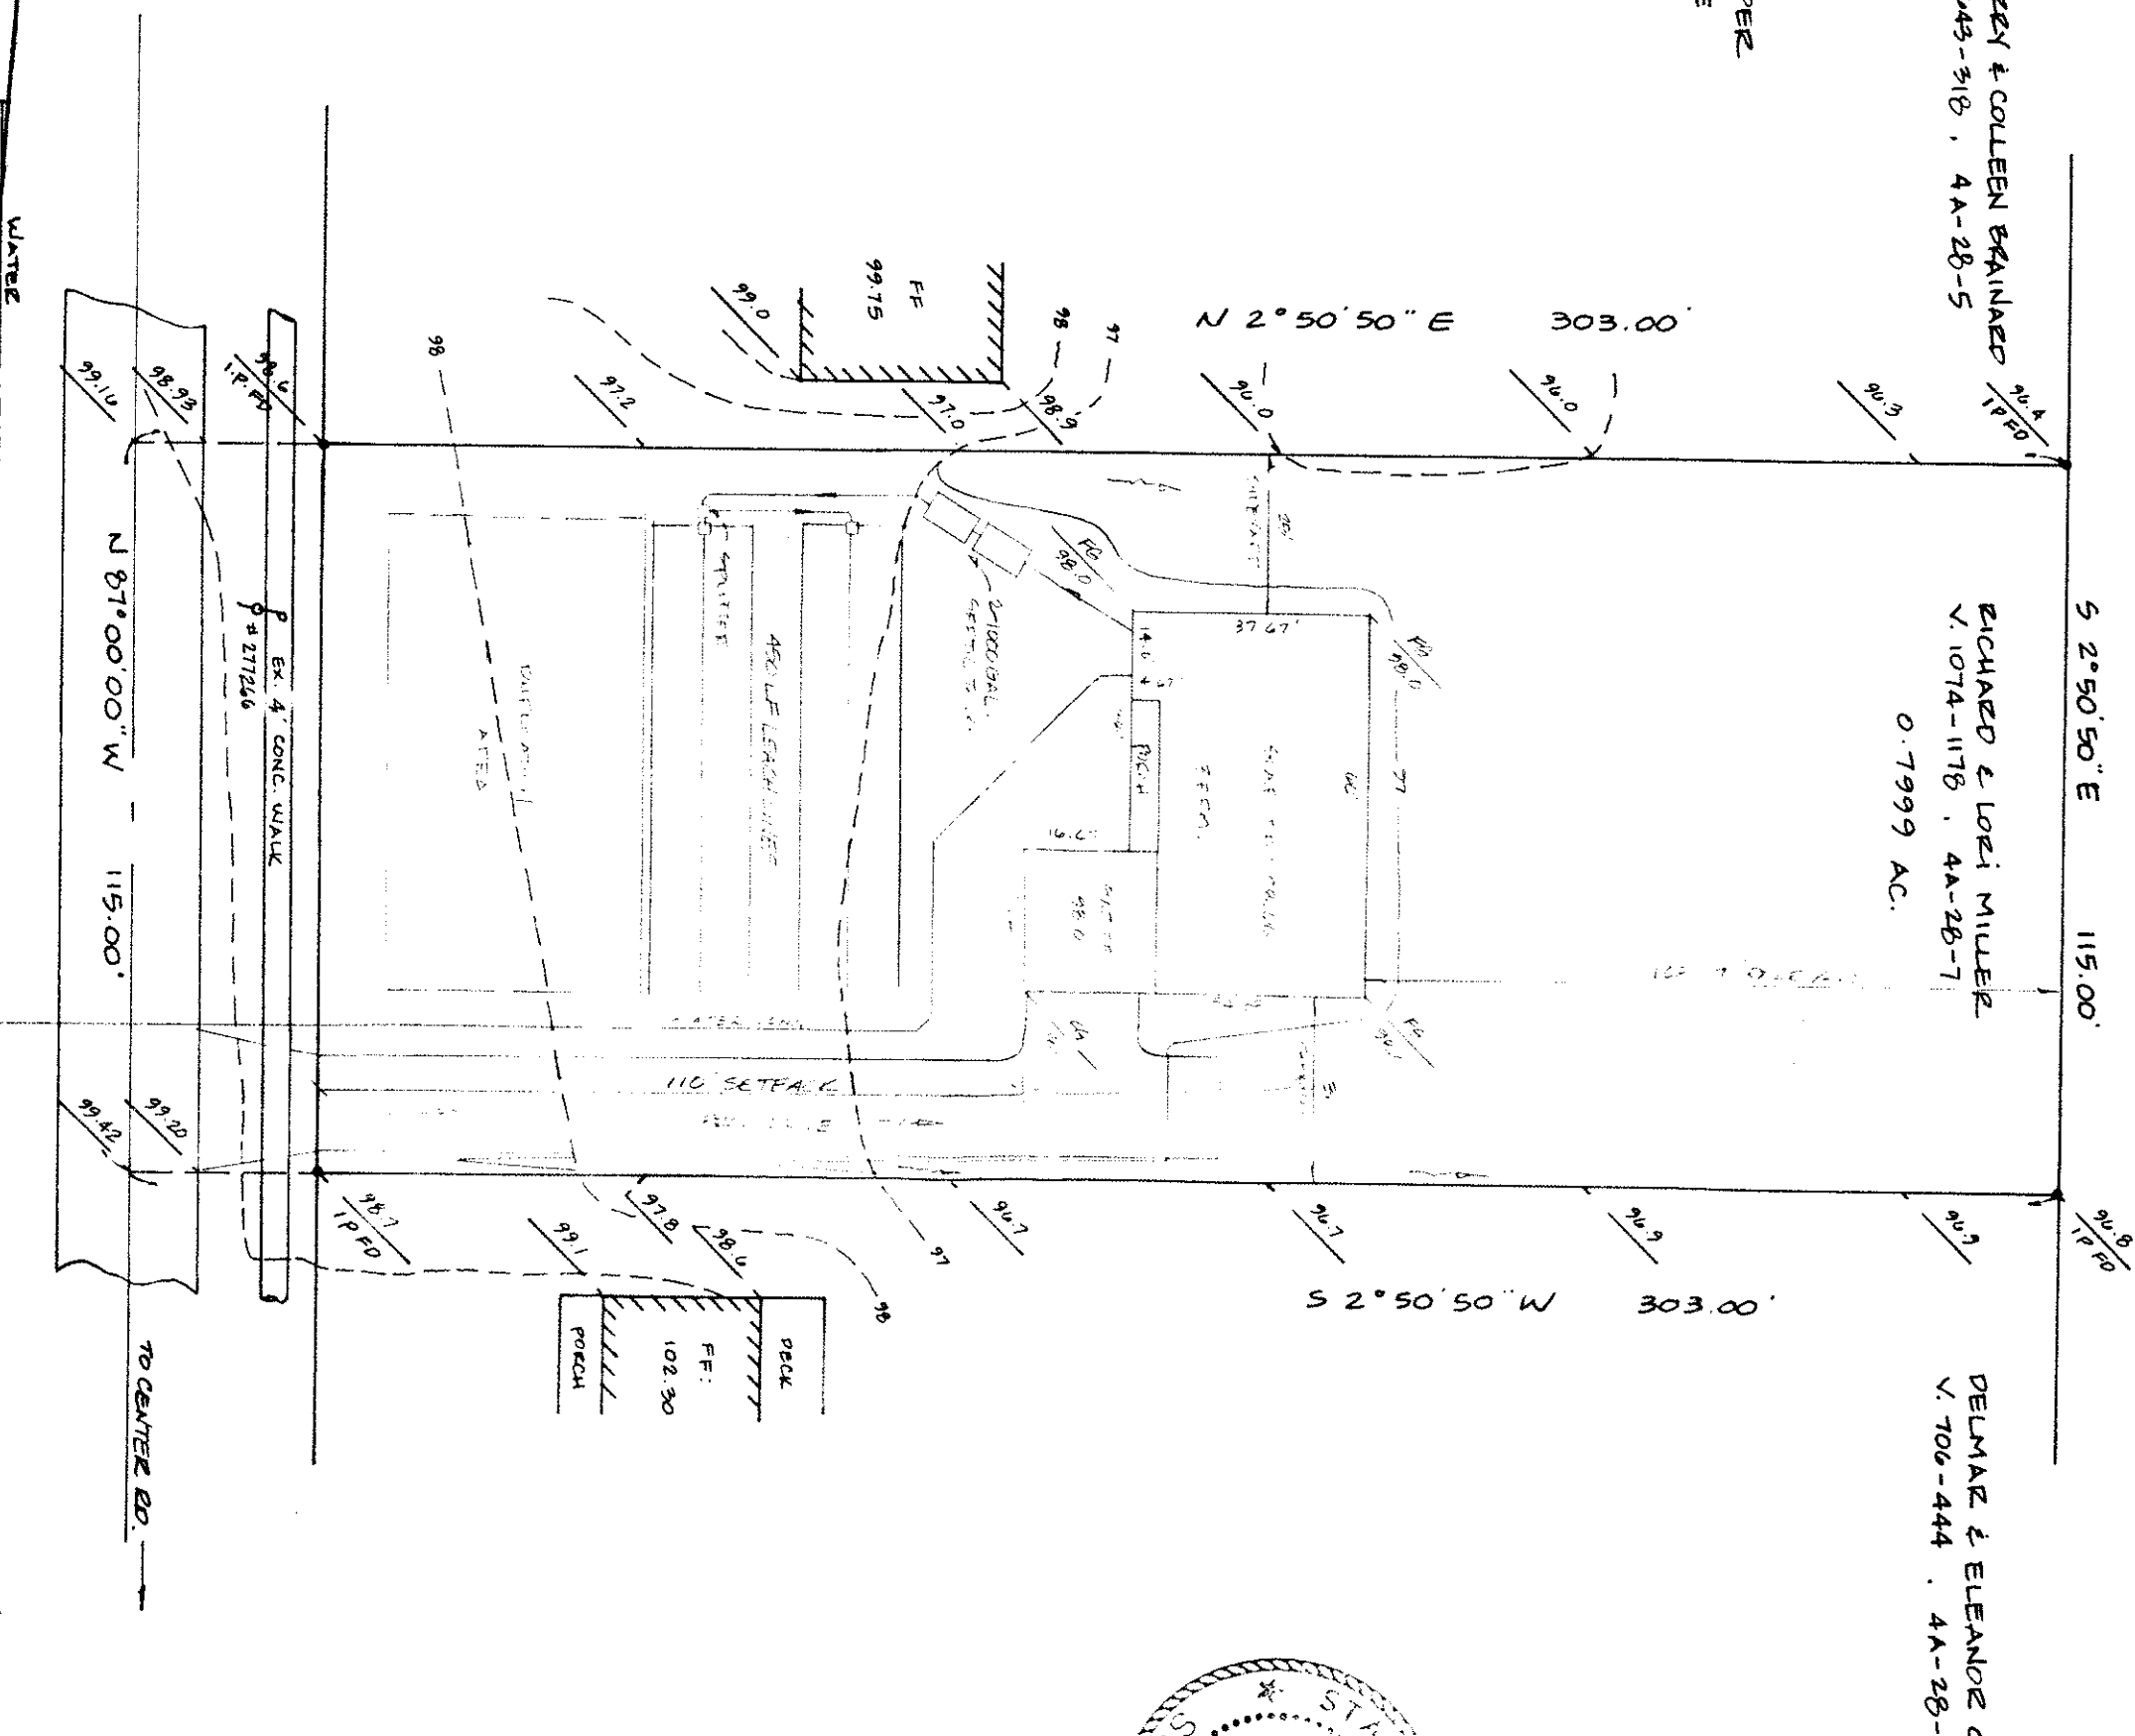


LAKE CO. NURSERY INC
V. 571-110, 4A-28-1

LAKEY & COLLEEN TRAINING
V. 443-318, 4A-28-5

EDWARD & LOUISE MILLER
V. 1074-1178, 4A-28-7
0.7999 AC.

DELMARZ & ELEANOR CROSS
V. 706-444, 4A-28-14

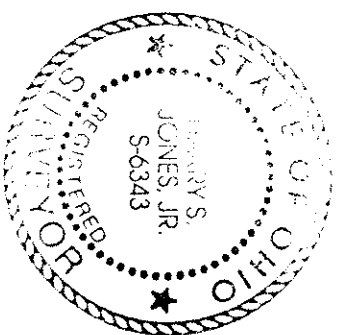

SITE PLAN

VILLAGE OF PERRY, LAKE COUNTY, OHIO

for: DICK ARNOLD

CLIENT OWNER

ADDRESS STREET CITY ZIP

SUBDIVISION NAME LOT 174 TRACT 117B
VOL. - PG. VOLUME 4A-28-7 PAGE MAIN ST.
SUBLOT NO. STREET PERM. PARCEL NO. STREET

LEGEND

SANITARY MANHOLE
STORM MANHOLE
INLET OR CATCH BASIN
HYDRANT
EXISTING CONTOURS
PROPOSED CONTOURS
EXIST. ELEV. 100.0
PROP. ELEV. 100.0

WATER VALVE (GAS)
WATER METER (GAS)
AS BUILT ELEVATION
INDICATES DIRECTION OF SURFACE DRAINAGE

REMARKS

ALL BOUNDARY DATA SHOWN WAS OBTAINED FROM (DEEDS, RECORDED SUBDIVISION PLAT OR OTHER PUBLIC RECORDS)
LOCATIONS AS SHOWN OF ADJACENT WELLS AND SEPTIC TANKS OBTAINED FROM LAKE COUNTY HEALTH DEPARTMENT

DESIGN CERTIFICATION

THIS PLAT WAS PREPARED BY ME, AND IS CORRECT TO THE BEST OF MY KNOWLEDGE AND BELIEF.

NAME SURVEYOR REGISTRATION NO.

CHECK LIST

NO. OF BEDROOMS
DIMENSIONS
SAN. SEWER SIZE % GR. LOC.
TIE TO NEAREST STREET
SUBLOT NO. PARCEL NO.
SURROUNDING OWNERS
BLDG. DIMENSIONS FIN. GR.
APRON TYPE GRADE CURBS
SEPTIC TANK LOCATION & DUPLICATION AREA
WELL LOCATION
ISOLATION RADII FROM WELL

WATER MAIN SIZE, LOCATION
SAN. SEWER SIZE % GR. LOC.
SAN. MH. CAST. ELEV. INV. ELEV.
STORM SEWER SIZE % GR. LOC.
STORM MH. CAST. ELEV. INV. ELEV.
PAV'T TYPE GRADE CURBS
GAS LINE LOC. SIZE PRESSURE
SEPTIC TANK LOCATION & DUPLICATION AREA
WELL LOCATION
ISOLATION RADII FROM WELL

PLAN PREPARED BY: BABCOCK & JONES & ASSOCIATES, INC.

PAINESVILLE, OHIO

NO.	DATE	BY
1	6/10/95	φ
2		
3		
4		
5		

DRAWN BY φ SCALE 1" = 30' PHONE NO. 357-1811
CHKD. DATE 6/10/95 DRAWING NO. 95-133
CREW CHIEF APPD. 197

"AS BUILT" CERTIFICATION

I, HEREBY CERTIFY THAT THE CIRCLED GRADES ARE EXISTING FINISH GRADES CHECKED IN THE FIELD ON 19 19
AND ARE CORRECT TO THE BEST OF MY KNOWLEDGE AND BELIEF.

REGISTERED SURVEYOR

REG. NO.

BENCHMARK: NAIL SET IN P.P. # 27200, ELEV. = 100.00.

6111

6195

SEWAGE DISPOSAL PERMIT MUST BE OBTAINED BY A LAKE COUNTY LICENSED INSTALLER BEFORE INSTALLATION.

- A. To be brought up to grade STREET - 60'
1. Septic tank manhole covers
2. Splitter box cover
3. Distribution box cover
- LOW YIELD WATER FIXTURES REQUIRED ON ALL:
Shower Head
Toilet
- B. No footer drains or downspouts to be discharged into septic tanks
C. All waste water to be discharged into septic tanks

Reviewed and Accepted
LAKE COUNTY GENERAL HEALTH DISTRICT
Date 6/10/95
JOEL LUCIA, R.S.M.P.H.
Health Commissioner
BY J. Lucia