




Notes:  
See "Lighting Layout" sheets for direction and placement of conduits out of foundation.  
Spacing and placement of anchor bolts in foundation is dependent upon the enclosure manufacturer's dimensions.  
Enclosure dimensions are inside measurements.

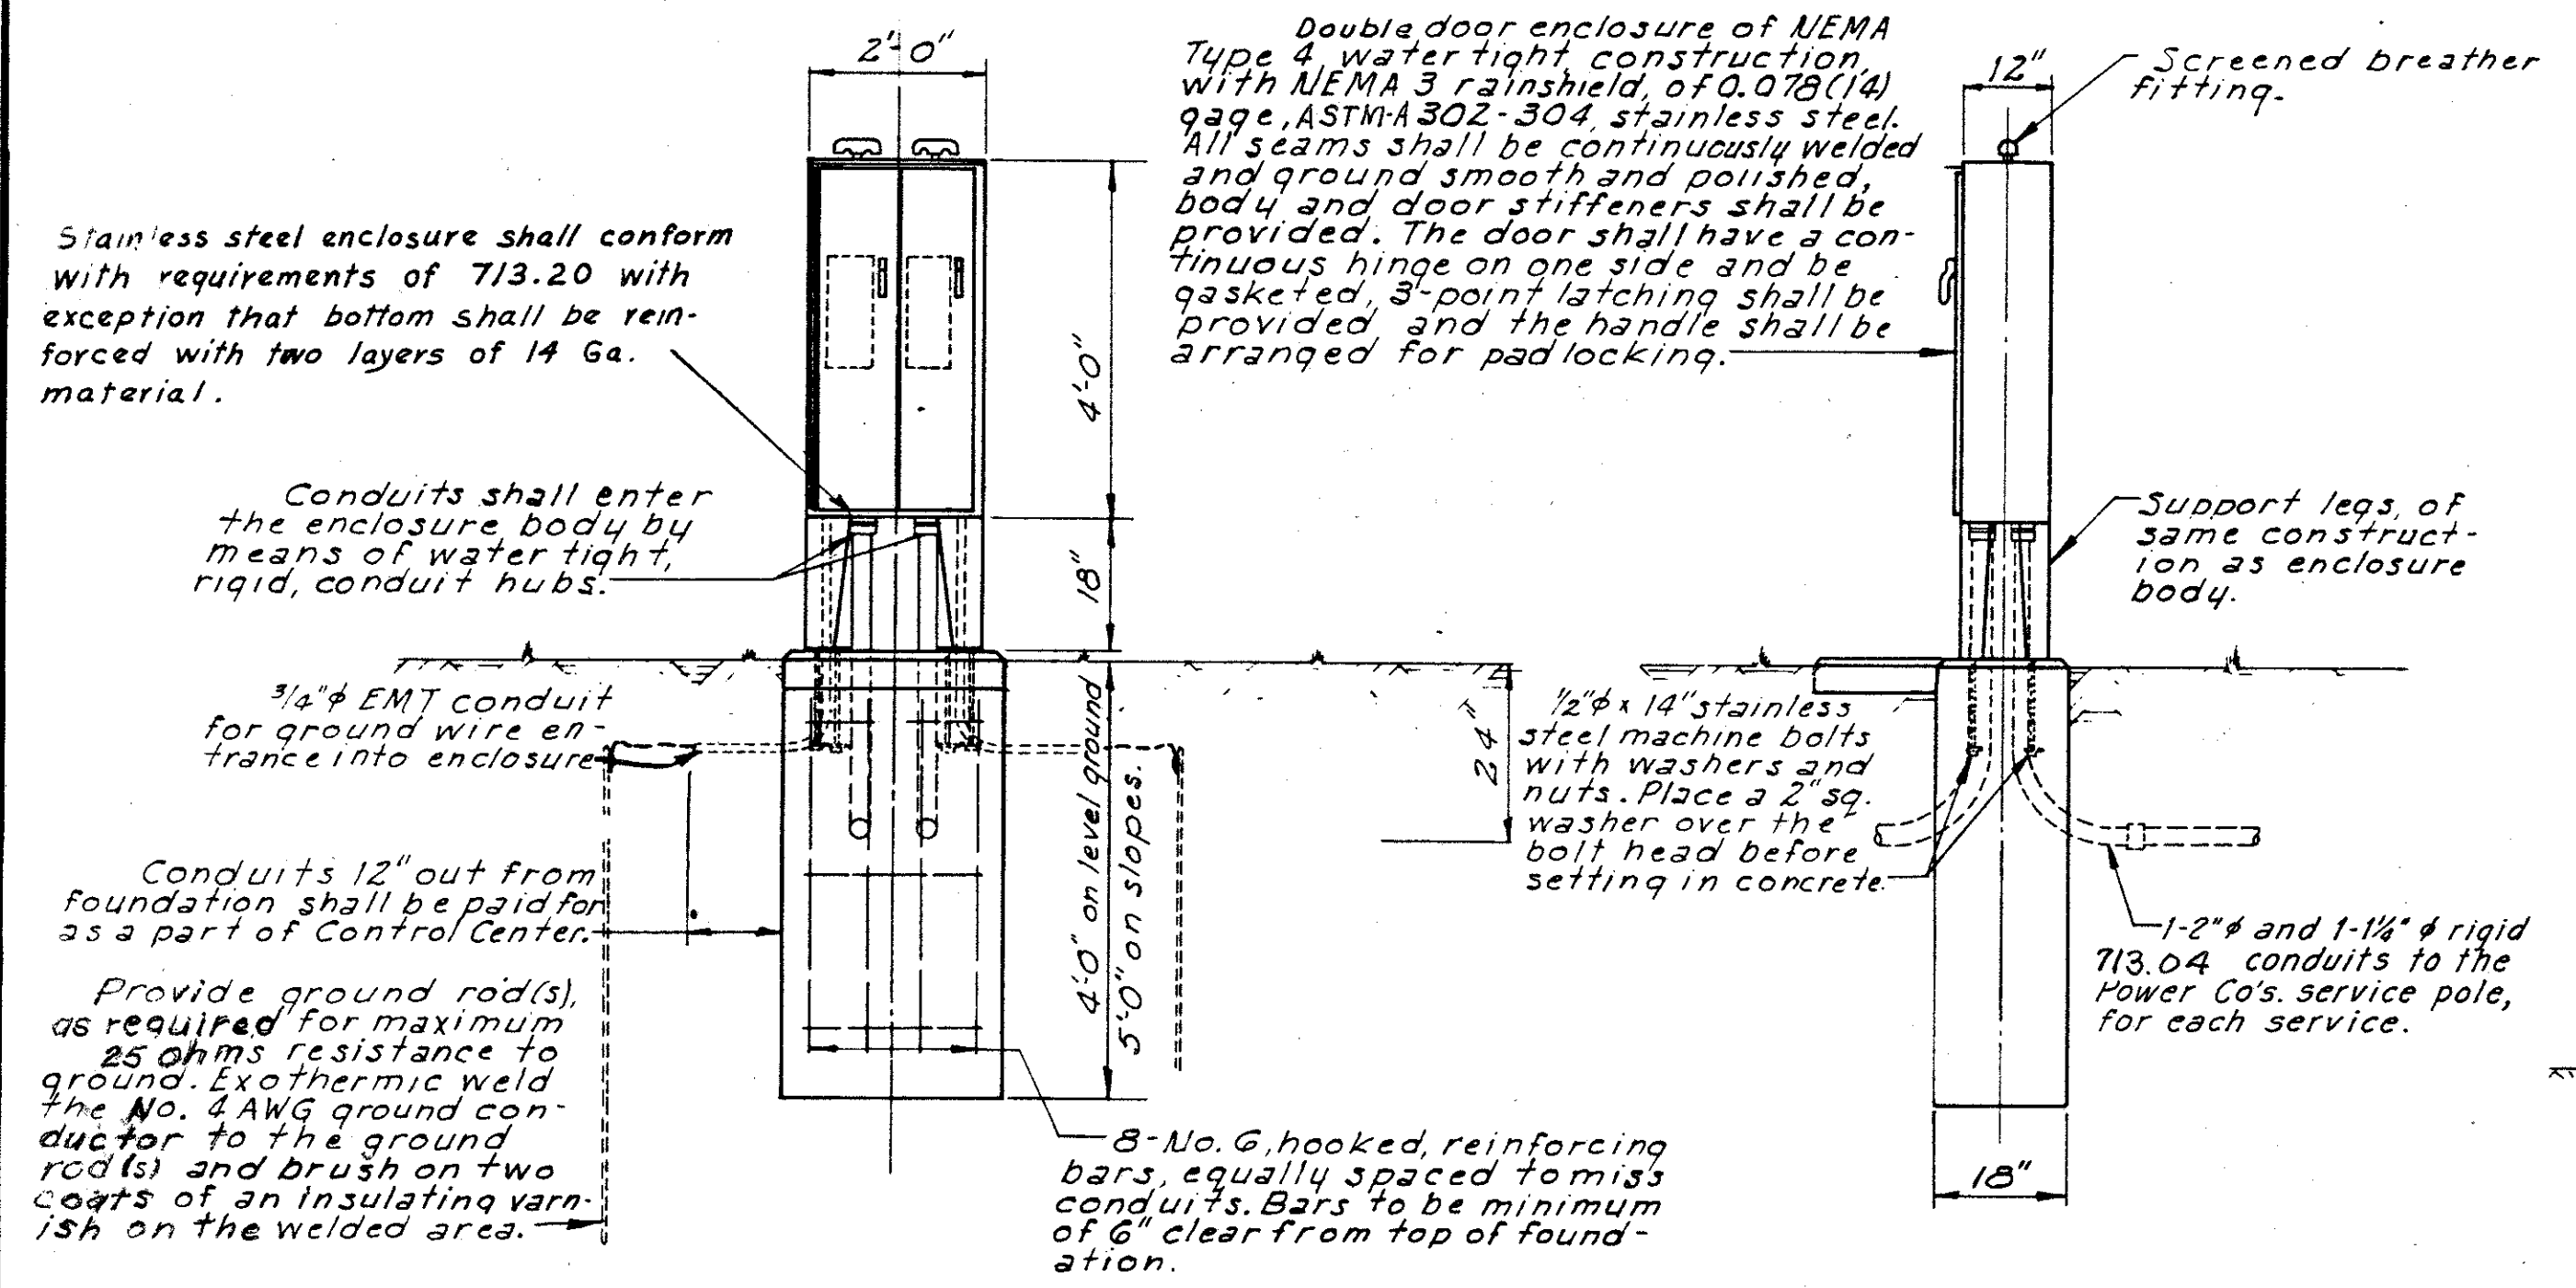

CONTROL CENTER DETAILS  
Scale: 1/2" = 1'-0"

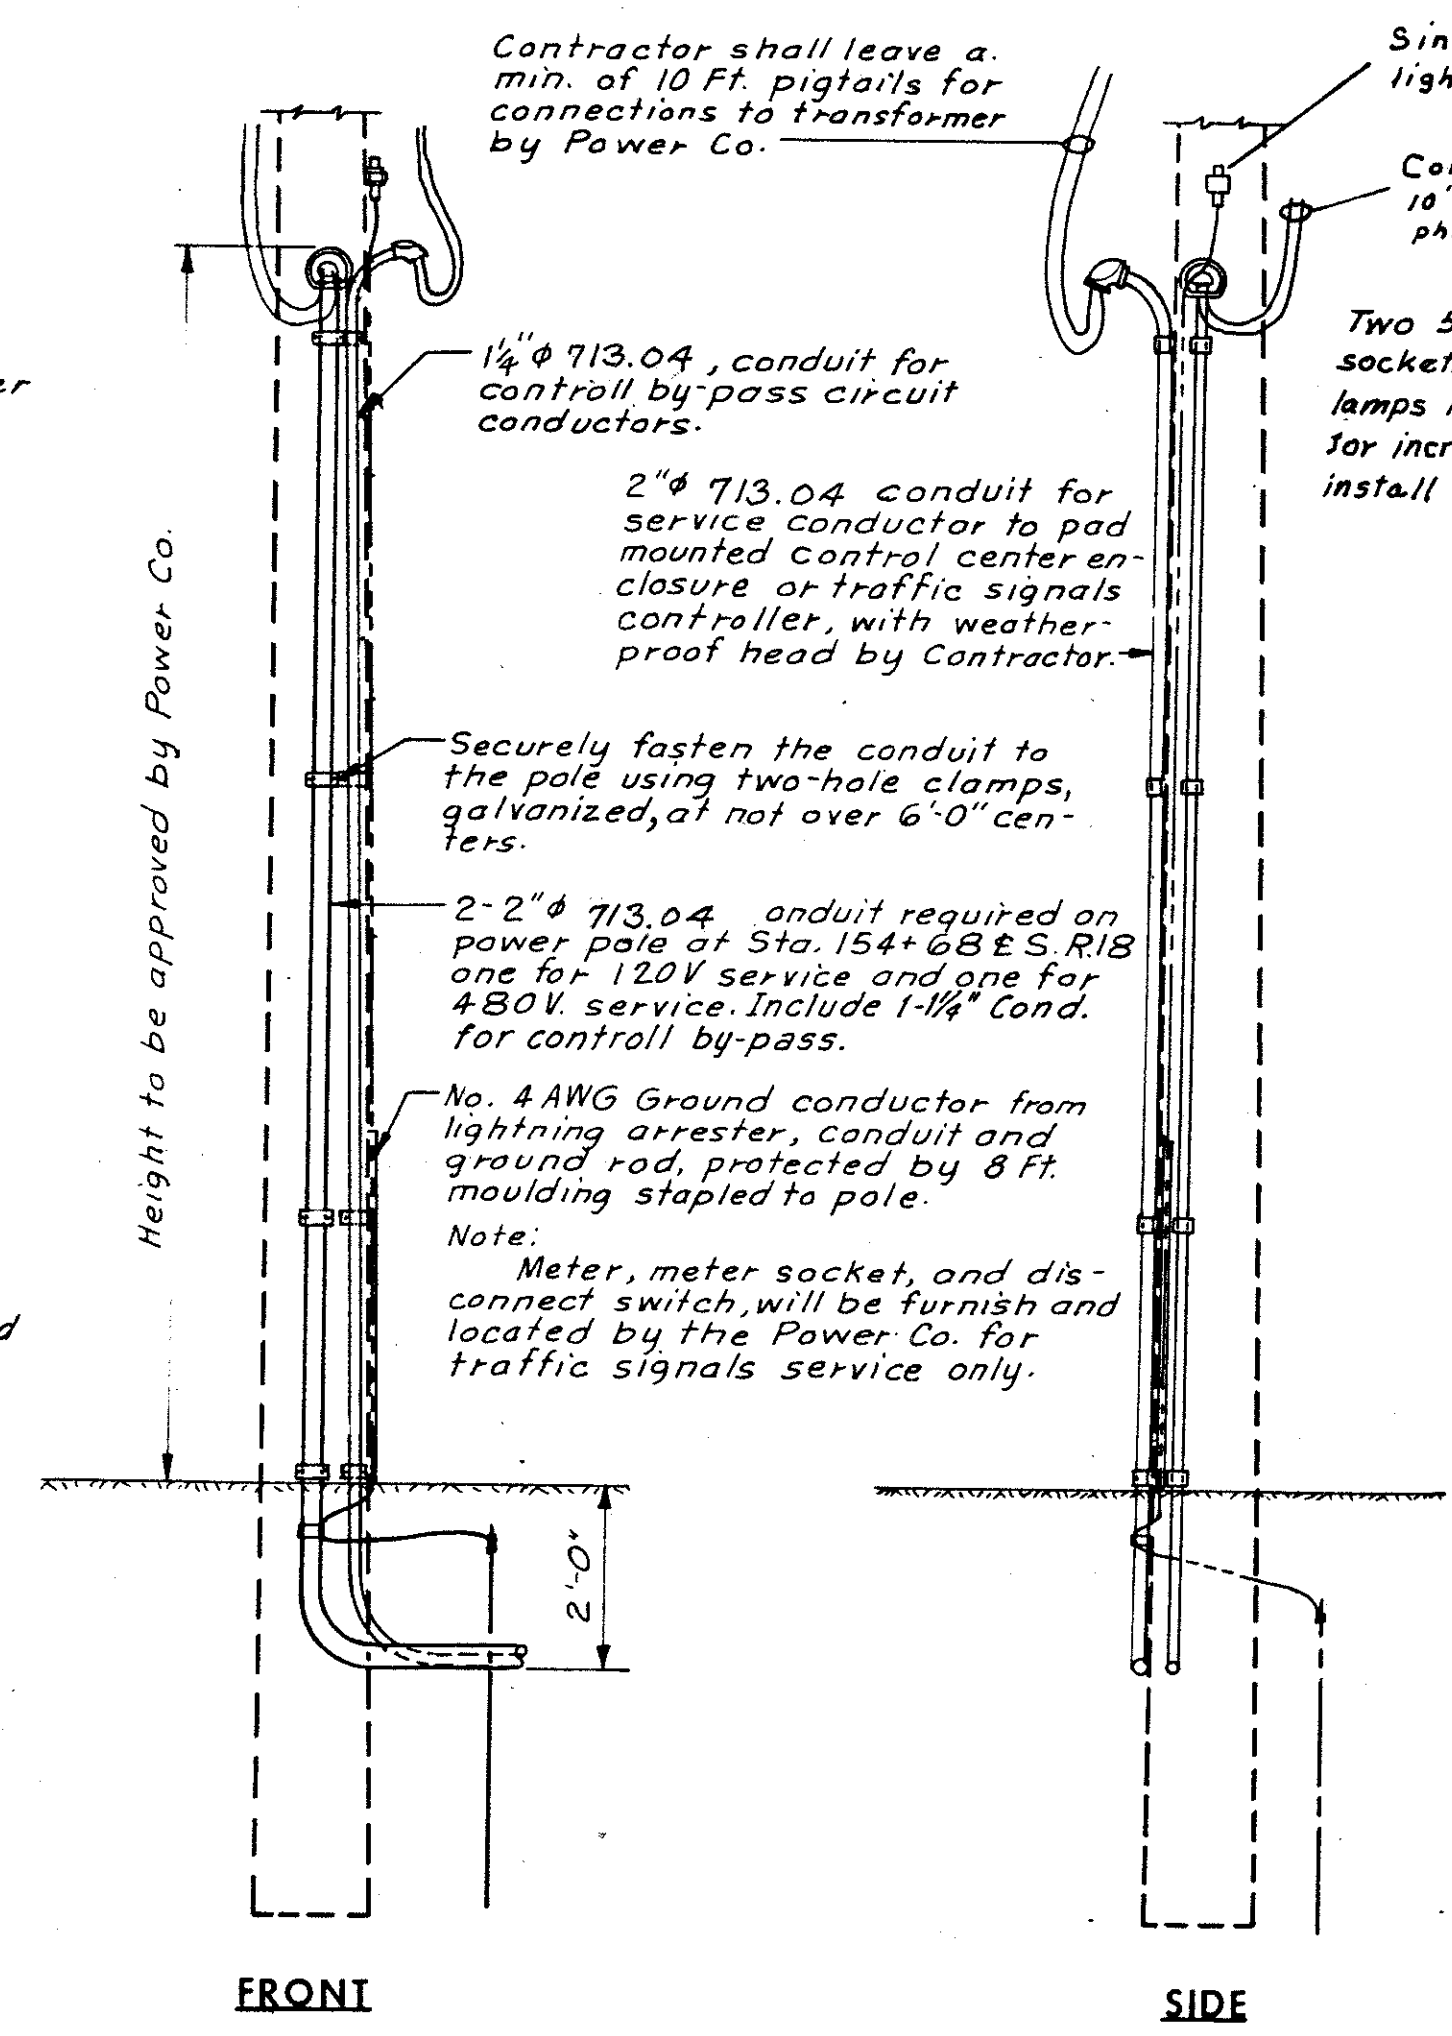

ELECTRICAL SERVICE POWER POLE DETAIL  
No Scale

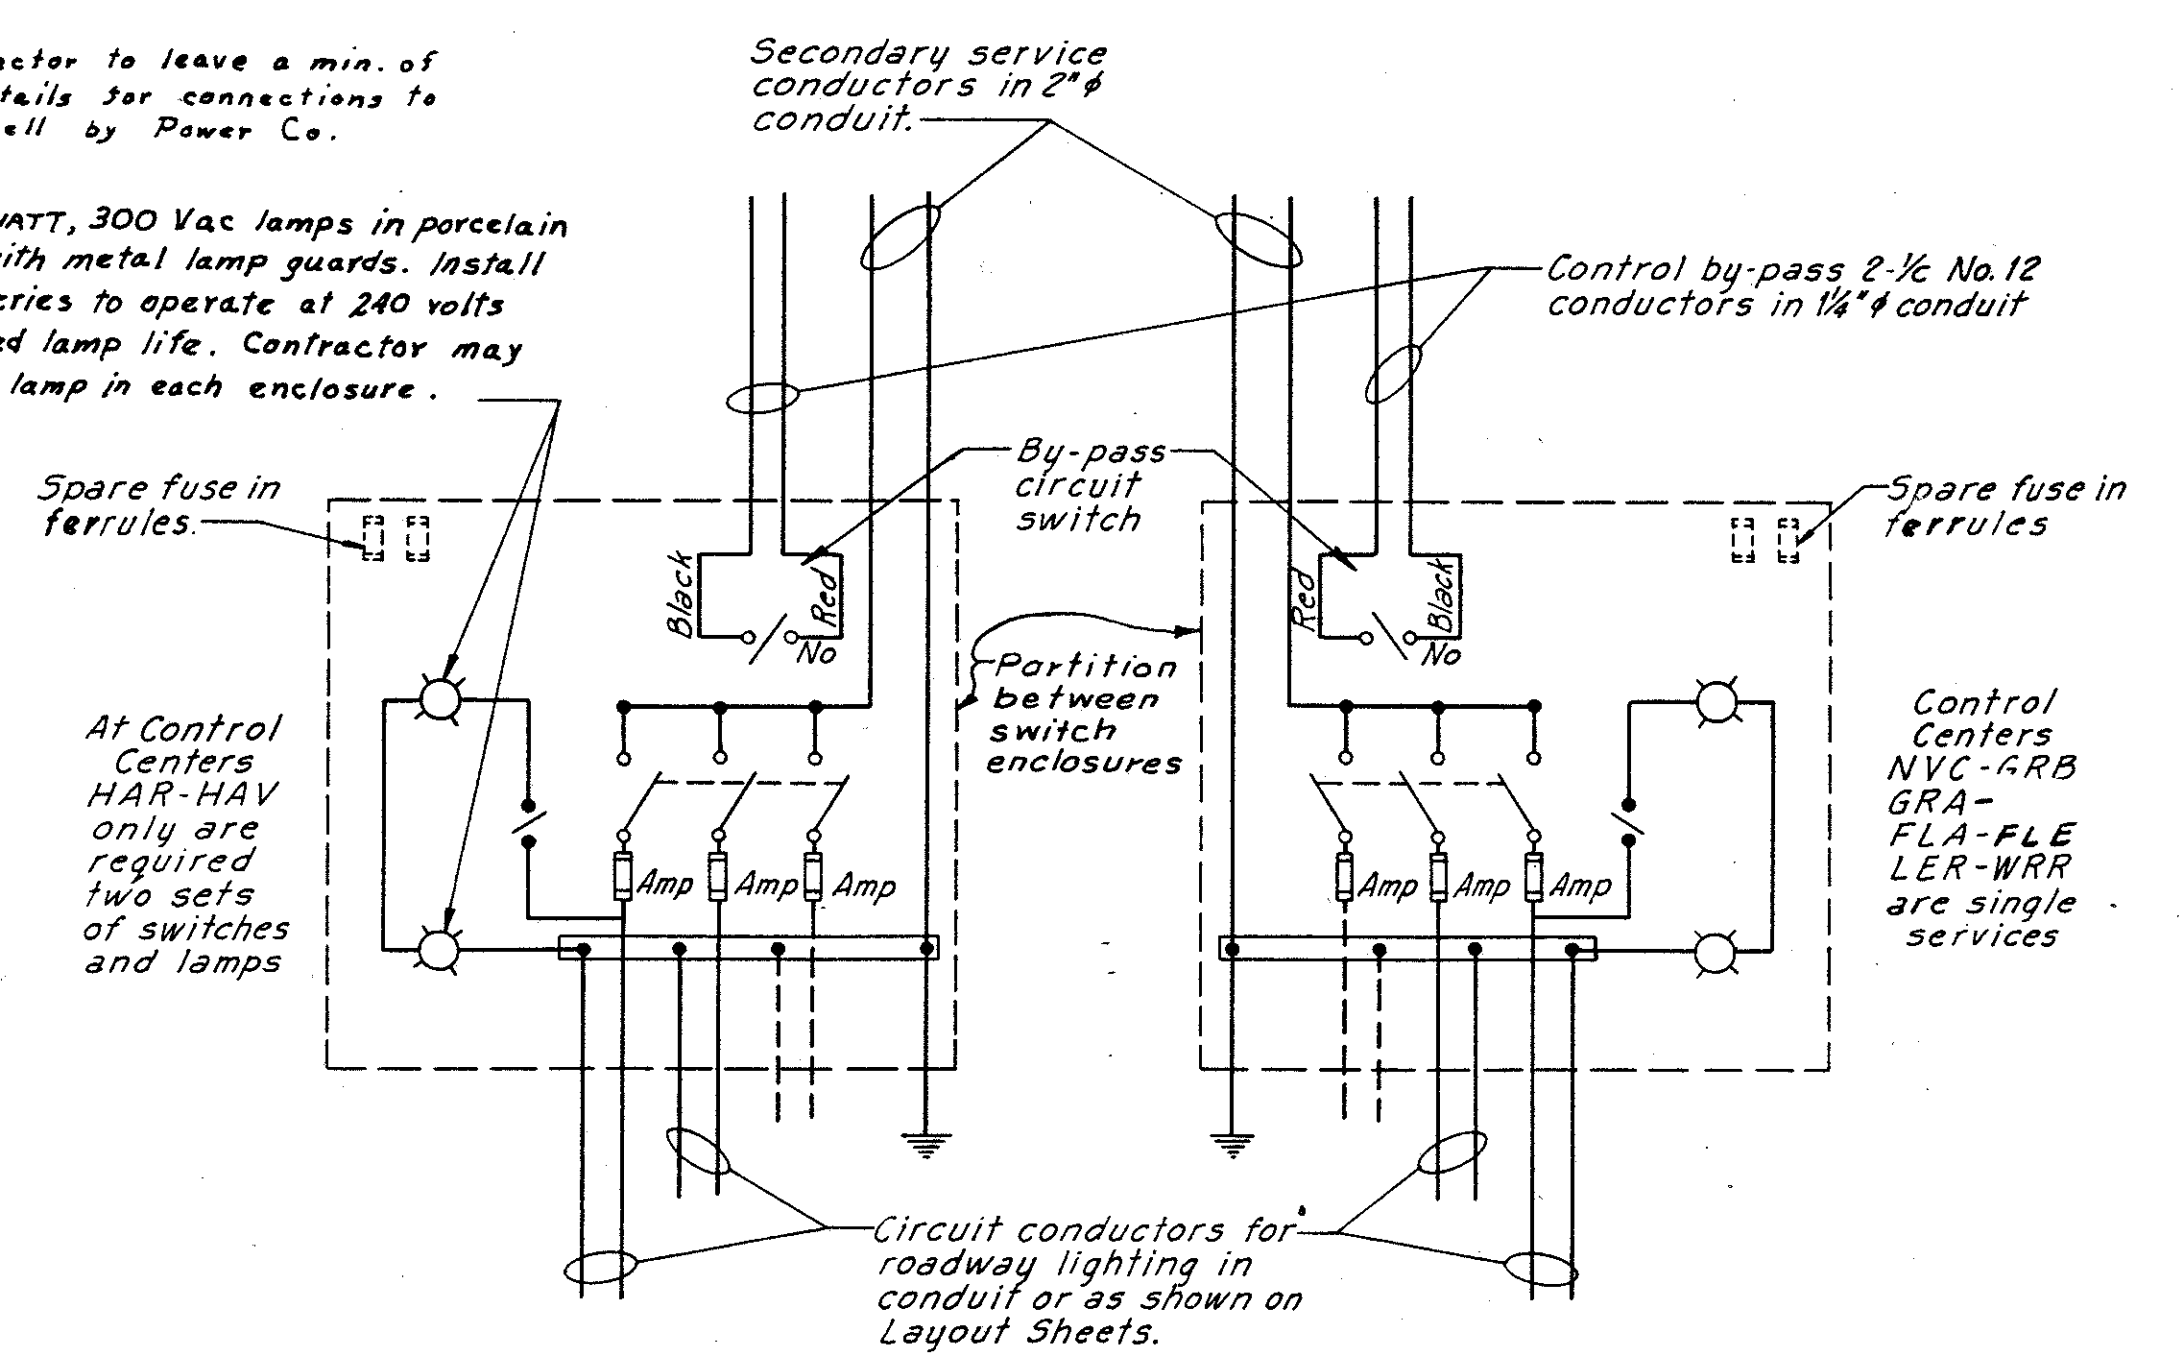

TYPICAL WIRING DIAGRAM IN CONTROL CENTER ENCLOSURE