

QUANTITY CALCULATIONS  
 BY: J.A.A. DATE 4/2/75  
 CHKD: B.C.D. DATE 4/2/75  
 COLPETZER - WOODS CONSULTANTS

602	603	603	604
CONCRETE MASONRY	15" CONDUIT TYPE "F"	15" CONDUIT TYPE "F" ENCASED	STANDARD No. 1 MANHOLE
C.Y.	L.F.	L.F.	EA.
	47	107	1
TOTALS	7.22	47	107



EROSION CONTROL

659	659
SEEDING AND MULCHING	COMMERCIAL FERTILIZER
S.Y.	TONS
172	0.02

FED. RD. DIVISION	STATE	PROJECT	FISCAL YEAR
5	OHIO	STATE	

LAKE COUNTY  
LAK. 84-5.28

REF	LOCATION	C.Y.	L.F.	L.F.	EA.
D-1	206+75, 13.17' R.		47		
D-2	206+85, 50' R.				1
D-3	206+85, 50' R. TO 136.5' R.			107	
D-4	206+85, 64.5' R.	1.52			
D-5	206+85, 82.5' R.	1.78			
D-6	206+85, 100.5' R.	1.52			
D-7	206+85, 118.5' R.	1.20			
D-8	206+85, 136.5' R.	1.20			
TOTALS		7.22	47	107	1

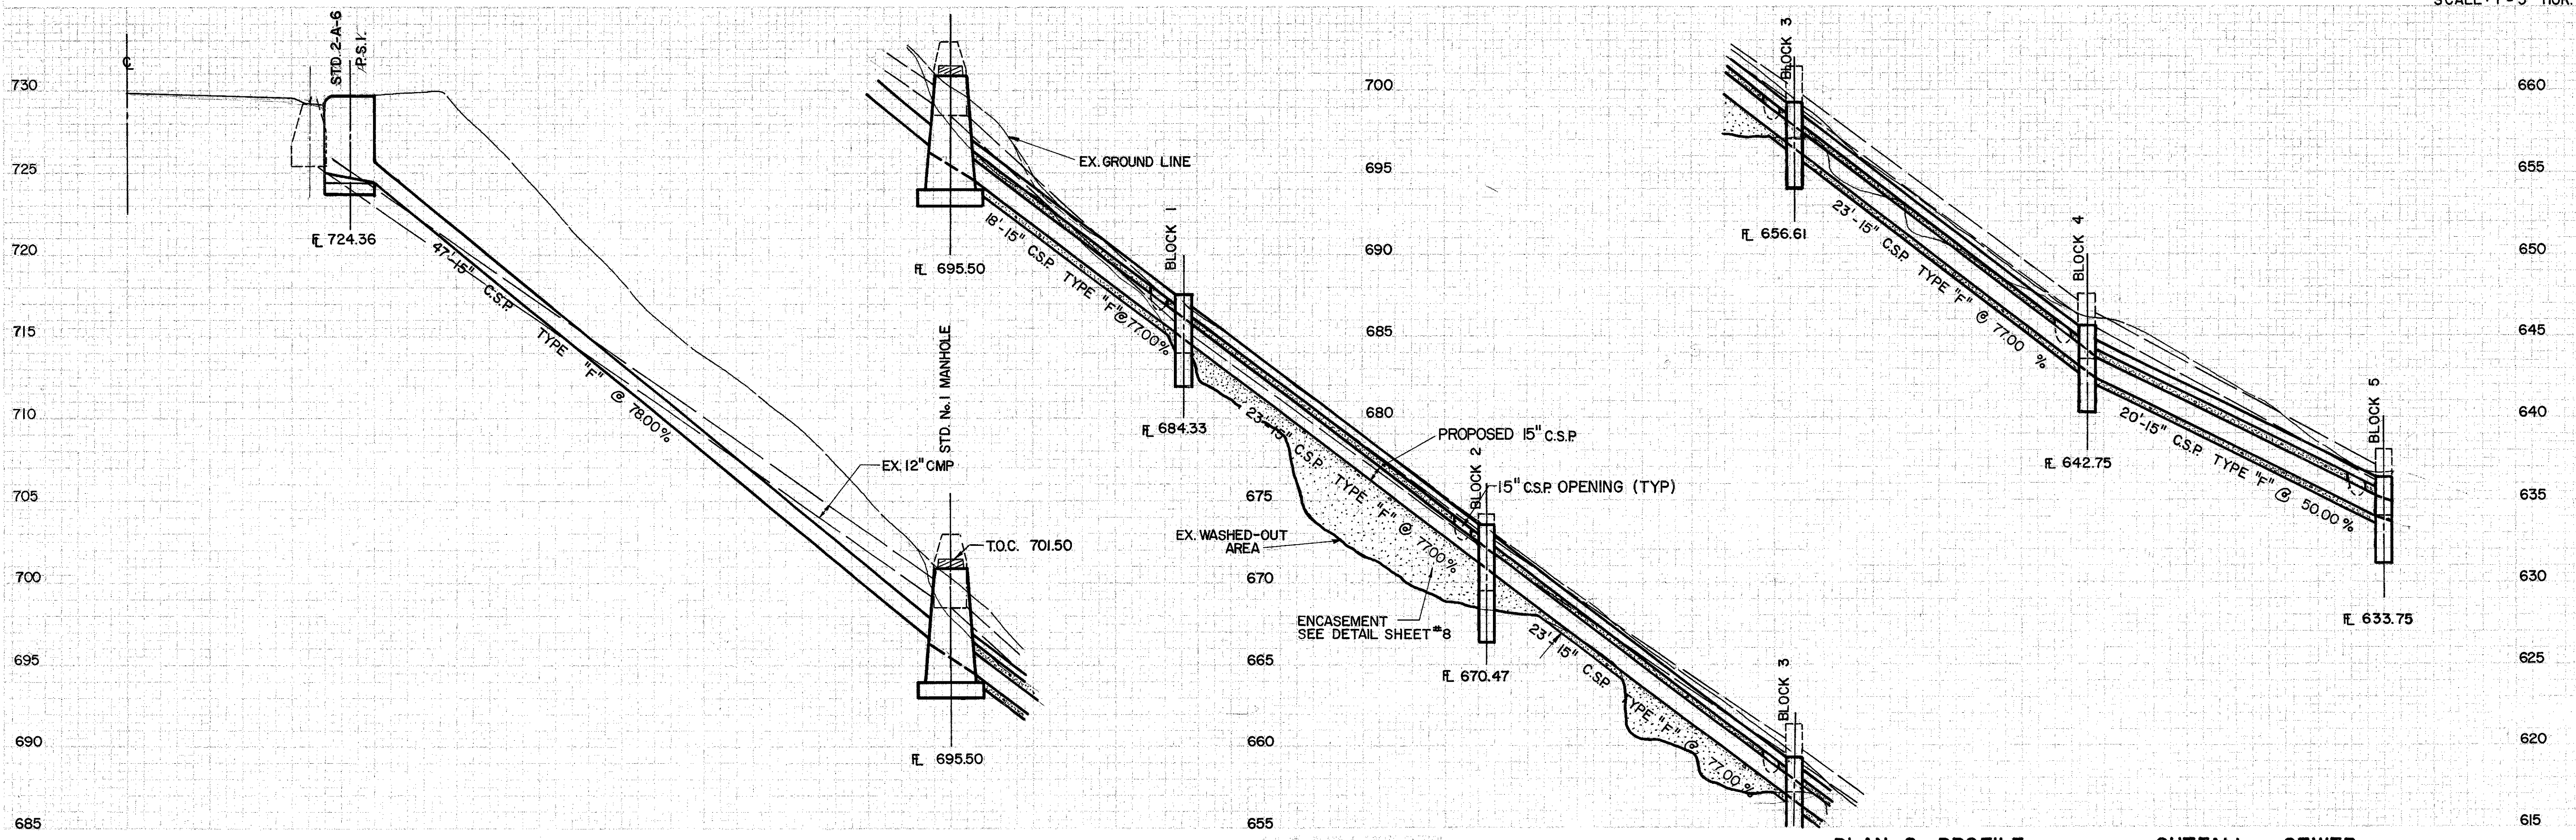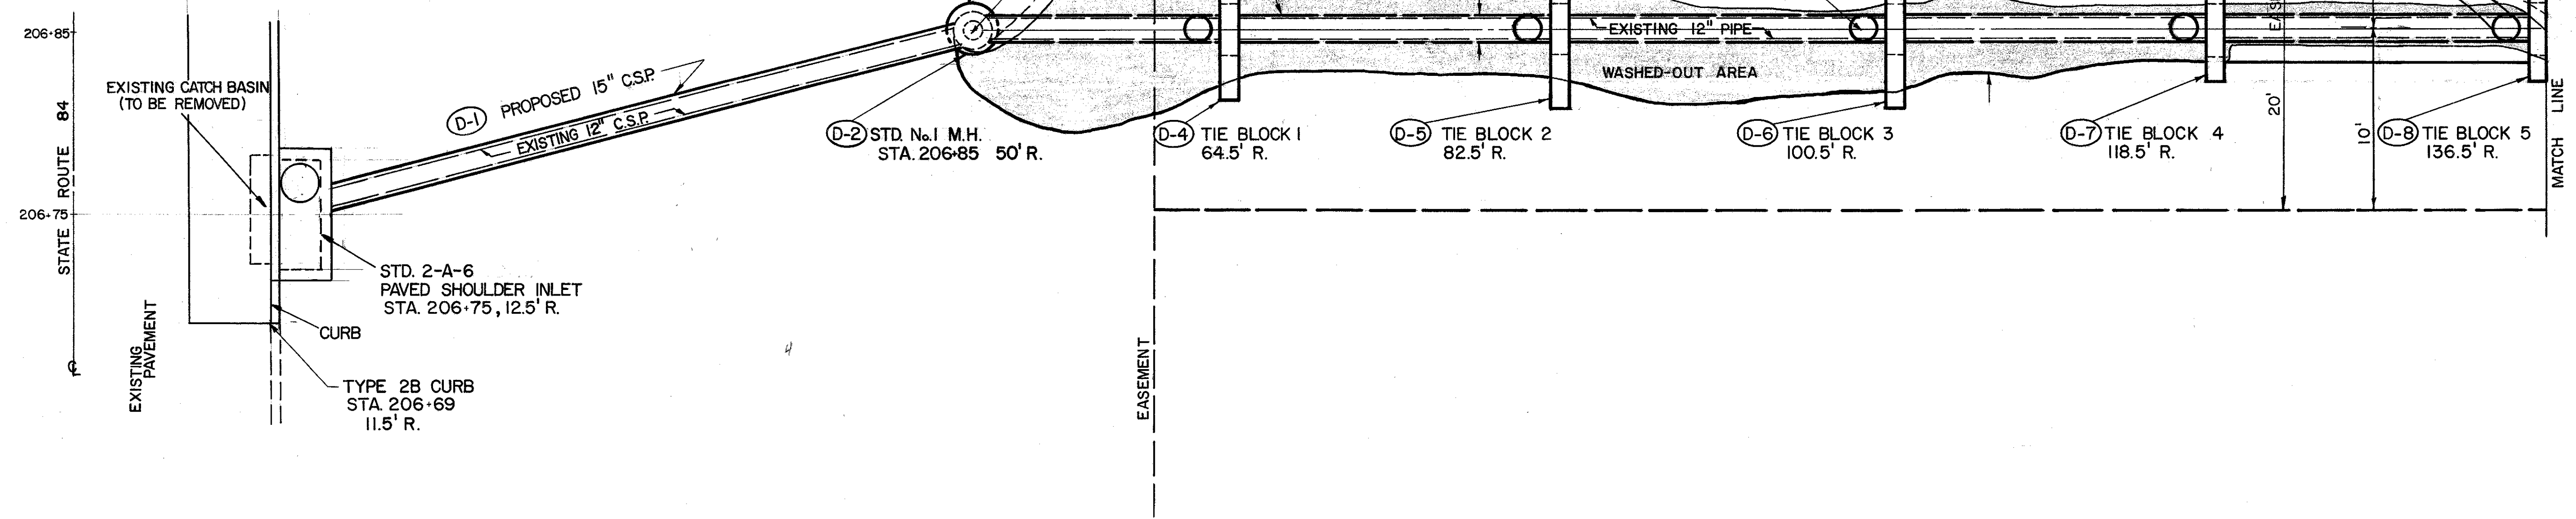

SCALE: 1"=5' HOR., 1"=5' VERT.

PLAN & PROFILE  
OUTFALL SEWER