



MICROFILMED
APR 21

LAKE COUNTY
LAK-306-6.15

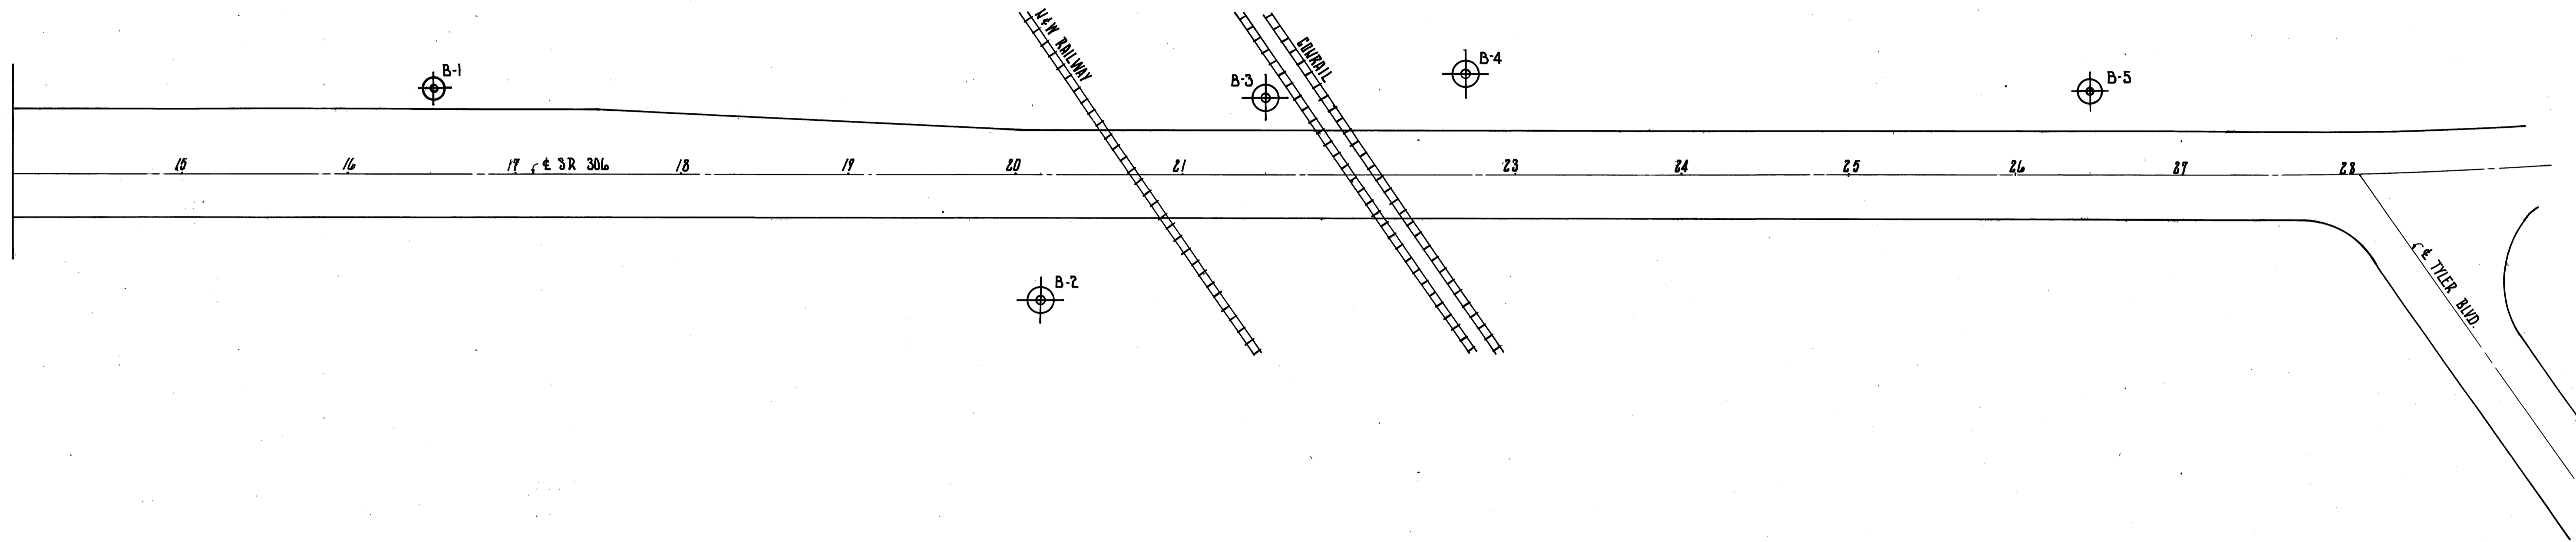

NOTE: FOR B-2, B-3, AND B-4 SEE SHEET 3.

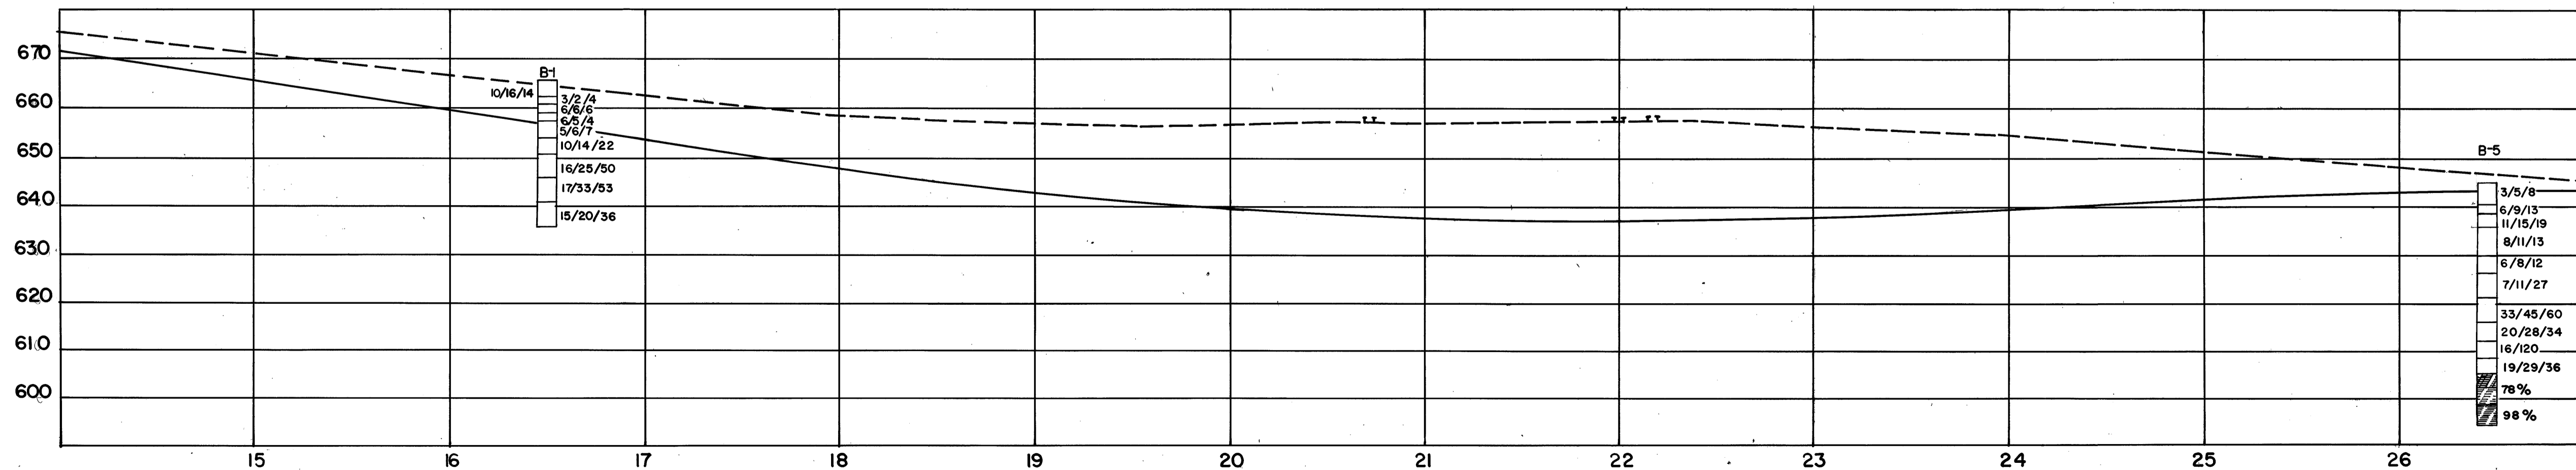

FRANKLIN CONSULTANTS INC.		COLUMBUS, OHIO		2 / 5	
Consulting Engineers					
STRUCTURE FOUNDATION INVESTIGATION PLAN AND PROFILE					
RETAINING WALL PUMP STATION					
DESIGNED	DRAWN	TRACED	CHECKED	REVIEWED	DATE
	R _c	R _c			

BRUNING 44-132-3045-1