



MAINTAINING TRAFFIC (EXIT RAMP)

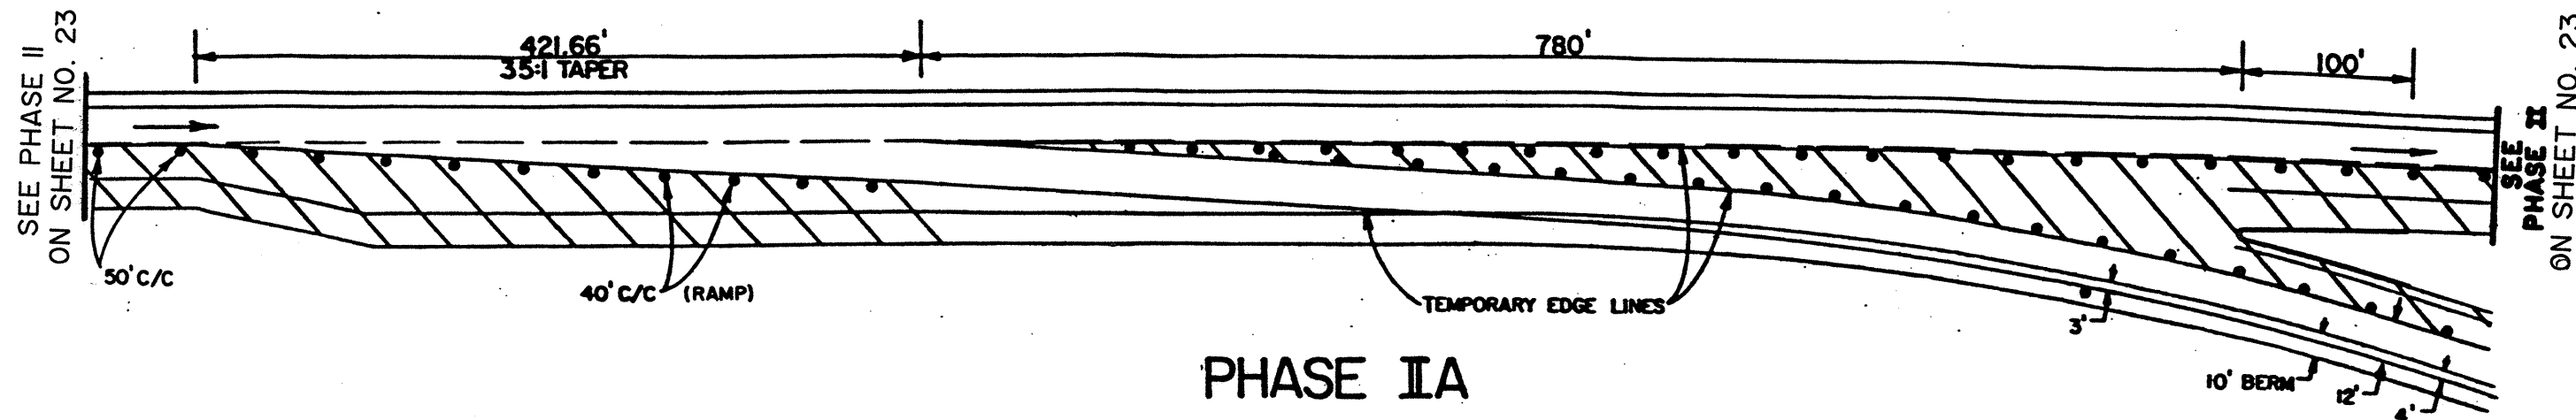

PHASE IA

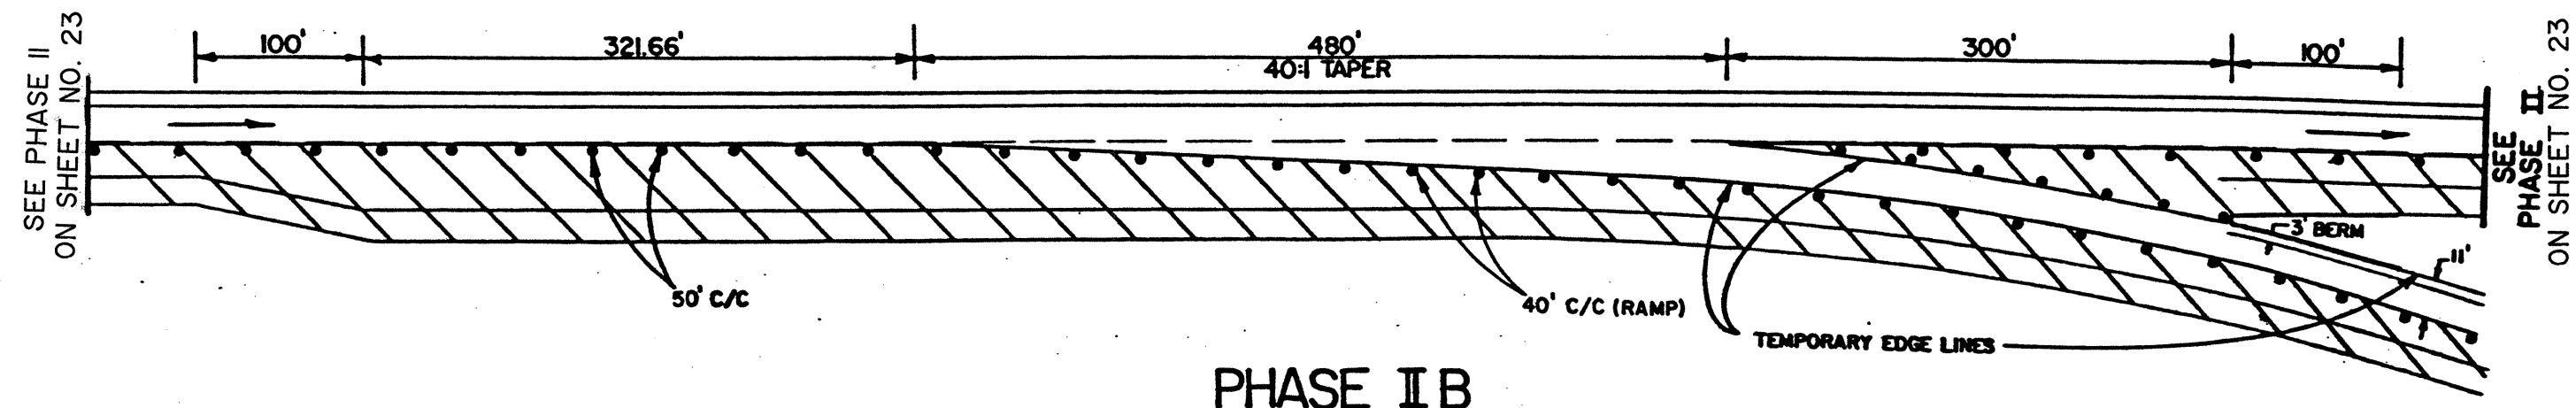

PHASE IB

THE ABOVE WORK SHALL BE PERFORMED DURING PHASE II

SEQUENCE OF OPERATIONS:

- 1 - COMPLETE PHASE IA
- 2 - COMPLETE PHASE IB

ALL CONFLICTING PAVEMENT MARKING SHALL BE REMOVED PRIOR TO ABOVE PHASES.

NOTE:
FOR ADVANCE WARNING SIGNS SEE SHEET NO. 22