
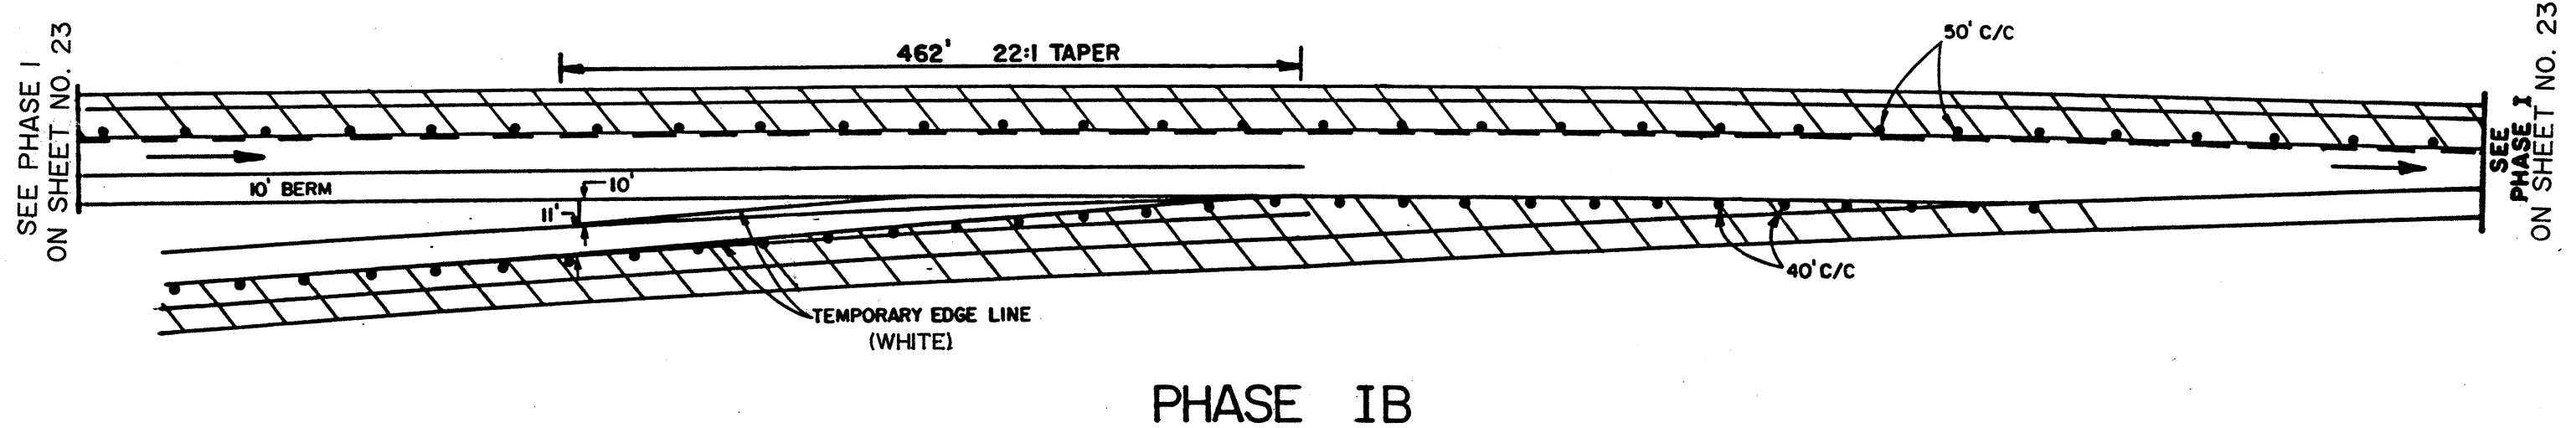


MAINTAINING TRAFFIC (ENTRANCE RAMP) EXCLUDING RAMP D

LAKE COUNTY
LAK-90-13.00

25
120

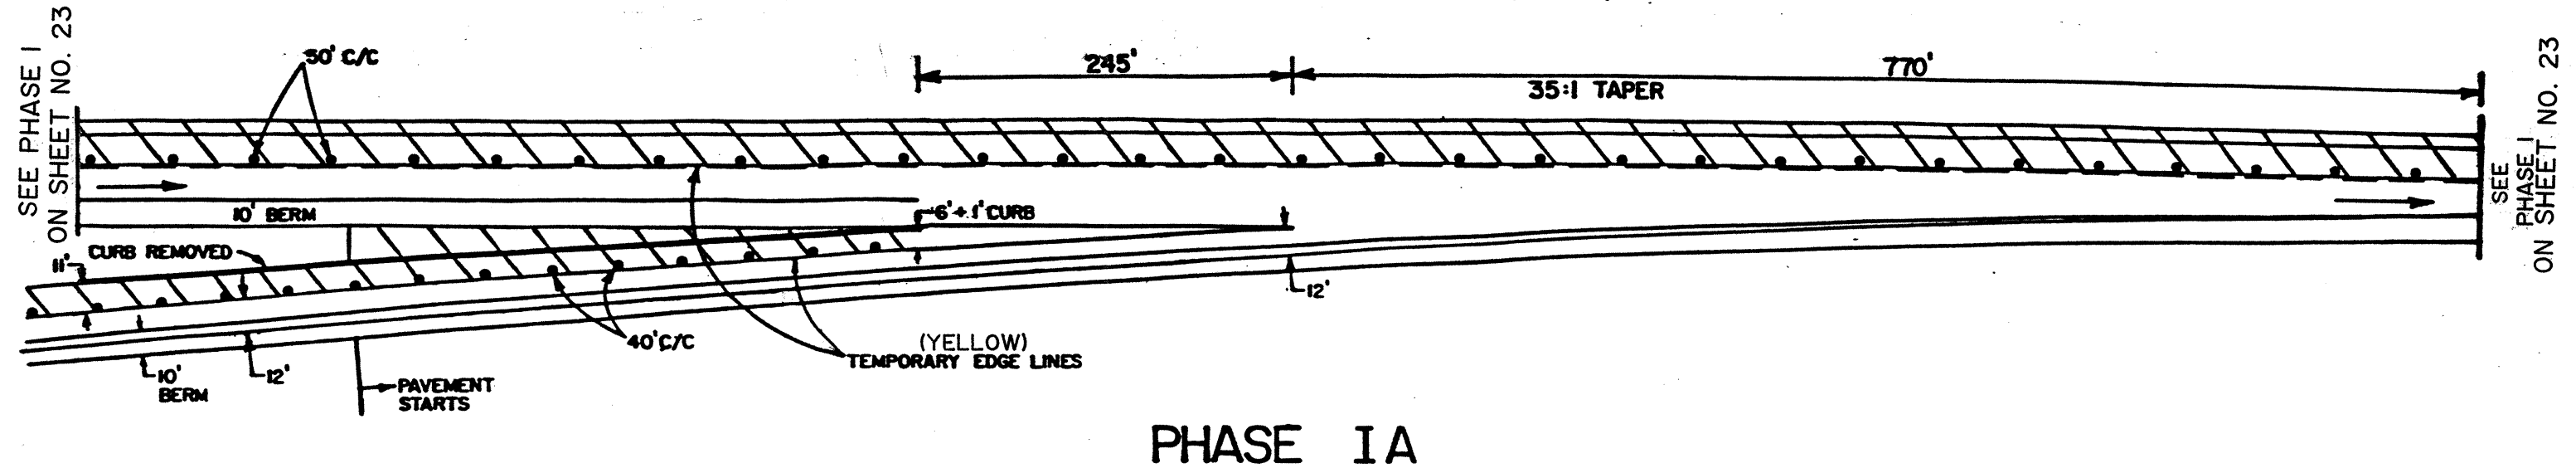

THE ABOVE WORK SHALL BE PERFORMED DURING PHASE I

SEQUENCE OF OPERATIONS:

- 1 - COMPLETE PHASE IA
- 2 - COMPLETE PHASE IB

ALL CONFLICTING PAVEMENT MARKING SHALL BE REMOVED PRIOR TO ABOVE PHASES.

NOTE:
FOR ADVANCE WARNING SIGNS SEE SHEET NO. 22