
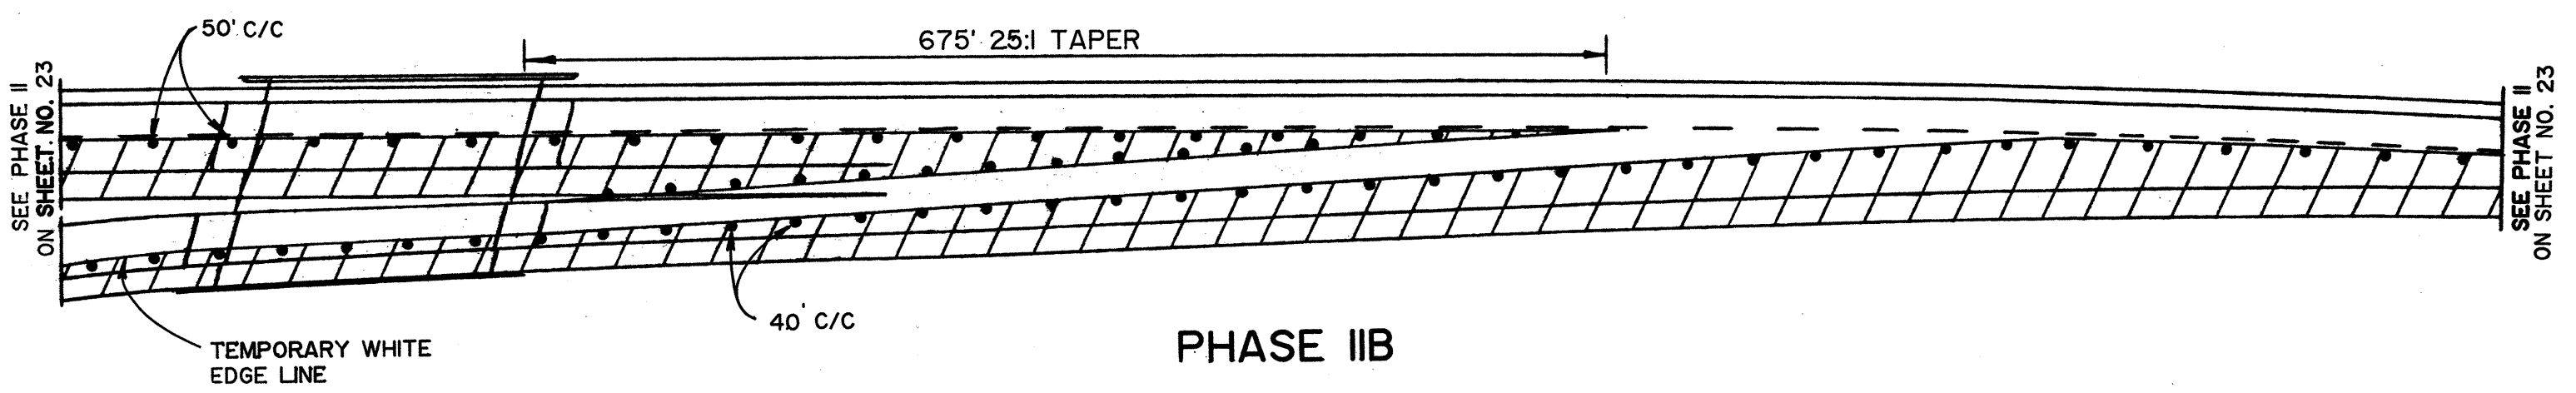


# MAINTAINING TRAFFIC (ENTRANCE RAMP) S.R. 44 INTERCHANGE RAMP D ONLY

LAKE COUNTY  
LAK-90-13.00

26  
120

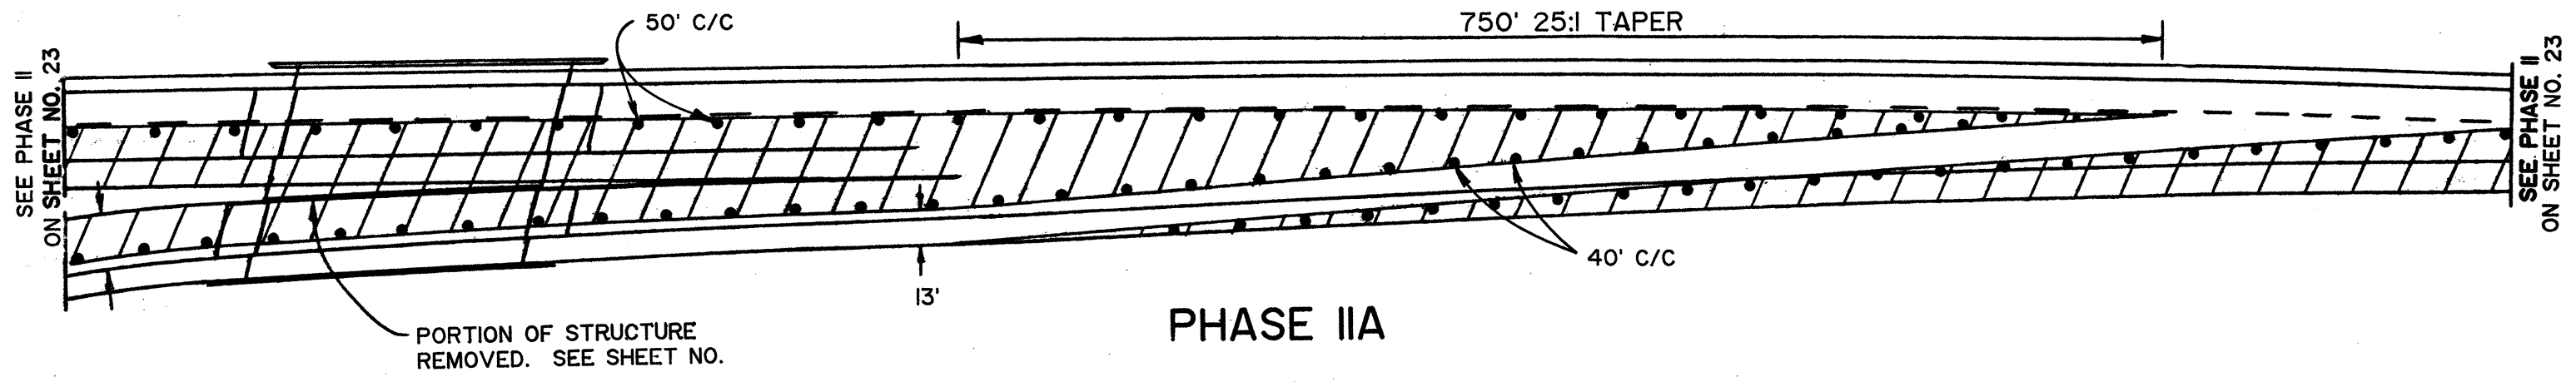

NOTE:  
FOR ADVANCE WARNING SIGNS SEE  
SHEET NO. 22

THE ABOVE WORK SHALL BE PERFORMED DURING PHASE II

- SEQUENCE OF OPERATIONS:
- 1 - COMPLETE PHASE IIA
  - 2 - COMPLETE PHASE IIB

**ALL CONFLICTING PAVEMENT MARKING SHALL BE  
REMOVED PRIOR TO ABOVE PHASES.**