
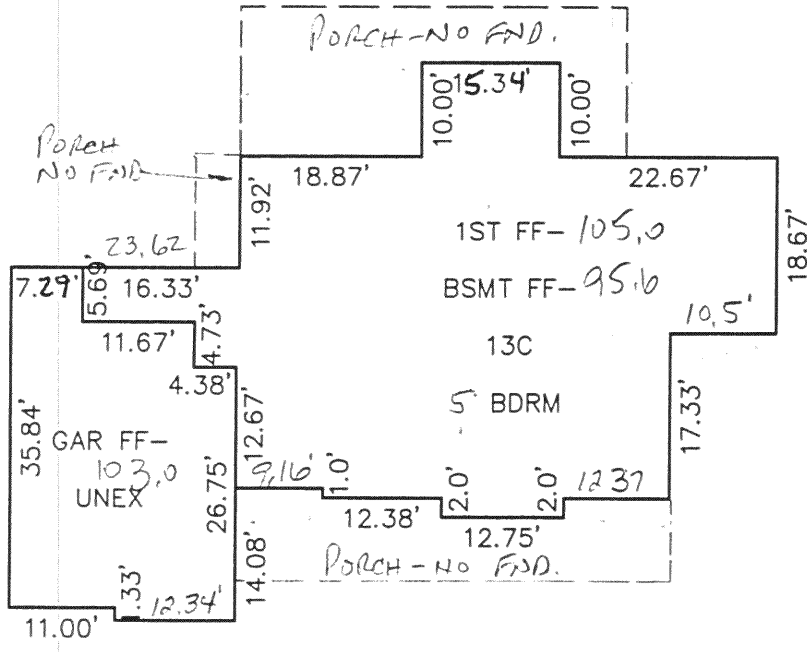


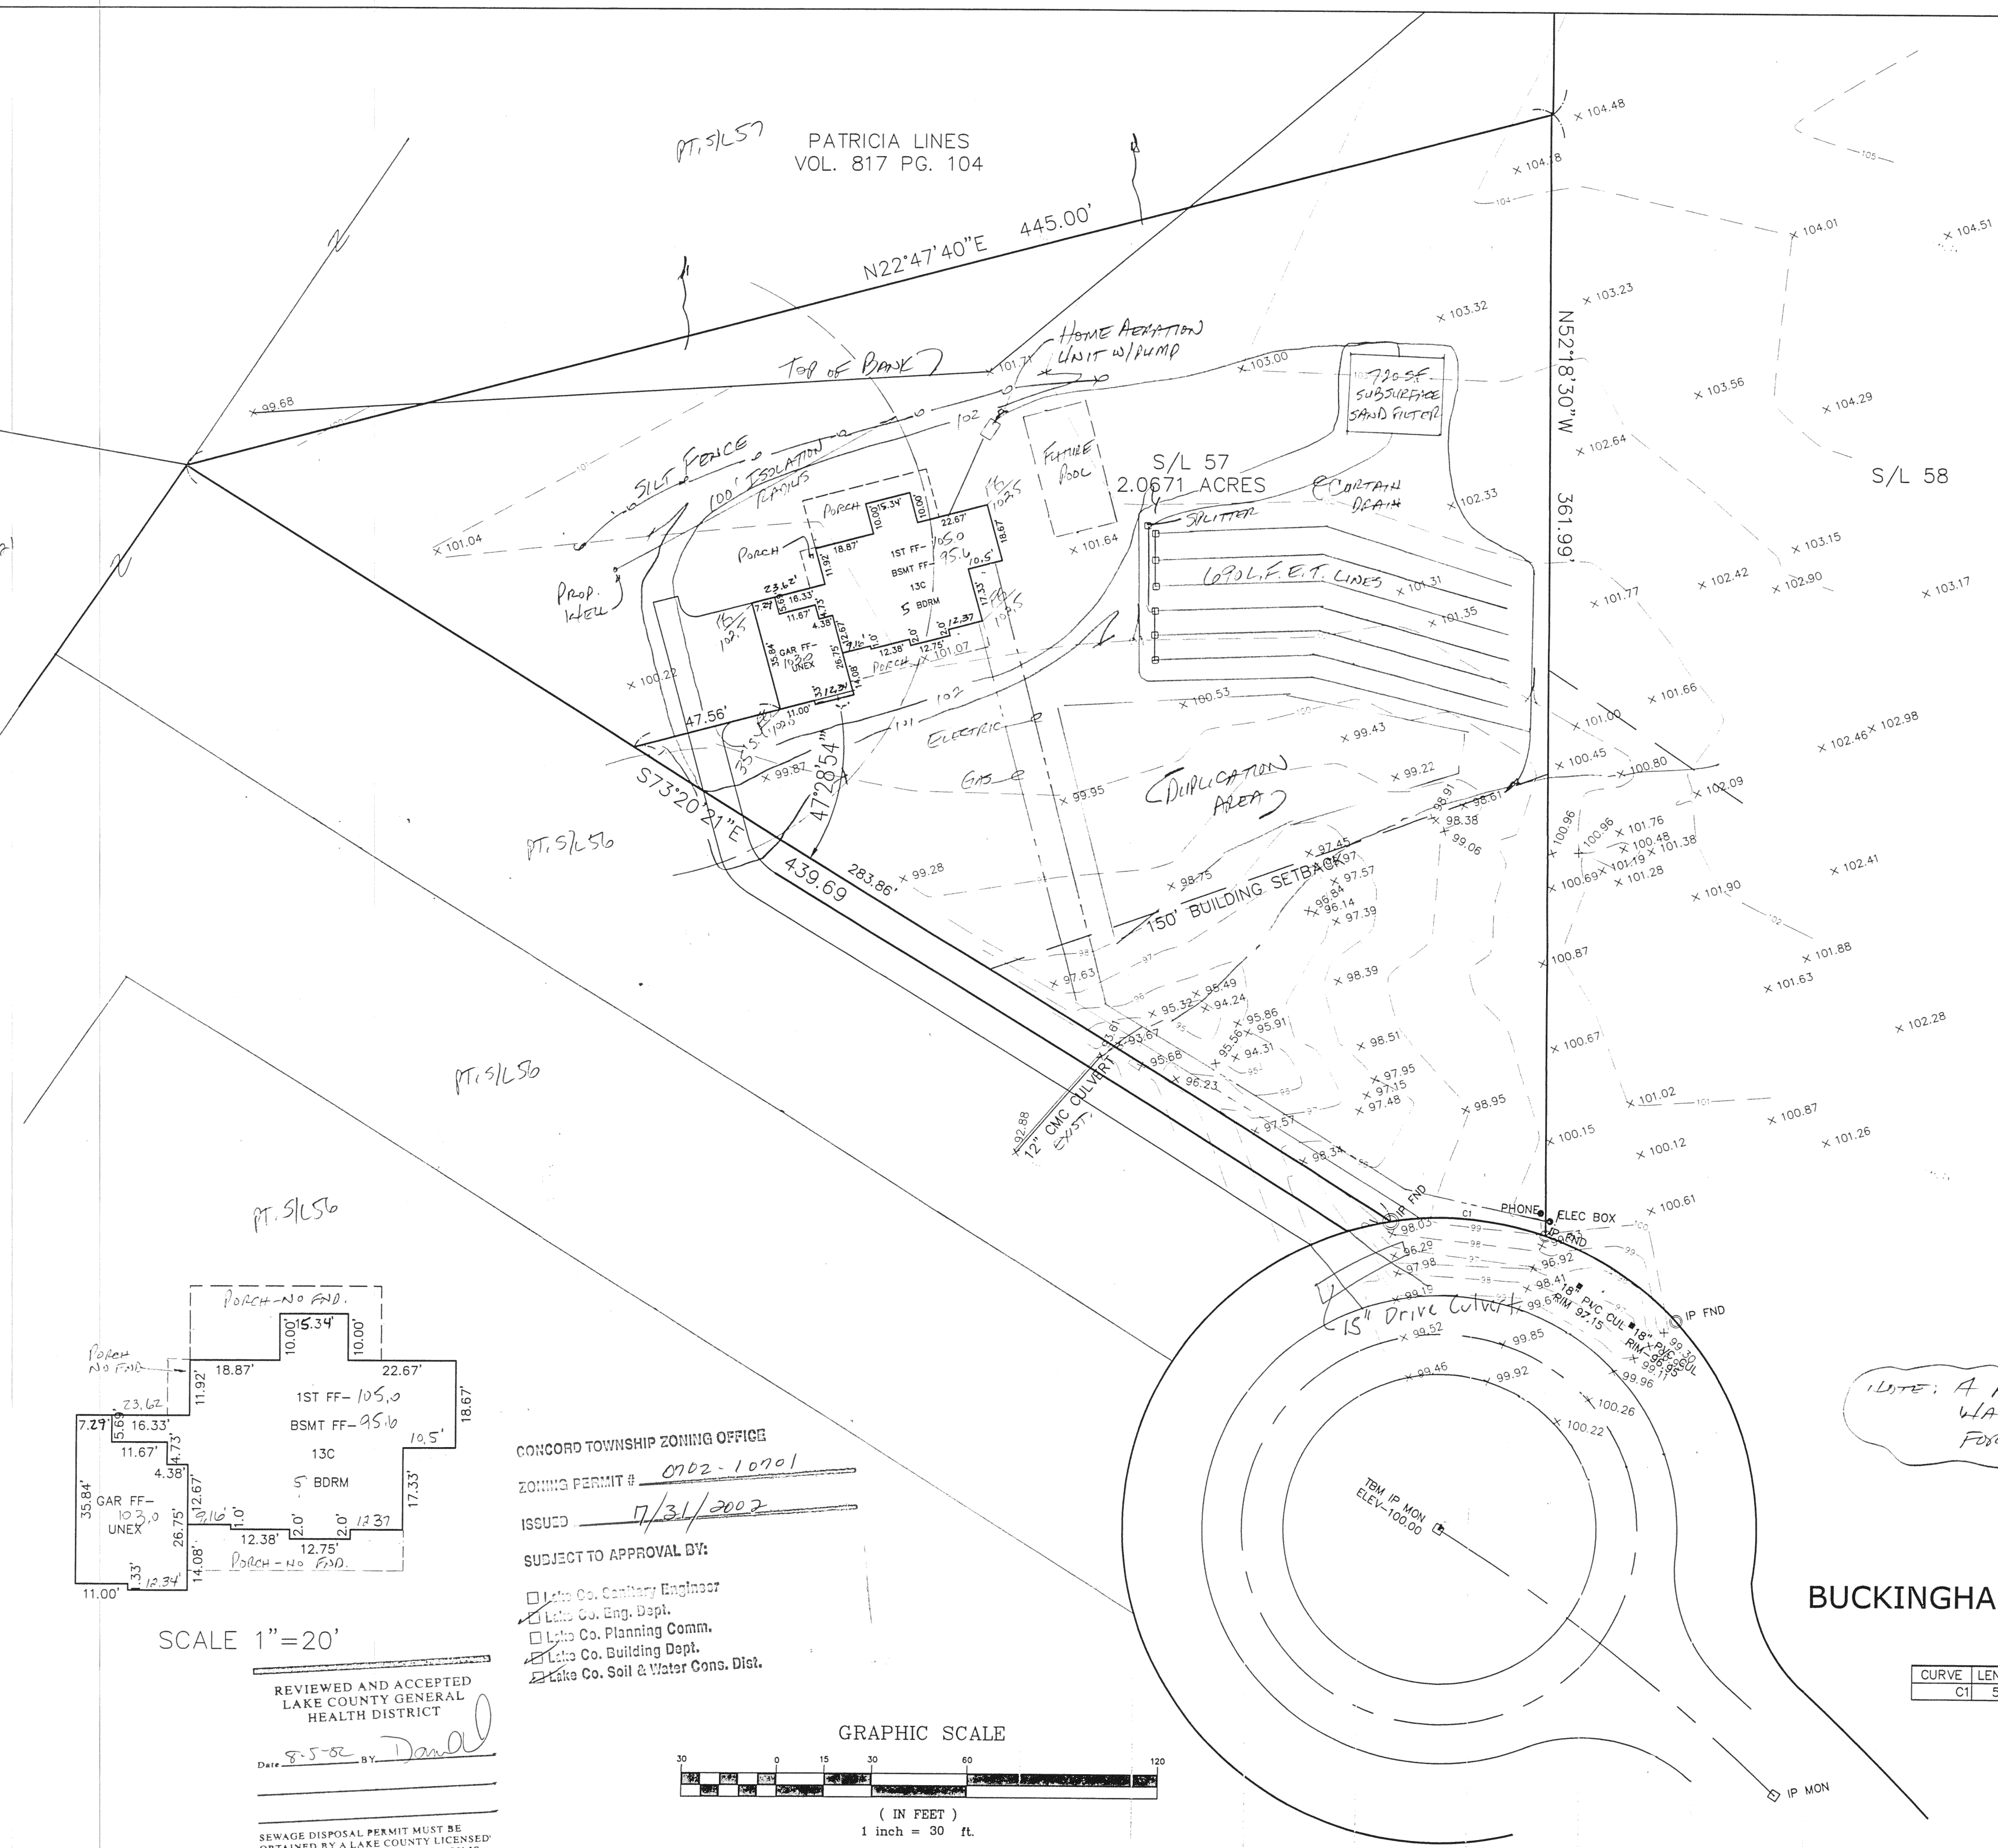

SCALE 1"=20'


REVIEWED AND ACCEPTED
LAKE COUNTY GENERAL
HEALTH DISTRICT

Date 8-5-02 BY: [Signature]

SEWAGE DISPOSAL PERMIT MUST BE
OBTAINED BY A LAKE COUNTY LICENSED
INSTALLER BEFORE INSTALLATION IS
STARTED.

CONCORD TOWNSHIP ZONING OFFICE
ZONING PERMIT # 0702-10701
ISSUED 7/31/2002
SUBJECT TO APPROVAL BY:




- ☐ Lake Co. Sanitary Engineer
- ☒ Lake Co. Eng. Dept.
- ☐ Lake Co. Planning Comm.
- ☒ Lake Co. Building Dept.
- ☒ Lake Co. Soil & Water Cons. Dist.

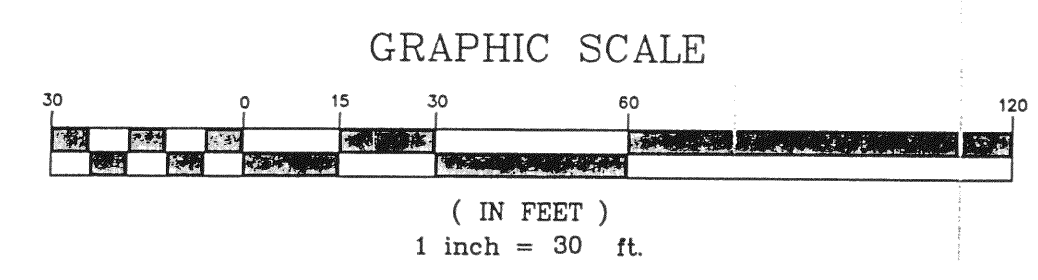

BUCKINGHAM PLACE - 60'

CURVE	LENGTH	RADIUS	TANGENT	CHORD	BEARING	DELTA
C1	50.00	100.00	25.53	49.48	S42°34'19"W	28°38'52"

EXISTING UTILITIES NOTE:
THE SIZE AND LOCATION, BOTH HORIZONTAL AND VERTICAL
OF THE UNDERGROUND UTILITIES SHOWN HEREON, HAVE BEEN
OBTAINED BY A SEARCH OF AVAILABLE RECORDS.
VERIFICATION BY FIELD OBSERVATION HAS BEEN CONDUCTED
WHERE PRACTICAL. HOWEVER, BABCOCK, JONES AND ASSOCIATES
INC. DOES NOT GUARANTEE THE COMPLETENESS NOR ACCURACY
THEREOF.

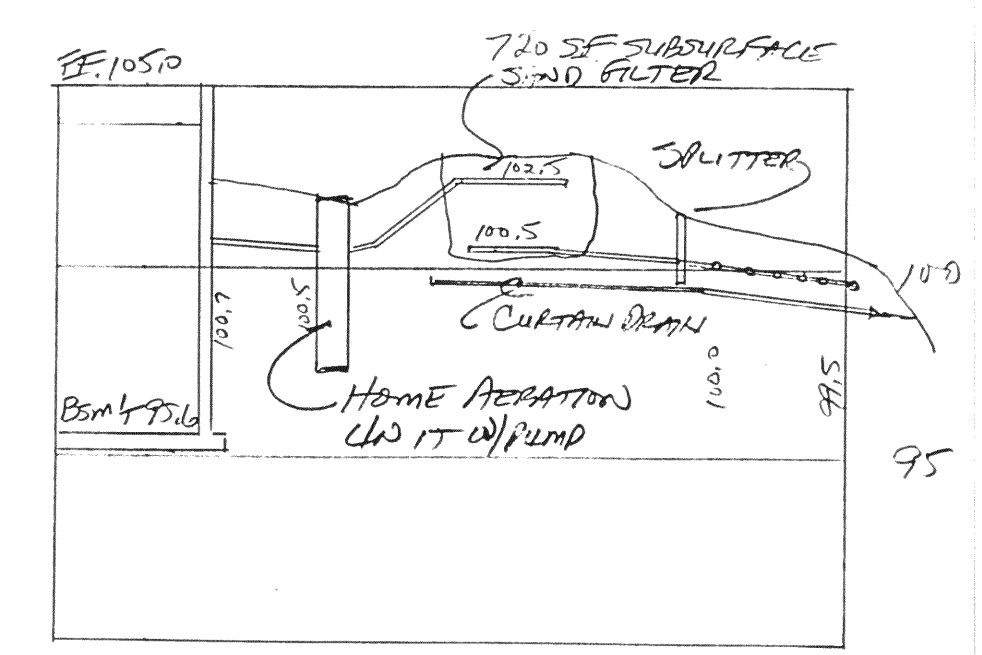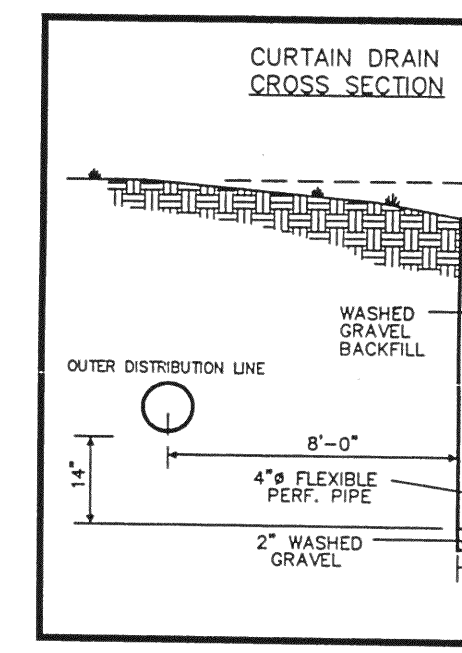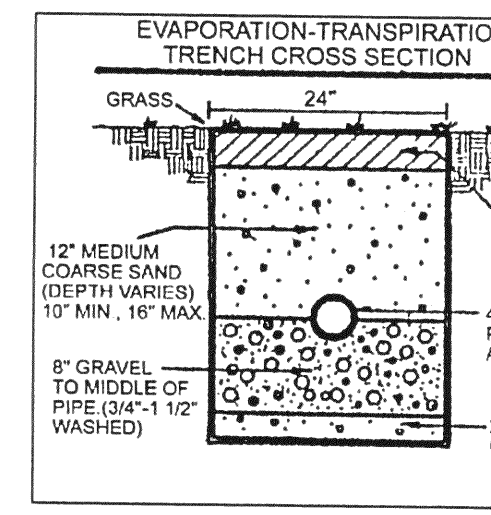

HYDRAULIC PROFILE
HORIZ: 1"=30' VERT: 1"=5'

NOTE: A POSSIBILITY OF CITY
WATER MAY BE AVAILABLE
FOR THIS LOT IN THE FUTURE.

"I, the undersigned hereby certify that this topography indicates contours, and elevations represent an actual survey made on the 13th day of [Month] 2002, and that the elevations are at appropriate intervals and date they existed as shown.

Name: [Signature]

DESCRIPTION	DATE	BY	CHK'D

BABCOCK, JONES AND ASSOCIATES, INC
CIVIL ENGINEERS - SURVEYORS - LAND PLANNERS
PAINESVILLE OHIO 44077

DATE 7/23/02
DESIGN BY HJ
DRAWN BY NS
APPROVED BY HJ

SITE PLAN
FOR
KERN BUILDERS

CONCORD TOWNSHIP LAKE COUNTY STATE OF OHIO