

ST. GABRIEL PARISH

SCHOOL ADDITION

MENTOR, OHIO
BISHOP OF CLEVELAND
REV. ROBERT E. PAHLER
MOST REV. JAMES A. HICKEY

INDEX OF DRAWINGS	
A-1	FIRST FLOOR PLAN, E.L. AND C.L. DETAILS
A-2	SECOND FLOOR PLAN, E.L. AND C.L. DETAILS
A-3	ROOF PLAN, E.L. AND C.L. DETAILS
A-4	SECTION THROUGH DOOR SCHEDULE AND DETAILS
A-5	SECTION THROUGH WINDOW SCHEDULE AND DETAILS
A-6	SECTION THROUGH WALL SCHEDULE AND DETAILS
A-7	SECTION THROUGH FLOOR SCHEDULE AND DETAILS
A-8	SECTION THROUGH CEILING SCHEDULE AND DETAILS
A-9	SECTION THROUGH ROOF SCHEDULE AND DETAILS
A-10	SECTION THROUGH FOUNDATION SCHEDULE AND DETAILS
A-11	SECTION THROUGH BASE SCHEDULE AND DETAILS
A-12	SECTION THROUGH SILL SCHEDULE AND DETAILS
A-13	SECTION THROUGH CASE SCHEDULE AND DETAILS
A-14	SECTION THROUGH PANEL SCHEDULE AND DETAILS
A-15	SECTION THROUGH STAIR SCHEDULE AND DETAILS
A-16	SECTION THROUGH ELEVATOR SCHEDULE AND DETAILS
A-17	SECTION THROUGH MECHANICAL SCHEDULE AND DETAILS
A-18	SECTION THROUGH ELECTRICAL SCHEDULE AND DETAILS
A-19	SECTION THROUGH PLUMBING SCHEDULE AND DETAILS
A-20	SECTION THROUGH HVAC SCHEDULE AND DETAILS
A-21	SECTION THROUGH ROOF SCHEDULE AND DETAILS
A-22	SECTION THROUGH FOUNDATION SCHEDULE AND DETAILS
A-23	SECTION THROUGH BASE SCHEDULE AND DETAILS
A-24	SECTION THROUGH SILL SCHEDULE AND DETAILS
A-25	SECTION THROUGH CASE SCHEDULE AND DETAILS
A-26	SECTION THROUGH PANEL SCHEDULE AND DETAILS
A-27	SECTION THROUGH STAIR SCHEDULE AND DETAILS
A-28	SECTION THROUGH ELEVATOR SCHEDULE AND DETAILS
A-29	SECTION THROUGH MECHANICAL SCHEDULE AND DETAILS
A-30	SECTION THROUGH ELECTRICAL SCHEDULE AND DETAILS
A-31	SECTION THROUGH PLUMBING SCHEDULE AND DETAILS
A-32	SECTION THROUGH HVAC SCHEDULE AND DETAILS
A-33	SECTION THROUGH ROOF SCHEDULE AND DETAILS
A-34	SECTION THROUGH FOUNDATION SCHEDULE AND DETAILS
A-35	SECTION THROUGH BASE SCHEDULE AND DETAILS
A-36	SECTION THROUGH SILL SCHEDULE AND DETAILS
A-37	SECTION THROUGH CASE SCHEDULE AND DETAILS
A-38	SECTION THROUGH PANEL SCHEDULE AND DETAILS
A-39	SECTION THROUGH STAIR SCHEDULE AND DETAILS
A-40	SECTION THROUGH ELEVATOR SCHEDULE AND DETAILS
A-41	SECTION THROUGH MECHANICAL SCHEDULE AND DETAILS
A-42	SECTION THROUGH ELECTRICAL SCHEDULE AND DETAILS
A-43	SECTION THROUGH PLUMBING SCHEDULE AND DETAILS
A-44	SECTION THROUGH HVAC SCHEDULE AND DETAILS
A-45	SECTION THROUGH ROOF SCHEDULE AND DETAILS
A-46	SECTION THROUGH FOUNDATION SCHEDULE AND DETAILS
A-47	SECTION THROUGH BASE SCHEDULE AND DETAILS
A-48	SECTION THROUGH SILL SCHEDULE AND DETAILS
A-49	SECTION THROUGH CASE SCHEDULE AND DETAILS
A-50	SECTION THROUGH PANEL SCHEDULE AND DETAILS
A-51	SECTION THROUGH STAIR SCHEDULE AND DETAILS
A-52	SECTION THROUGH ELEVATOR SCHEDULE AND DETAILS
A-53	SECTION THROUGH MECHANICAL SCHEDULE AND DETAILS
A-54	SECTION THROUGH ELECTRICAL SCHEDULE AND DETAILS
A-55	SECTION THROUGH PLUMBING SCHEDULE AND DETAILS
A-56	SECTION THROUGH HVAC SCHEDULE AND DETAILS
A-57	SECTION THROUGH ROOF SCHEDULE AND DETAILS
A-58	SECTION THROUGH FOUNDATION SCHEDULE AND DETAILS
A-59	SECTION THROUGH BASE SCHEDULE AND DETAILS
A-60	SECTION THROUGH SILL SCHEDULE AND DETAILS
A-61	SECTION THROUGH CASE SCHEDULE AND DETAILS
A-62	SECTION THROUGH PANEL SCHEDULE AND DETAILS
A-63	SECTION THROUGH STAIR SCHEDULE AND DETAILS
A-64	SECTION THROUGH ELEVATOR SCHEDULE AND DETAILS
A-65	SECTION THROUGH MECHANICAL SCHEDULE AND DETAILS
A-66	SECTION THROUGH ELECTRICAL SCHEDULE AND DETAILS
A-67	SECTION THROUGH PLUMBING SCHEDULE AND DETAILS
A-68	SECTION THROUGH HVAC SCHEDULE AND DETAILS
A-69	SECTION THROUGH ROOF SCHEDULE AND DETAILS
A-70	SECTION THROUGH FOUNDATION SCHEDULE AND DETAILS
A-71	SECTION THROUGH BASE SCHEDULE AND DETAILS
A-72	SECTION THROUGH SILL SCHEDULE AND DETAILS
A-73	SECTION THROUGH CASE SCHEDULE AND DETAILS
A-74	SECTION THROUGH PANEL SCHEDULE AND DETAILS
A-75	SECTION THROUGH STAIR SCHEDULE AND DETAILS
A-76	SECTION THROUGH ELEVATOR SCHEDULE AND DETAILS
A-77	SECTION THROUGH MECHANICAL SCHEDULE AND DETAILS
A-78	SECTION THROUGH ELECTRICAL SCHEDULE AND DETAILS
A-79	SECTION THROUGH PLUMBING SCHEDULE AND DETAILS
A-80	SECTION THROUGH HVAC SCHEDULE AND DETAILS
A-81	SECTION THROUGH ROOF SCHEDULE AND DETAILS
A-82	SECTION THROUGH FOUNDATION SCHEDULE AND DETAILS
A-83	SECTION THROUGH BASE SCHEDULE AND DETAILS
A-84	SECTION THROUGH SILL SCHEDULE AND DETAILS
A-85	SECTION THROUGH CASE SCHEDULE AND DETAILS
A-86	SECTION THROUGH PANEL SCHEDULE AND DETAILS
A-87	SECTION THROUGH STAIR SCHEDULE AND DETAILS
A-88	SECTION THROUGH ELEVATOR SCHEDULE AND DETAILS
A-89	SECTION THROUGH MECHANICAL SCHEDULE AND DETAILS
A-90	SECTION THROUGH ELECTRICAL SCHEDULE AND DETAILS
A-91	SECTION THROUGH PLUMBING SCHEDULE AND DETAILS
A-92	SECTION THROUGH HVAC SCHEDULE AND DETAILS
A-93	SECTION THROUGH ROOF SCHEDULE AND DETAILS
A-94	SECTION THROUGH FOUNDATION SCHEDULE AND DETAILS
A-95	SECTION THROUGH BASE SCHEDULE AND DETAILS
A-96	SECTION THROUGH SILL SCHEDULE AND DETAILS
A-97	SECTION THROUGH CASE SCHEDULE AND DETAILS
A-98	SECTION THROUGH PANEL SCHEDULE AND DETAILS
A-99	SECTION THROUGH STAIR SCHEDULE AND DETAILS
A-100	SECTION THROUGH ELEVATOR SCHEDULE AND DETAILS


SOIL TEST BORING DATA

	HOLE 1	HOLE 2	HOLE 3	HOLE 4	HOLE 5	HOLE 6	HOLE 7
640							
641							
642							
700							

NOTE
NEW FIRST FLOOR
E.L. = 100.0' EQUIVALENT
EXISTING 696.0' ±

TOPOGRAPHICAL SURVEY TAVERN MARCH 6, 1980
N. CASINI

NOTE
STAIRS TO BE LOCATED FOR
SOIL DATA (DITCHED
TRENCH)

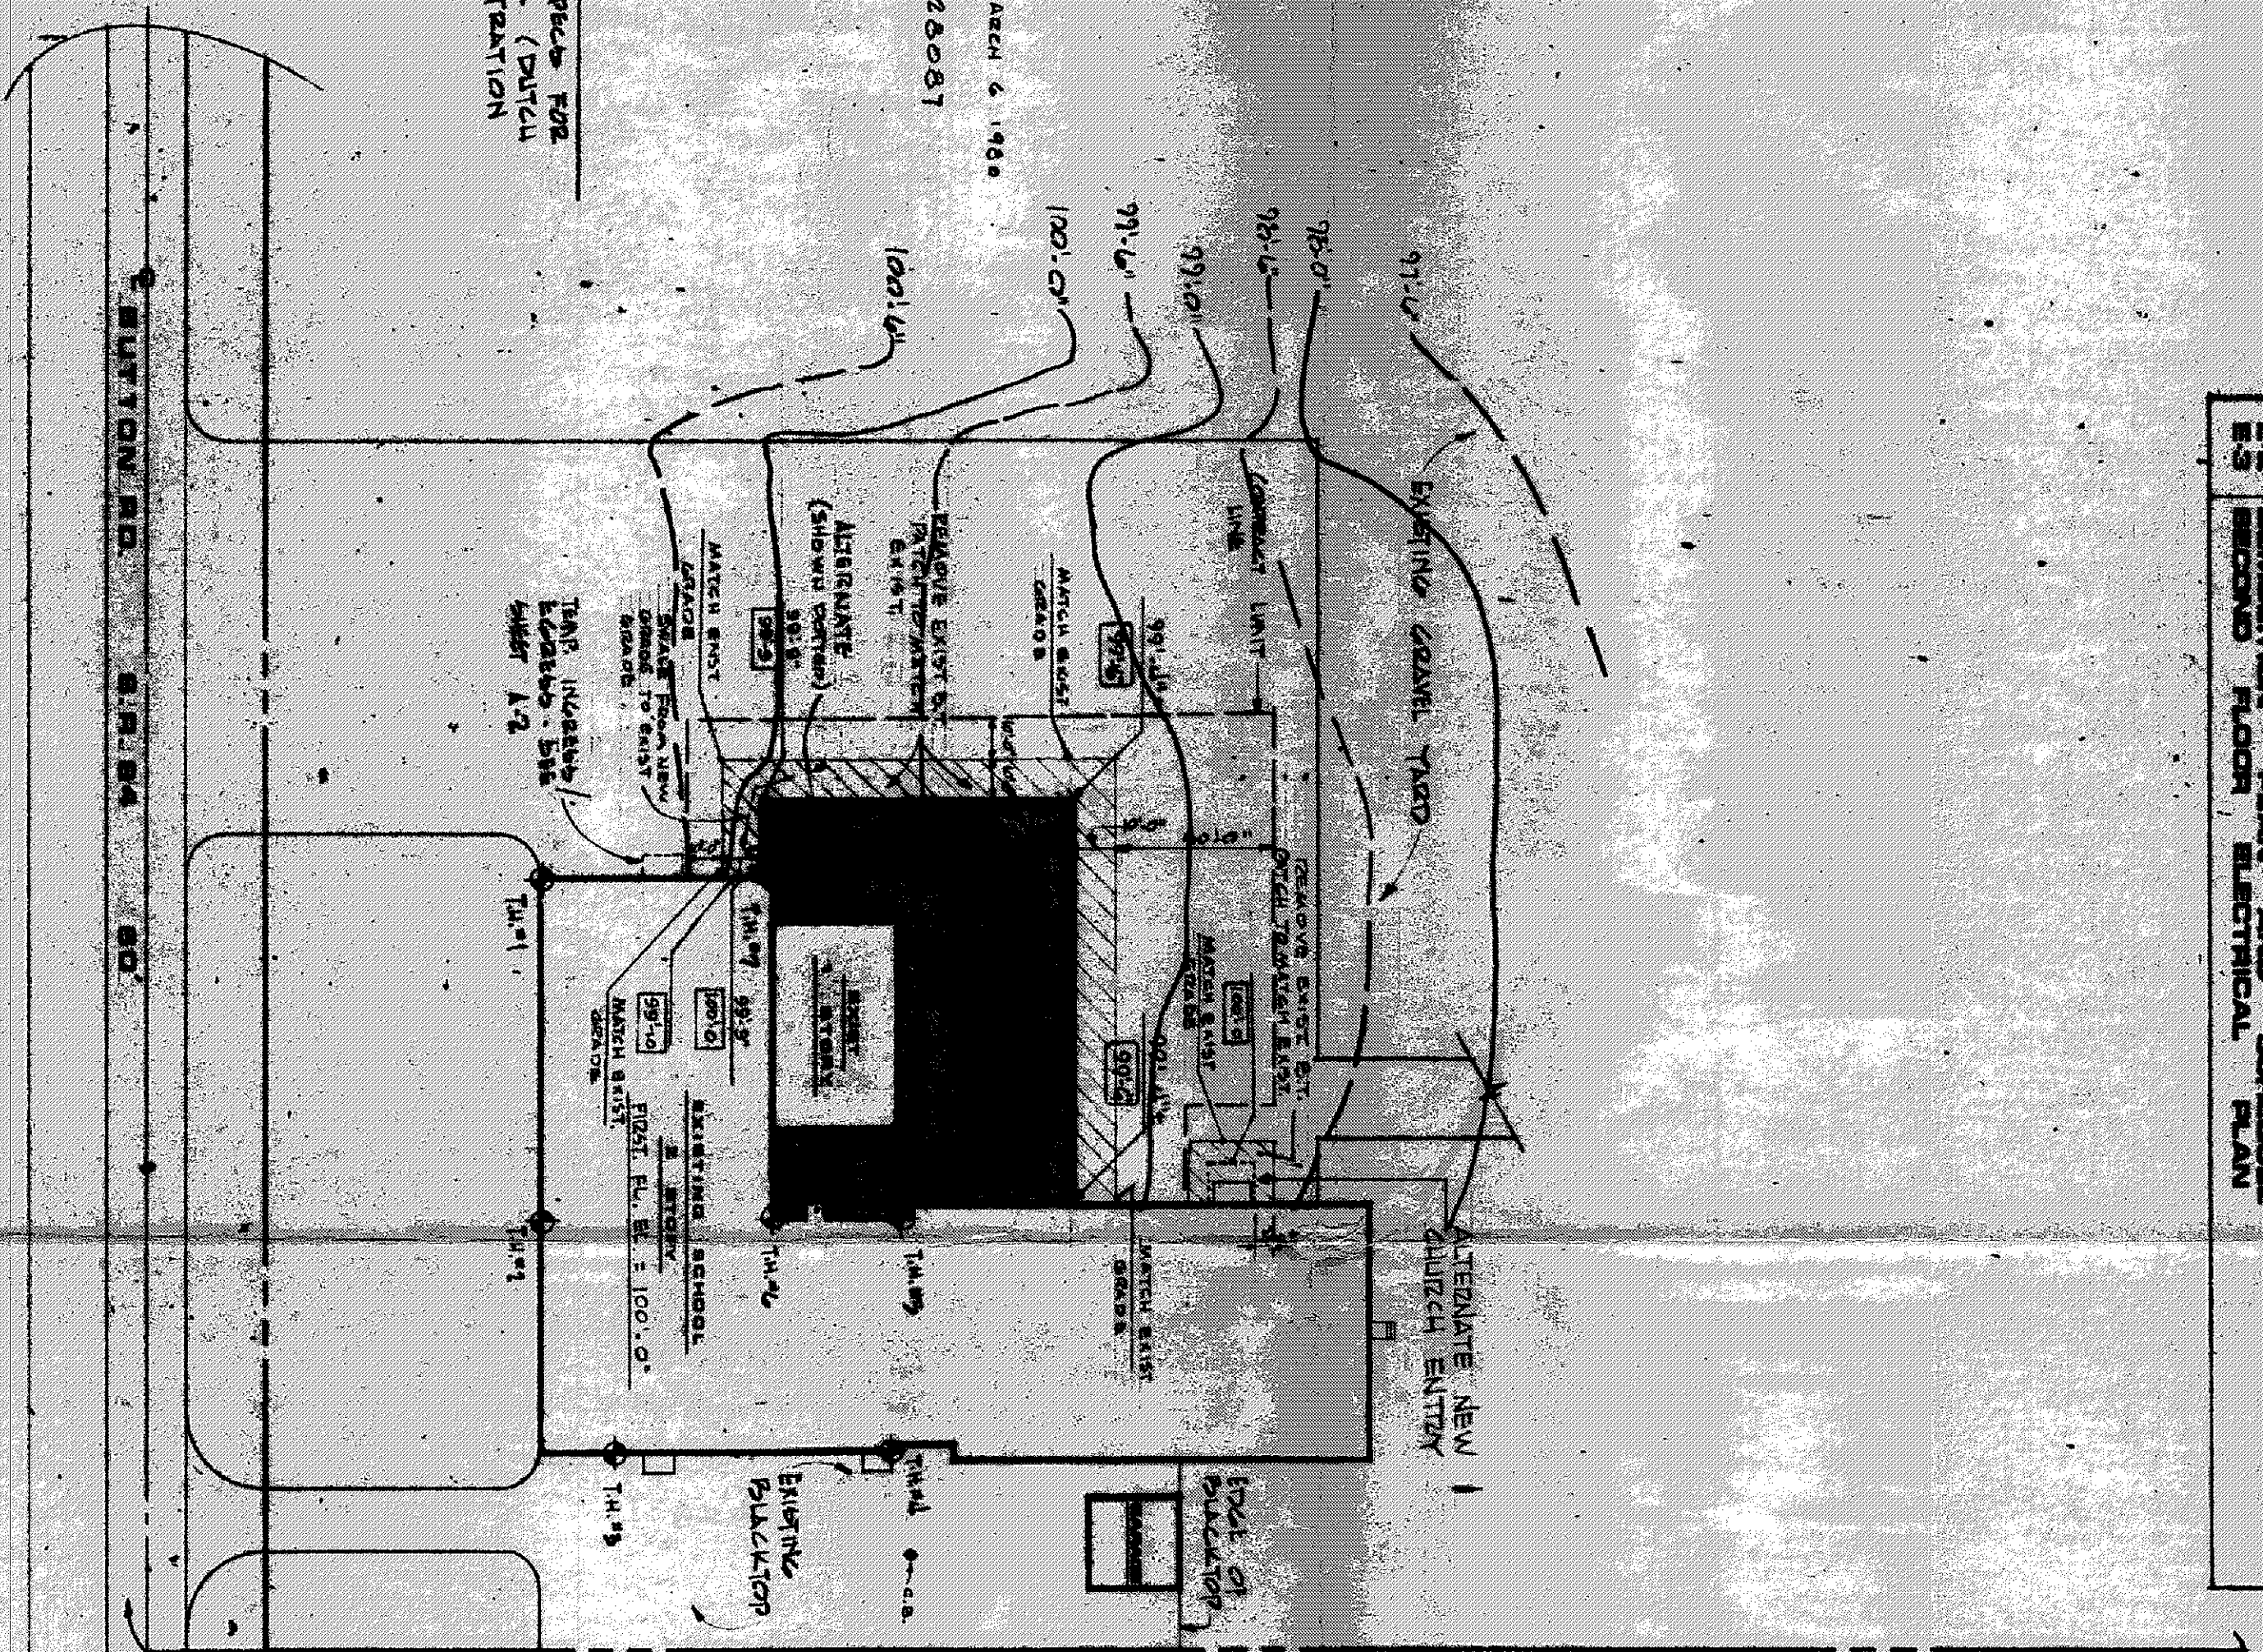

PLOT PLAN

SCALE: 1" = 40'

Grading Plan Approved
as shown and/or noted by
THOMAS P. GILLES, P.E.
City Engineer
Date 7/2/80