

"I, THE UNDERSIGNED HEREBY CERTIFY THAT THIS TOPOGRAPHY, INDICATED BY 6", 1" OR 2" CONTOURS, AND ELEVATIONS SHOWN HEREON REPRESENT AN ACTUAL FIELD SURVEY MADE BY ME ON THE 13th DAY OF JUNE, 2012 AND THAT THE ELEVATIONS WERE TAKEN AT APPROPRIATE INTERVALS AND THAT AS OF THAT DATE THEY EXISTED AS INDICATED HEREON."

STAN R. LOCH


7-31-12

REG. # 8249

BENCHMARK
TOP STEM OF HYDRANT
ELEV = 1049.27

EX STS MH
RIM 1043.29
12" INV 1036.46
18" INV 1036.02
24" INV 1035.51

EX SAS MH
RIM 1041.44
8" INVS 1034.19

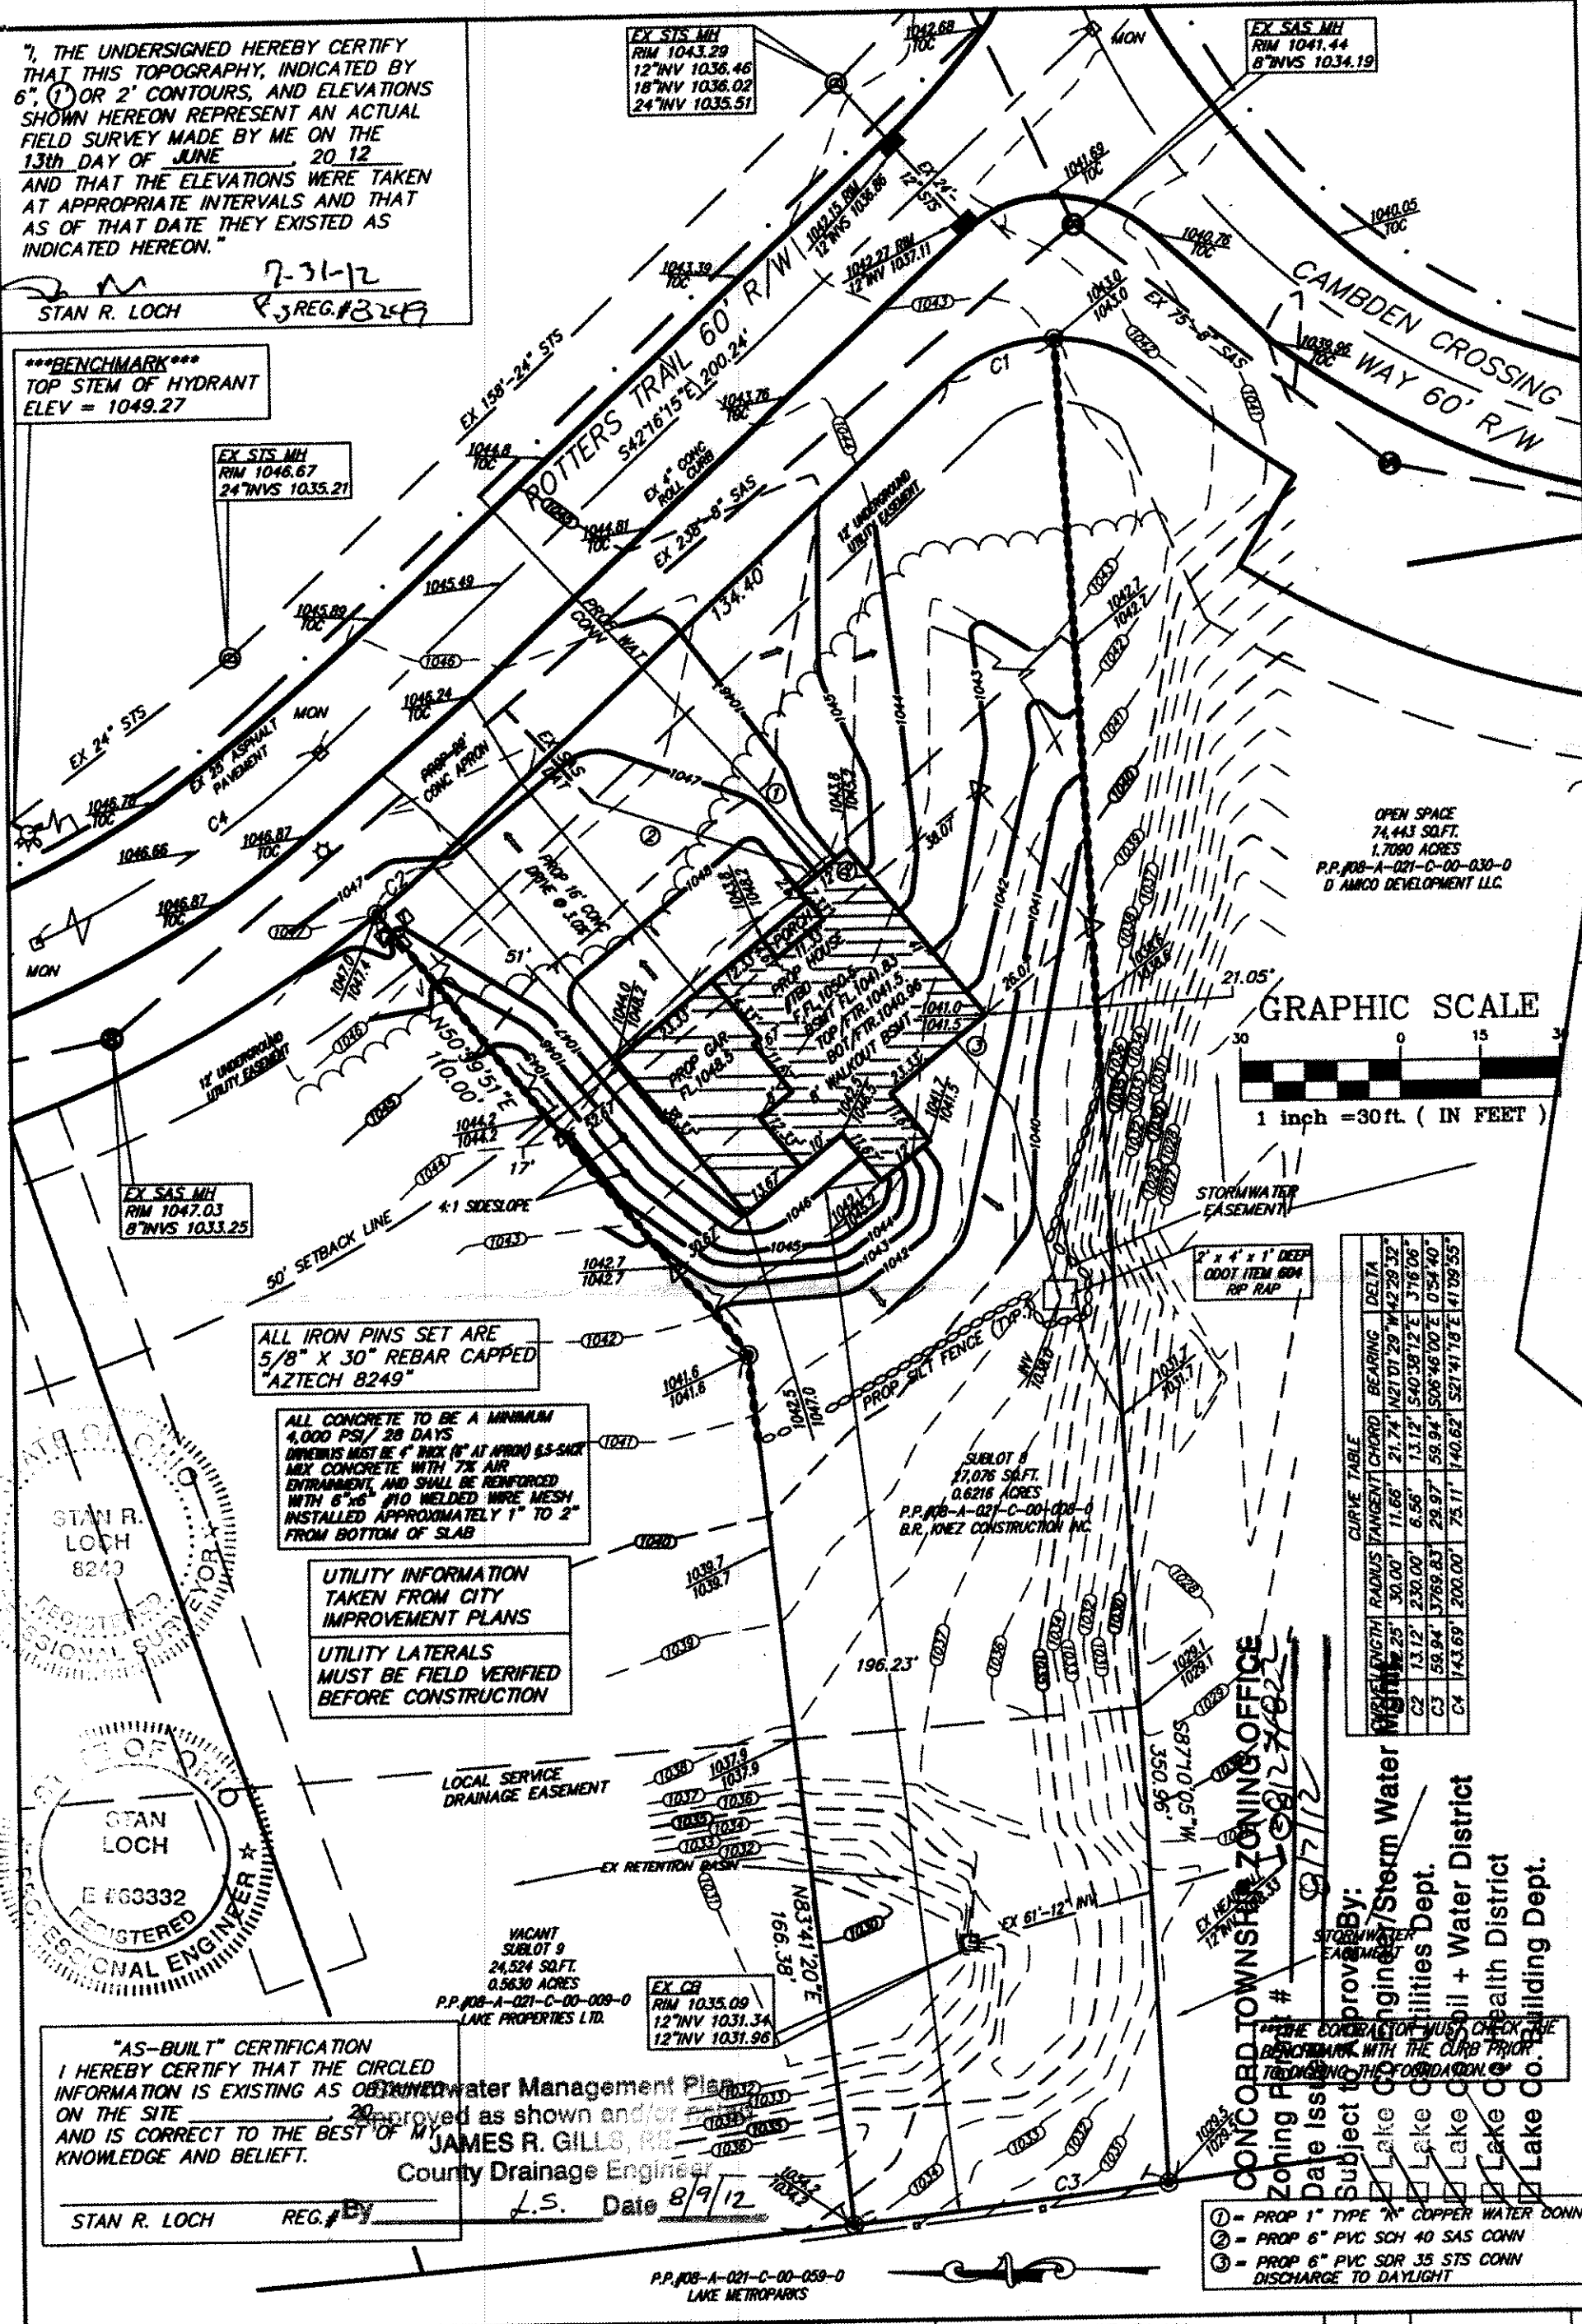

OPEN SPACE
74,443 SQ. FT.
1.7080 ACRES
P.P. #08-A-021-C-00-030-0
D AMCO DEVELOPMENT LLC

GRAPHIC SCALE

1 inch = 30 ft. (IN FEET)

CURVE TABLE			
CHORD	BEARING	DELTA	
100.00	N21°01'29" W	42°28'32"	
100.00	N21°01'29" W	42°28'32"	
100.00	S40°38'12" E	37°16'08"	
100.00	S40°38'12" E	37°16'08"	
100.00	S40°38'12" E	37°16'08"	
100.00	S40°38'12" E	37°16'08"	
100.00	S40°38'12" E	37°16'08"	
100.00	S40°38'12" E	37°16'08"	
100.00	S40°38'12" E	37°16'08"	
100.00	S40°38'12" E	37°16'08"	

CONCORD TOWNSHIP ZONING OFFICE
Zoning # 108/2762
Date Issued 8/7/12
Subject to: Lake Co. Engineering / Storm Water
Lake Co. Utilities Dept.
Lake Co. Oil & Water District
Lake Co. Health District
Lake Co. Building Dept.

"AS-BUILT" CERTIFICATION
I HEREBY CERTIFY THAT THE CIRCLED INFORMATION IS EXISTING AS OBTAINED ON THE SITE, 2012, AND IS CORRECT TO THE BEST OF MY KNOWLEDGE AND BELIEF.

STAN R. LOCH

REG. # 8249

JAMES R. GILLS, R.E.
County Drainage Engineer

L.S. Date 8/9/12

P.P. #08-A-021-C-00-059-0
LAKE METROPARKS

HORIZ. SCALE: 1" = 30'	VERT. SCALE:
DRAWN BY: KEG	DATE: 7-31-2012
CHECKED BY: SRL	DRAWING NO.: 20112519
JOB NO.: 20112519	SHEET: 1 of 3

5426 WARNER ROAD - SUITE 12
VALLEY VIEW, OHIO 44125
440-602-9071 FAX 216-369-0250

AZTECH
ENGINEERING + SURVEYING
Civil Engineering + Land Surveying

SITE PLAN
FOR
B.R. KNEZ CONSTRUCTION, INC.
POTTERS TRAIL
S/L 8 IN THE
CAMDEN CREEK ESTATES PHASE NO.1
PLAT VOLUME 52, PAGE 27
CONCORD TOWNSHIP
LAKE COUNTY, OHIO

NO.	DATE	DESCRIPTION
1		PROP 1" TYPE "X" COPPER WATER DOWN
2		PROP 6" PVC SCH 40 SAS CONN
3		PROP 6" PVC SDR 35 STS CONN DISCHARGE TO DAYLIGHT