

SITE PLAN

Calvin Township, Lake County, Ohio

for: J.W. BETTELEY BUILDING

ADDRESS		CITY		ZIP	
Eagle Ridge Sub		LOT		TRACT	
SUBDIVISION		VOLUME		PAGE	
VOL. 100		PAGE 10		PAGE 10	
SUBLOT NO.		PERM. PARCEL NO.		STREET	

LEGEND	
SANITARY MANHOLE	WATER VALVE (GAS)
STORM MANHOLE	WATER METER (GAS)
INLET OR CATCH BASIN	AS BUILT ELEVATION
HYDRANT	INDICATES DIRECTION OF SURFACE DRAINAGE
EXISTING CONTOURS	
PROPOSED CONTOURS	
EXIST. ELEV.	PROP. ELEV.

REMARKS

ALL BOUNDARY DATA SHOWN WAS OBTAINED FROM IDEEDS, RECORDED SUBDIVISION PLAT OR OTHER PUBLIC RECORDS.

LOCATIONS AS SHOWN OF ADJACENT WELLS AND SEPTIC TANKS OBTAINED FROM LAKE COUNTY HEALTH DEPARTMENT

DESIGN CERTIFICATION

THIS PLAT WAS PREPARED BY ME, AND IS CORRECT TO THE BEST OF MY KNOWLEDGE AND BELIEF.

NAME: HARRY S. JONES, JR. S-6343

SURVEYOR REGISTRATION NO. 10002

CHECK LIST	
NO. OF BEDROOMS	WATER MAIN SIZE, LOCATION
DIMENSIONS	SAN. SEWER SIZE & GR. LOC.
BEARINGS	SAN. IN. CAST ELEV. INV. ELEV.
TIE TO NEAREST STREET	SAN. CON. SIZE, LOC. DEPTH
SUBLOT NO. PARCEL NO.	SAN. SEWER SIZE & GR. LOC.
SURROUNDING OWNERS	STORM IN. CAST ELEV. INV. ELEV.
BLOOD DIMENSIONS FIN. GR.	STORM IN. CAST ELEV. INV. ELEV.
BLOOD THIS P.L.N. GRADES	STORM IN. CAST ELEV. INV. ELEV.
APPROX. TYPE WIDTH THICKNESS	STORM IN. CAST ELEV. INV. ELEV.
APPROX. TYPE WIDTH THICKNESS	STORM IN. CAST ELEV. INV. ELEV.
CULVERT TYPE DIA. LENGTH	STORM IN. CAST ELEV. INV. ELEV.
ROCK OUTCROPPINGS	STORM IN. CAST ELEV. INV. ELEV.

REVISIONS	
NO.	DATE BY
1	
2	
3	
4	
5	

PLAN PREPARED BY: BABCOCK • JONES & ASSOCIATES, INC. PAINESVILLE, OHIO

DRAWN BY: DATE: 6/10/88 SCALE: 1"=30'

CHKD. DATE: 6/10/88 PHONE NO. 357-1811

CREW CHIEF: DATE: 6/10/88 DRAWING NO. 88-010-6

"AS BUILT" CERTIFICATION

I, HEREBY CERTIFY THAT THE CIRCLED GRADES ARE EXISTING FINISH GRADES CHECKED IN THE FIELD ON 19

AND ARE CORRECT TO THE BEST OF MY KNOWLEDGE AND BELIEF.

REGISTERED SURVEYOR

LOW YIELD WATER NO. 1

FIXTURES REQUIRED

Shower Head

Toilet

SEWAGE DISPOSAL PERMIT MUST BE OBTAINED BY A LAKE COUNTY LICENSED INSTALLER BEFORE INSTALLATION IS STARTED.

ISSUED: 6-23-81

LAKE COUNTY HEALTH DISTRICT


DATE: 6-24-88

APPROVED: JAMES A. MCGRAW

- To be brought to finished grade
- Septic tank manhole covers
- Distribution box cover
- No footer drains or downspouts to be discharged into septic tanks
- All waste water to be discharged into septic tanks

PILE CREST


LAKE COUNTY HEALTH DISTRICT	DATE: 6-24-88
APPROVED: JAMES A. MCGRAW	

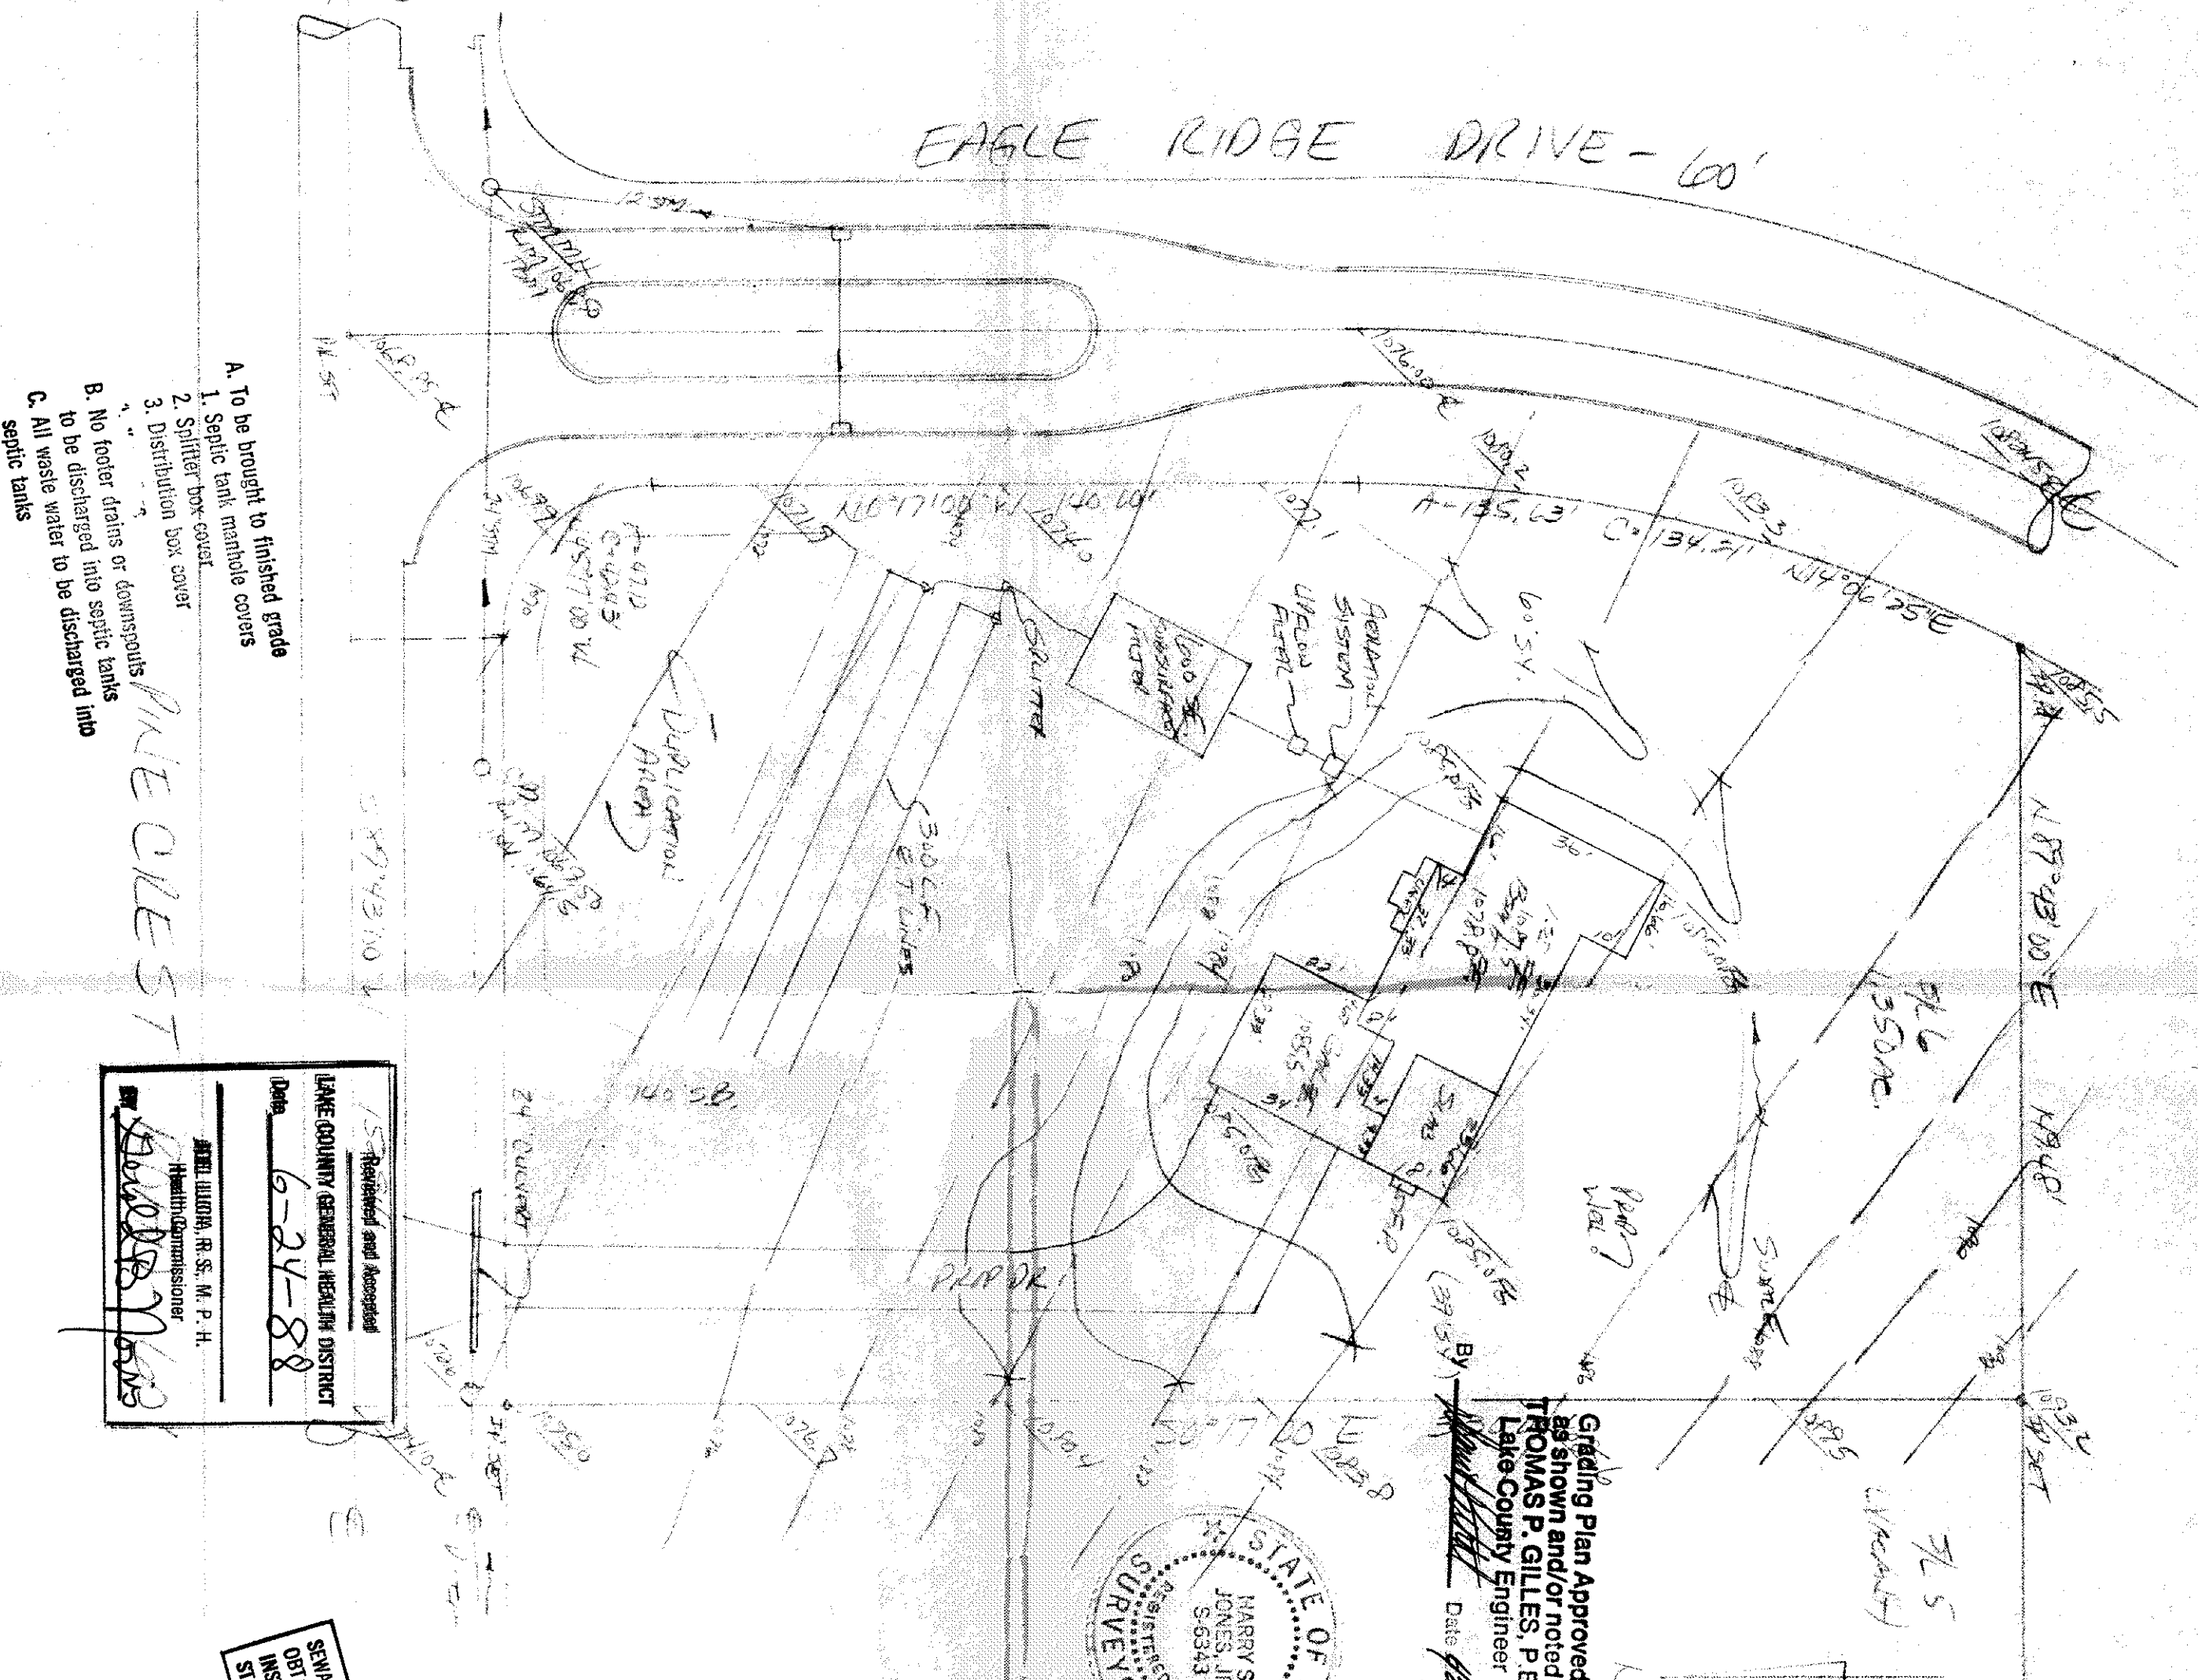

HYDRAULIC PROFILE

SCALE: HORIZ. 1"=30'

VERT. 1"=5'

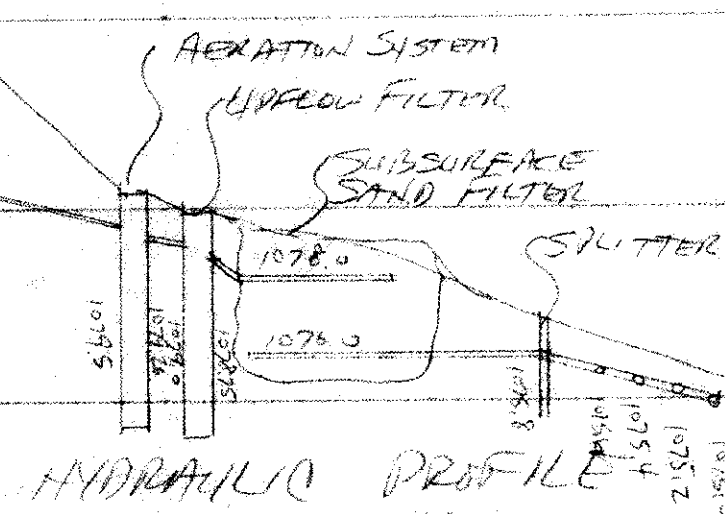

EF 1075