




MODIFICATION TO EXISTING CIRCUIT "E"

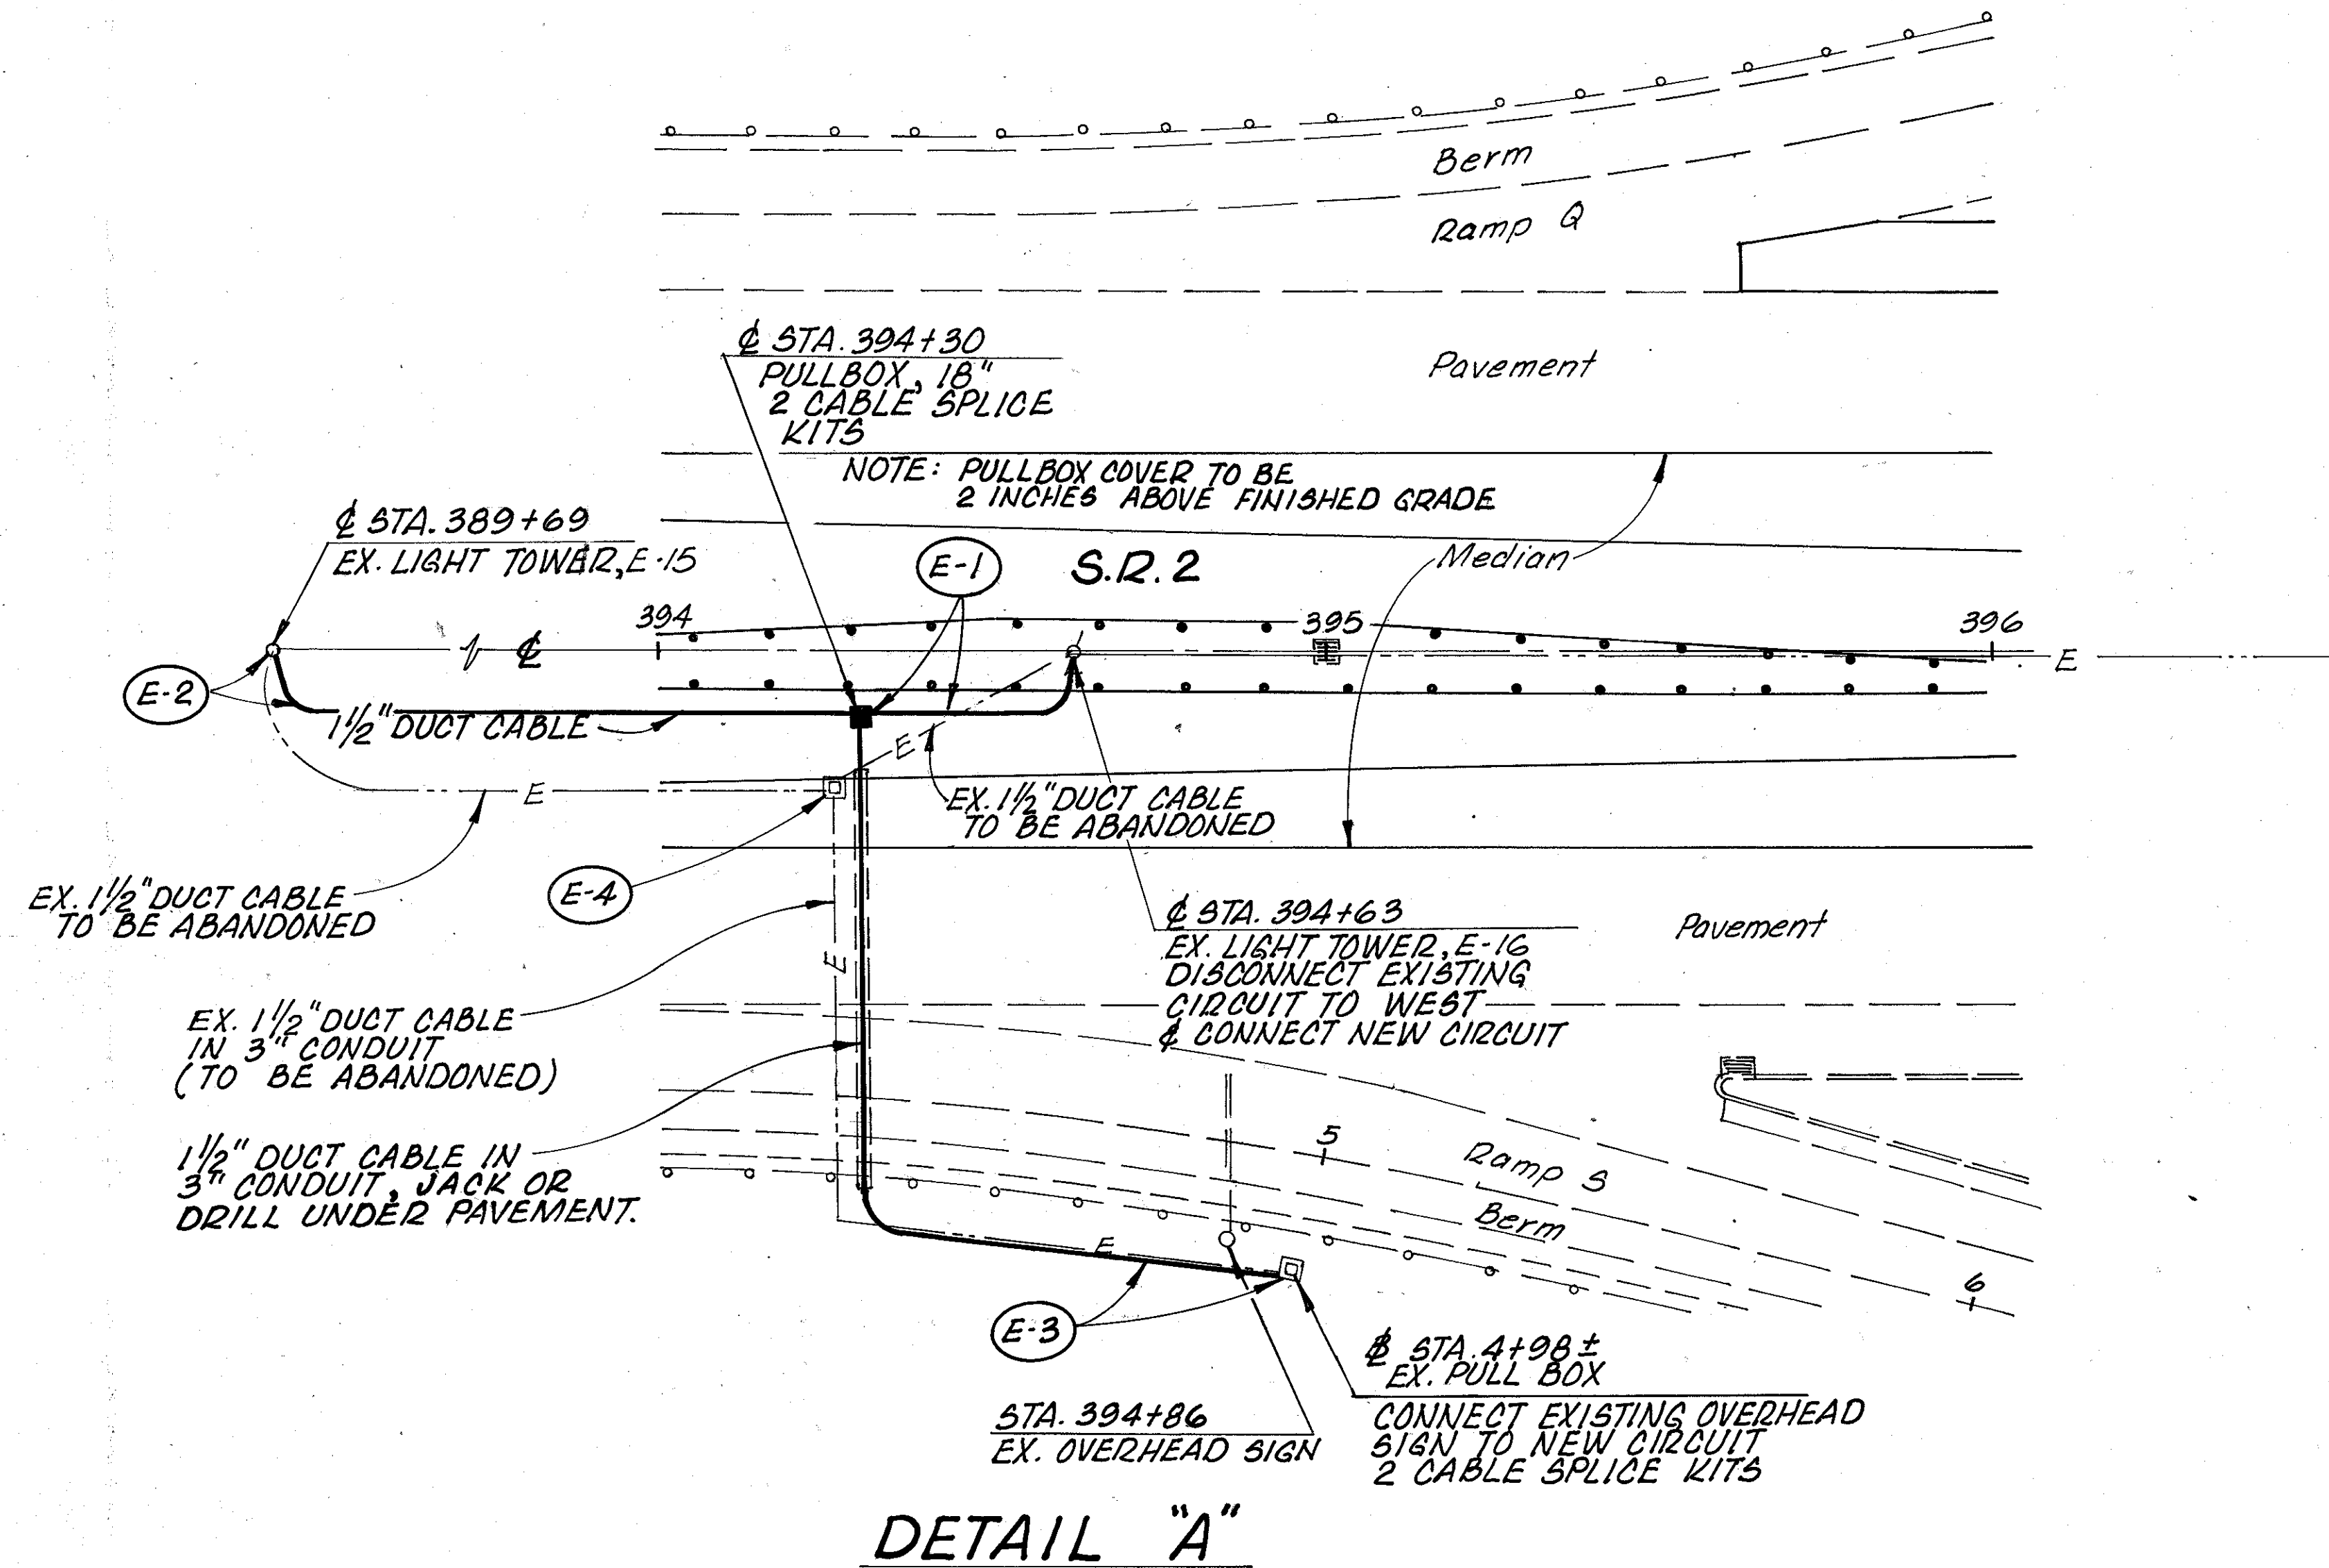

DETAIL "A"

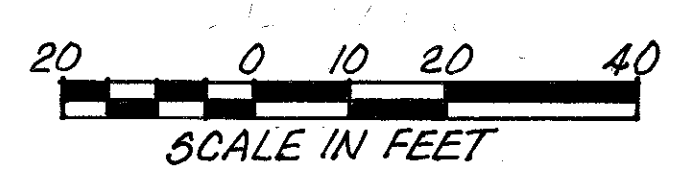

FOR ESTIMATED QUANTITIES SEE SHEET No. 45

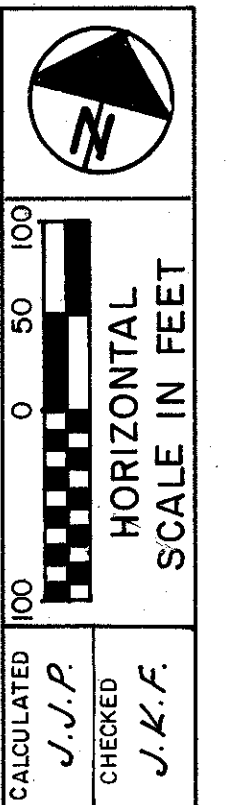

ELECTRICAL DETAILS

LAK-2-946