
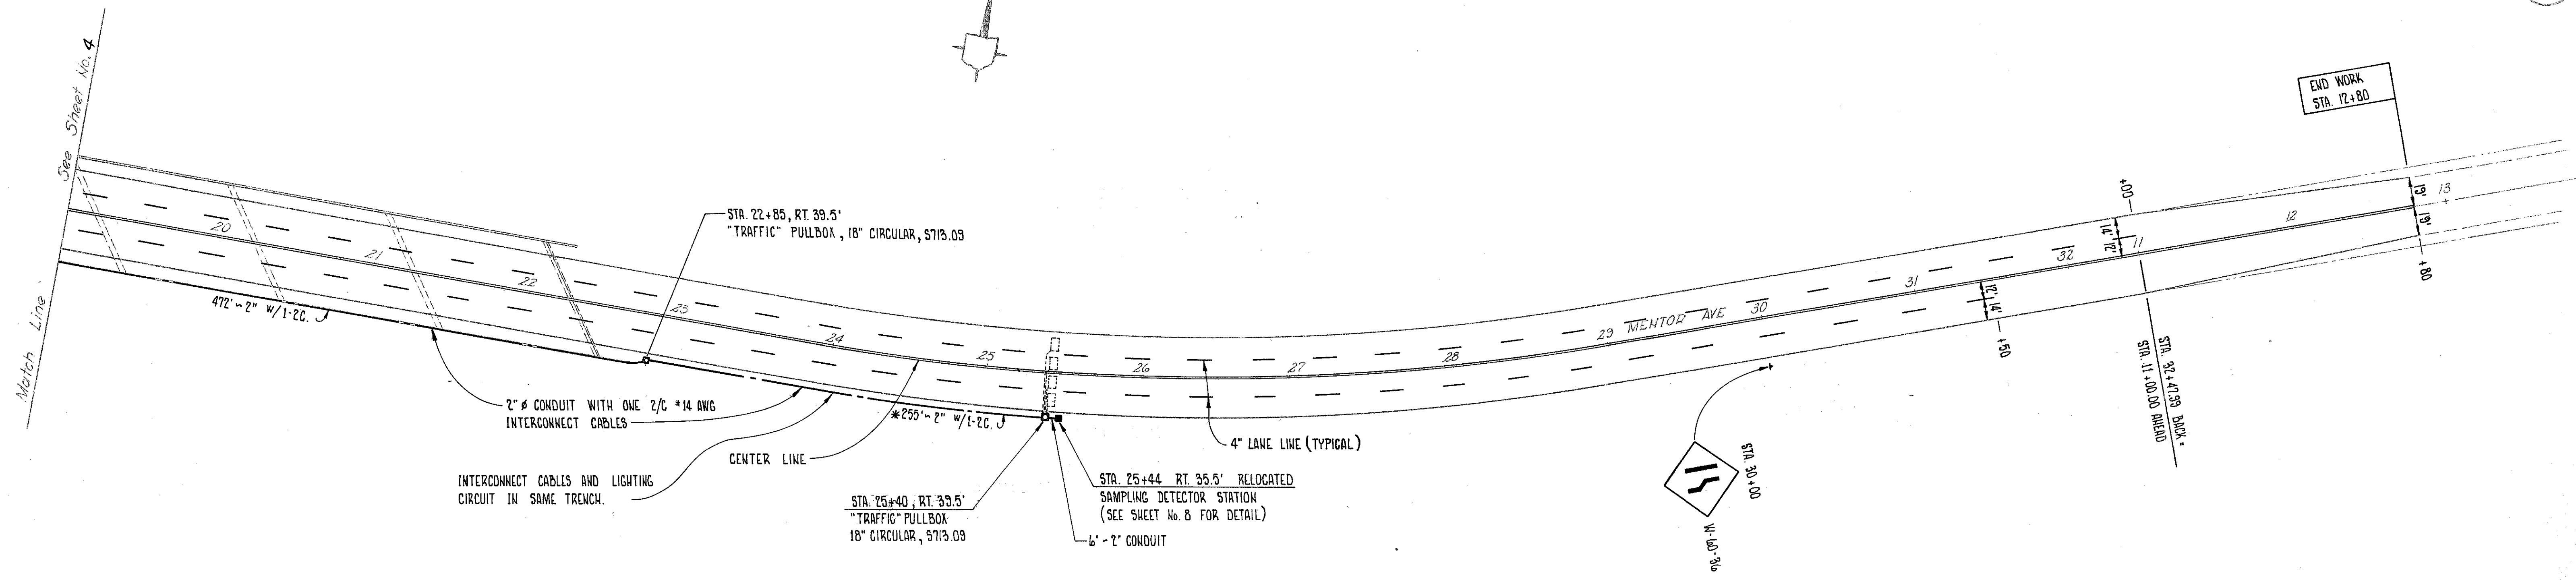


FIRMA REGION	STATE	PROJECT
5	OHIO	

49
85

LAKE COUNTY
LAK-20-5.60

5
11

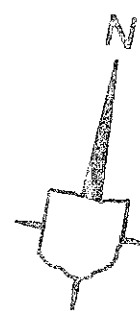

INTERCONNECT CABLES AND LIGHTING
CIRCUIT IN SAME TRENCH.

CENTER LINE

4" LANE LINE (TYPICAL)

STA. 25+40, RT. 33.5'
"TRAFFIC" PULLBOX
18" CIRCULAR, 5713.09

STA. 25+44 RT. 35.5' RELOCATED
SAMPLING DETECTOR STATION
(SEE SHEET No. 8 FOR DETAIL)
6'-2" CONDUIT

* TRENCH AND LIGHTING CIRCUIT QUANTITIES
CARRIED IN LIGHTING PLANS.

5
11