



MICROFILMED
JAN 6 1983

THE 10" φ FORMS SHALL BE IN ALIGNMENT AND SHALL BE ADEQUATELY DRAINED. 3/4" φ NON-FERROUS DRAIN TUBES SHALL BE USED AND SHALL BE LOCATED AT JOINT BETWEEN PRECAST PANELS.

FHWA REGION	STATE	PROJECT
5	OHIO	

70
85


LAKE COUNTY
LAK-20-5.60

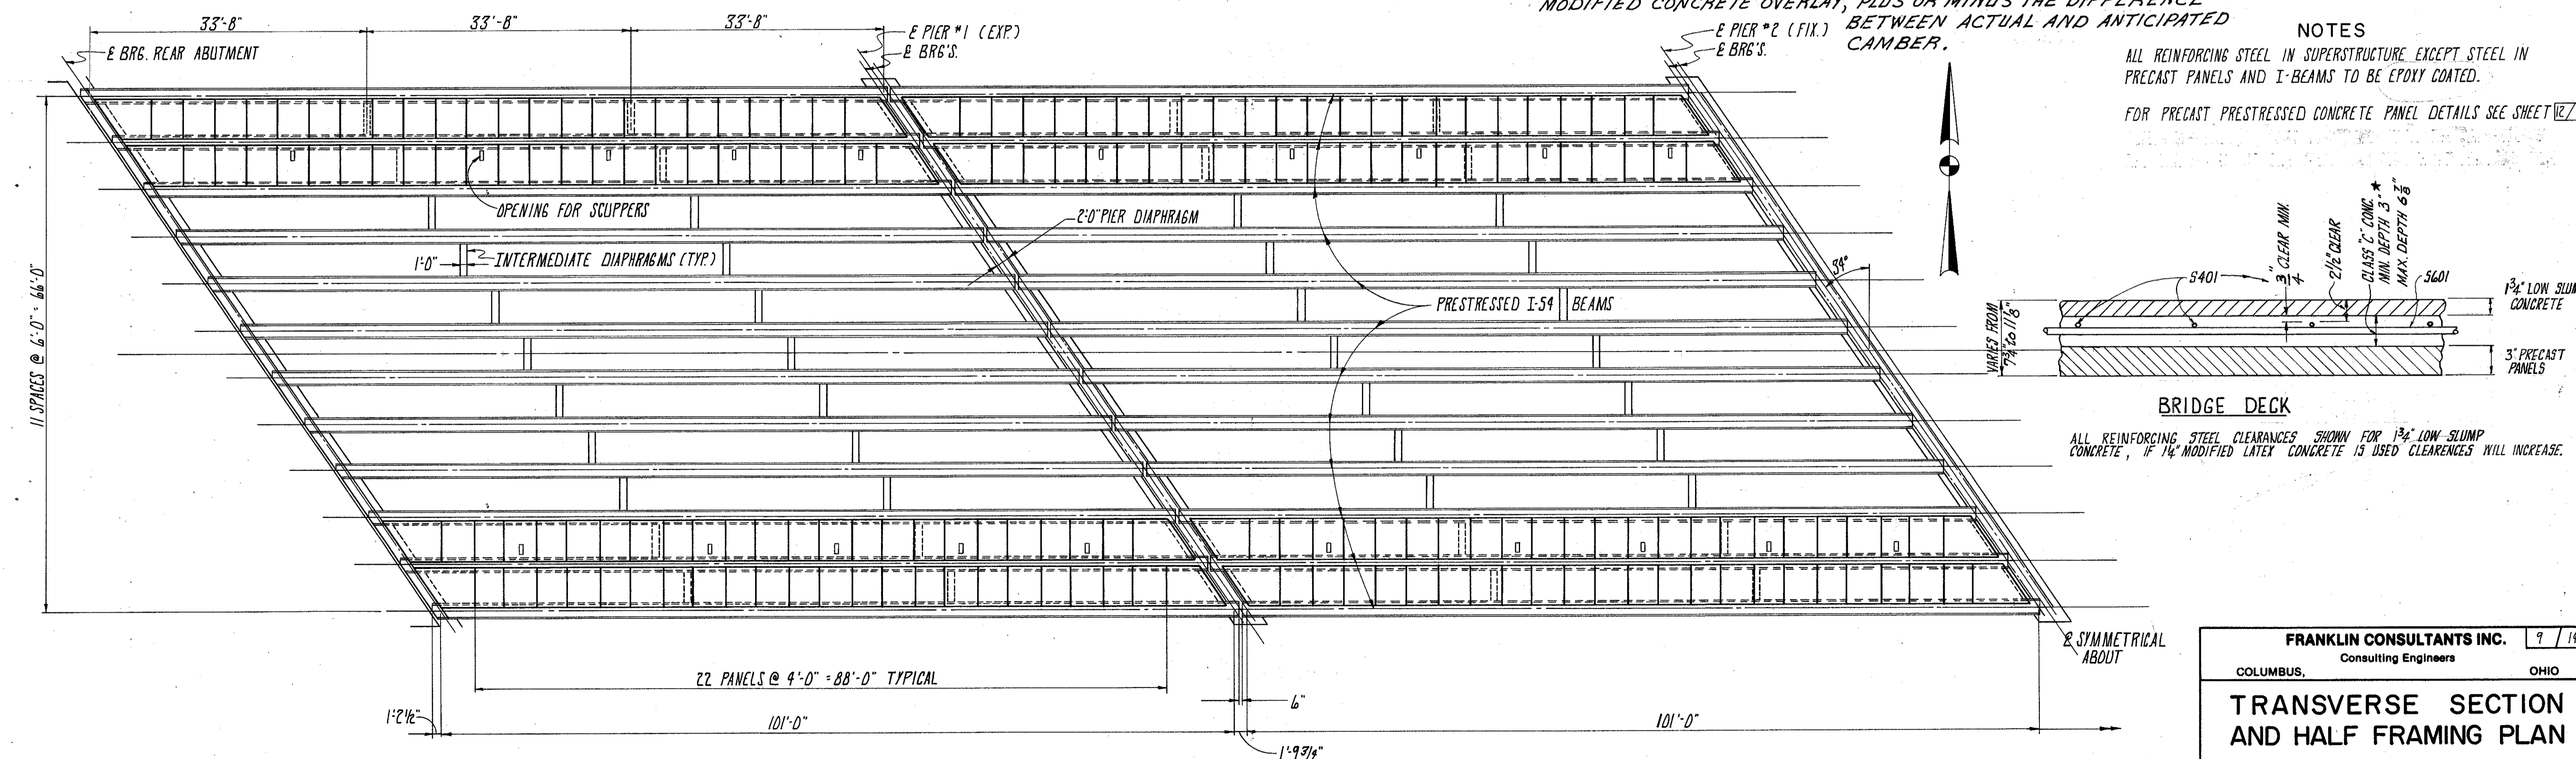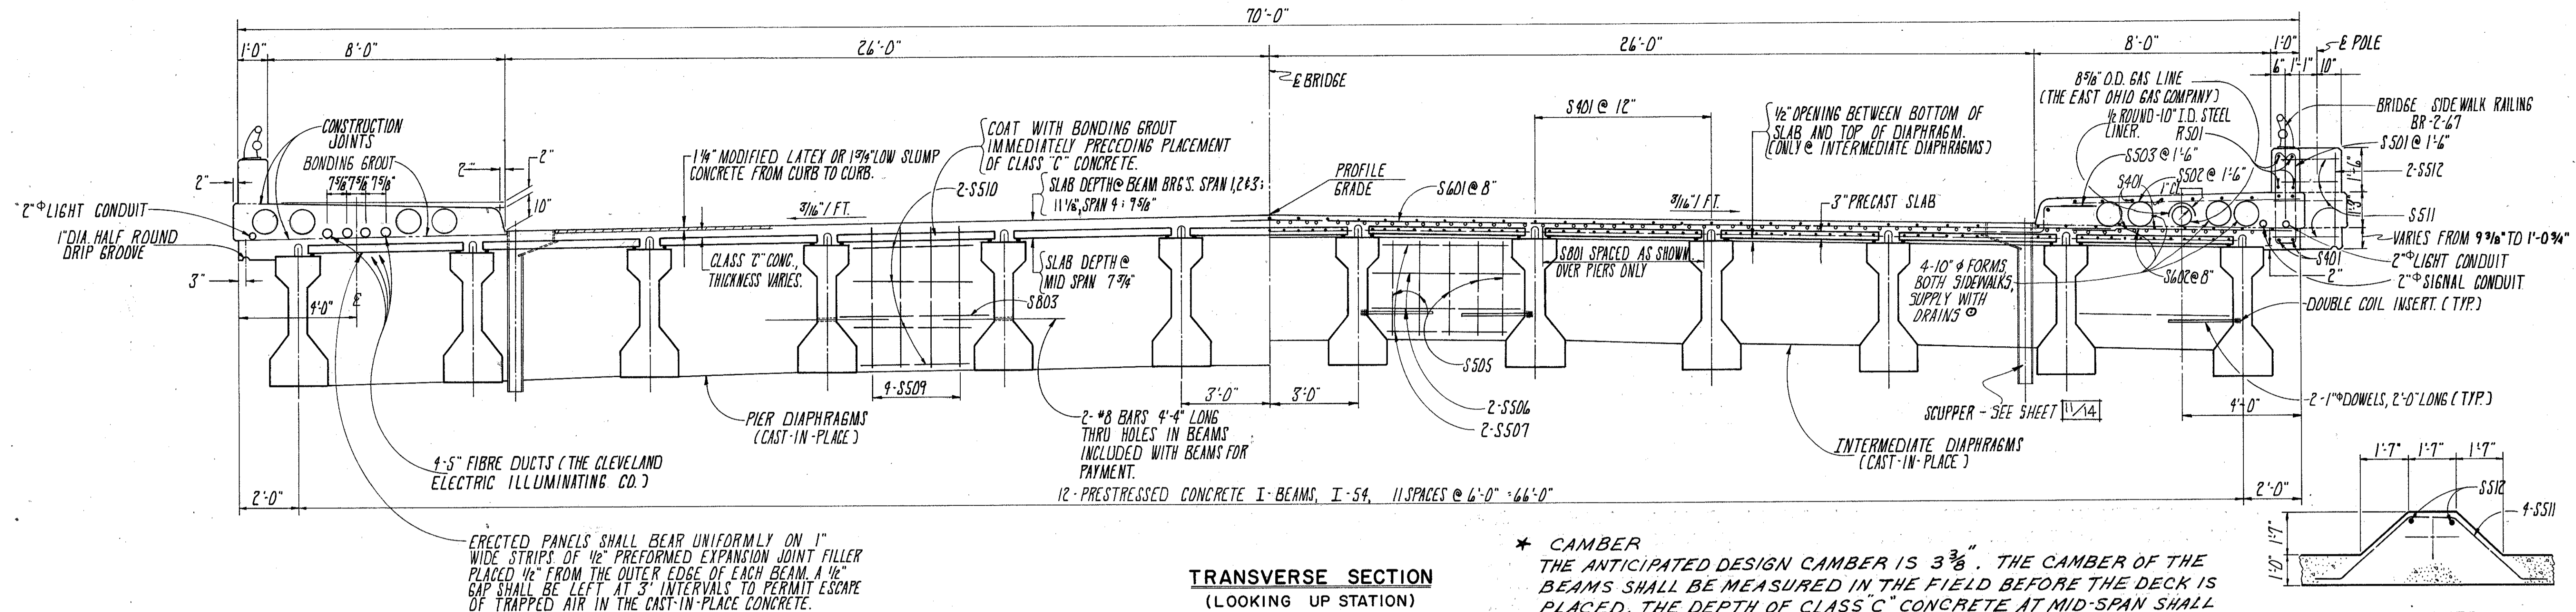

NOTES

ALL REINFORCING STEEL IN SUPERSTRUCTURE EXCEPT STEEL IN PRECAST PANELS AND I-BEAMS TO BE EPOXY COATED.

FOR PRECAST PRESTRESSED CONCRETE PANEL DETAILS SEE SHEET 12/14

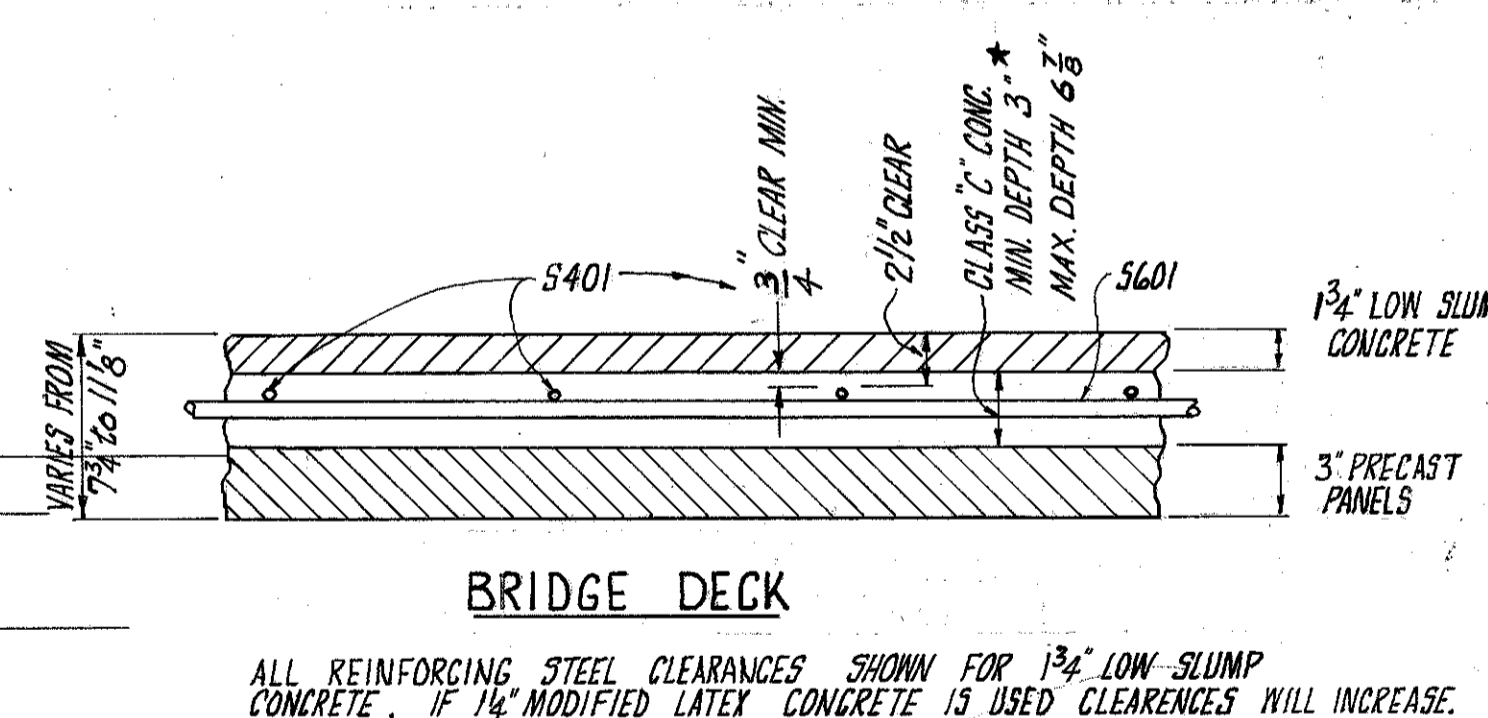

FRANKLIN CONSULTANTS INC. 9/14
COLUMBUS, OHIO
Consulting Engineers

TRANSVERSE SECTION AND HALF FRAMING PLAN

CITY OF WILLOUGHBY
CHAGRIN RIVER BRIDGE

DESIGNED	DRAWN	TRACED	CHECKED	REVIEWED	DATE	REVISED
FA	B.B.	B.B.	MM	JL	9/17/77	

BRUNING 44-560 30845