



COPYRIGHT - DATE: 11-22-99 11:26 CT CONSULTANTS, INC. H:\CT\97303\dwg\AIRP04.dwg

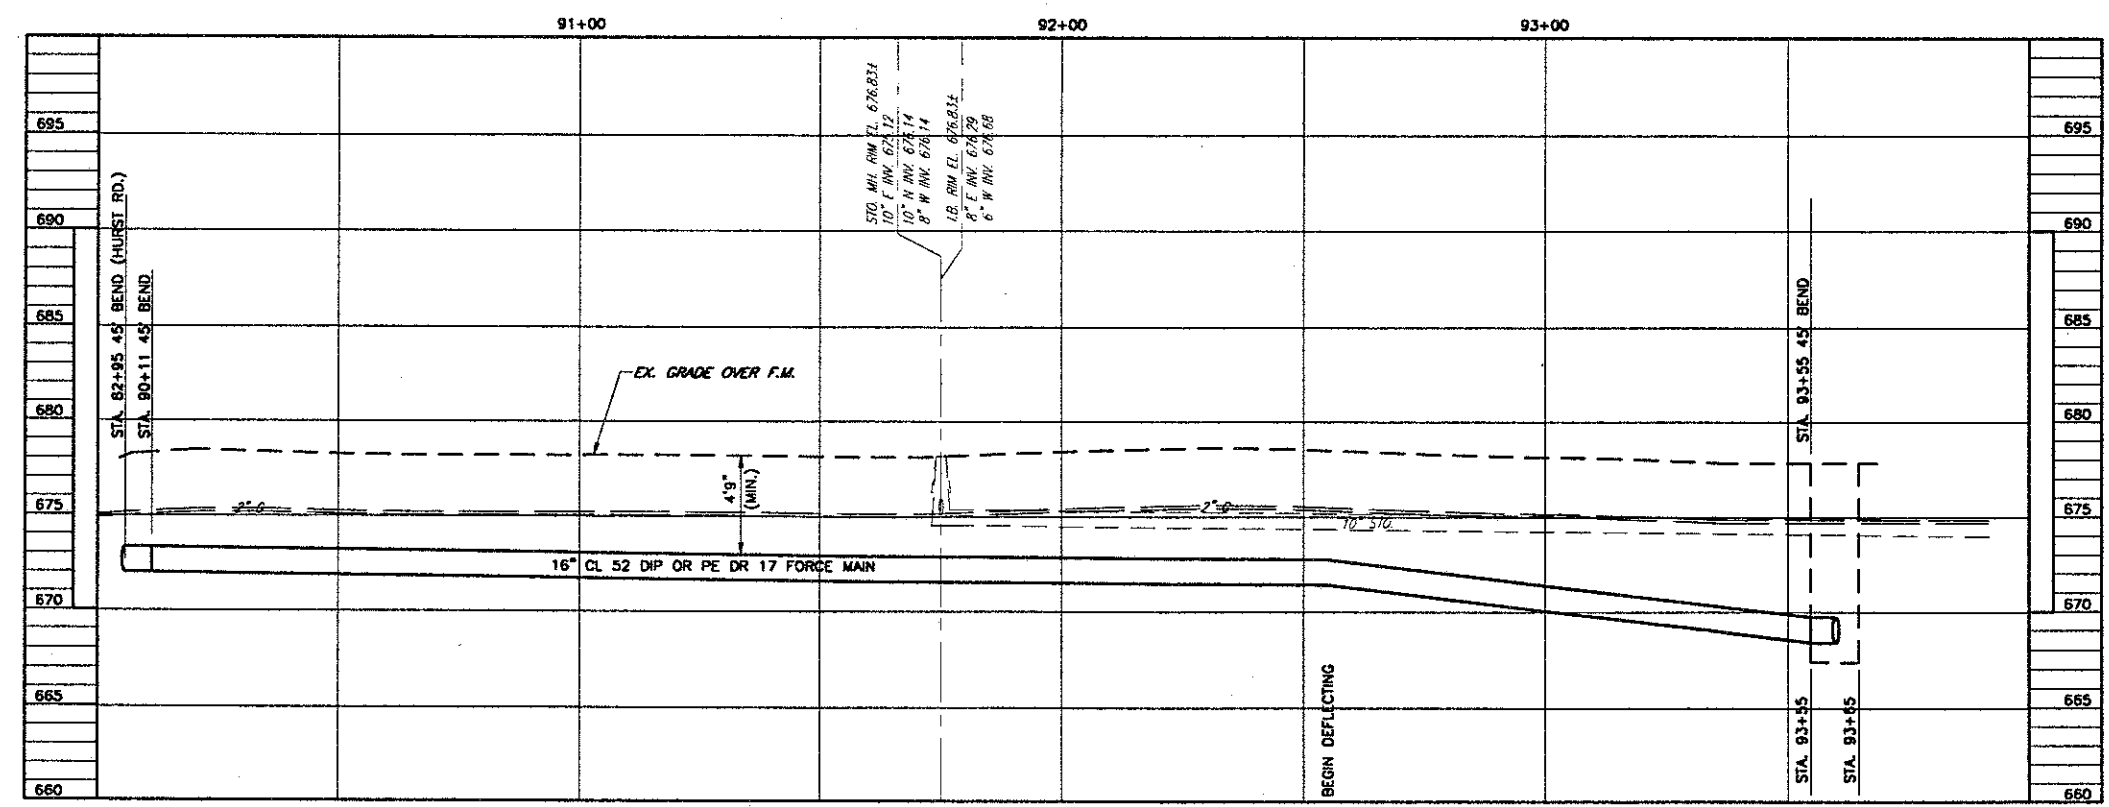

16'
36"
400

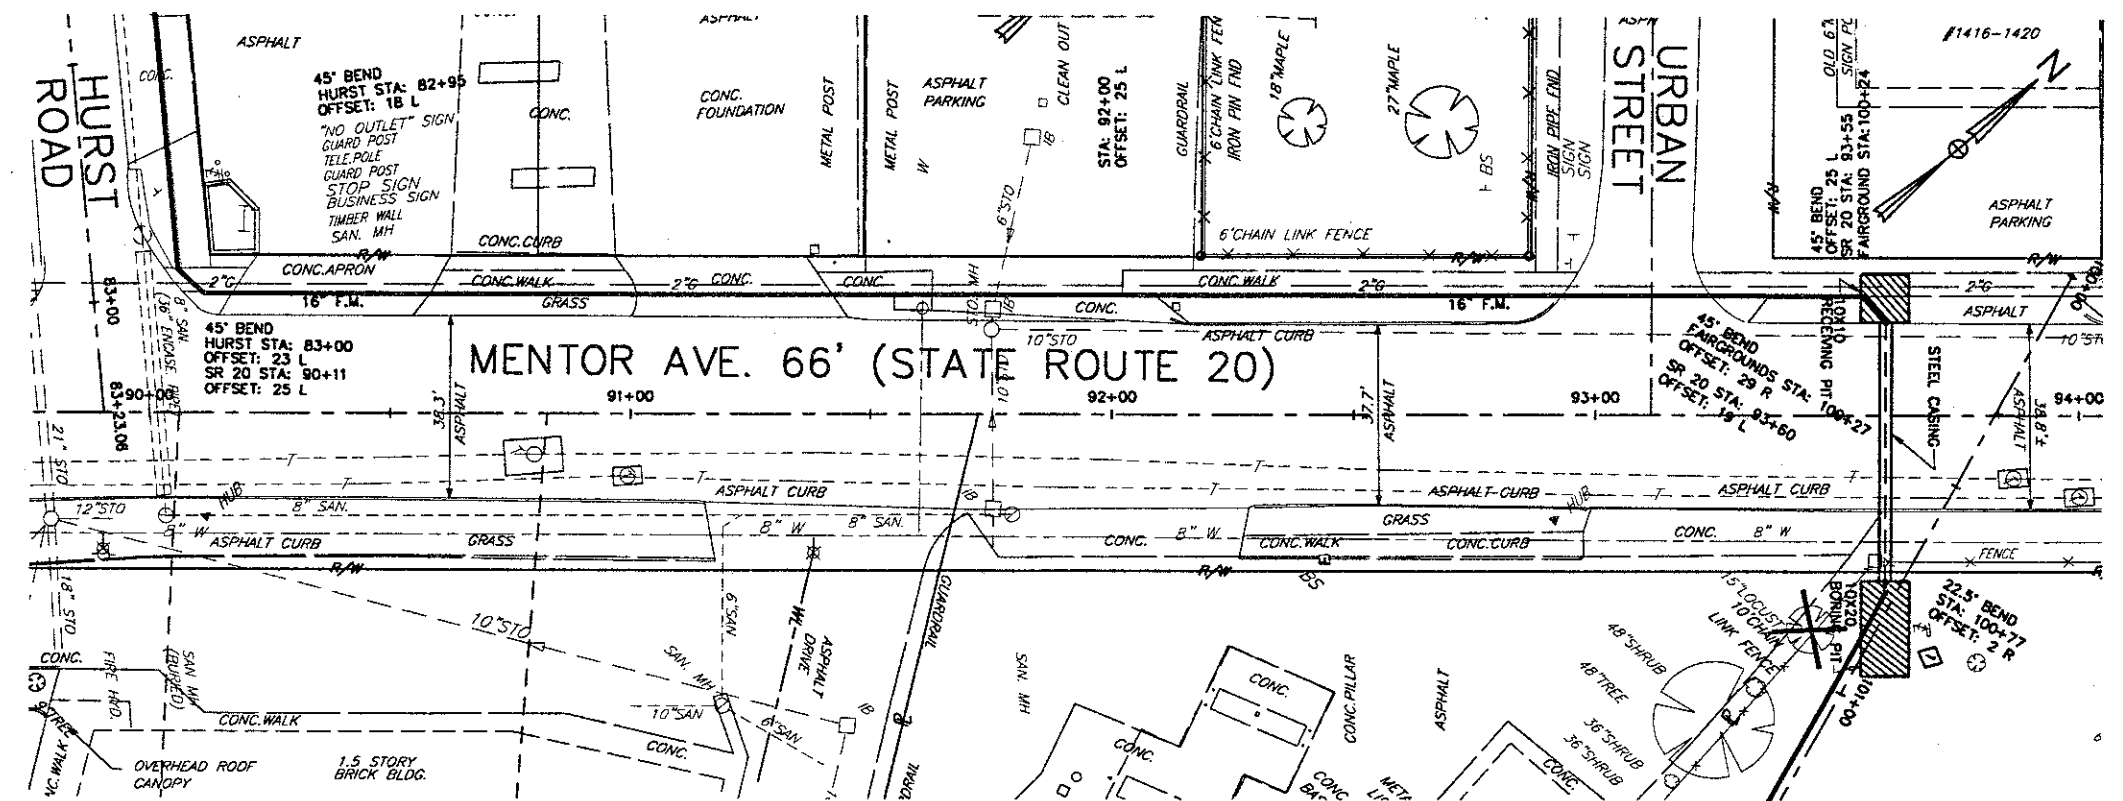

REV. NO.	DESCRIPTION	DATE	BY	CHK'D.

LAKE COUNTY DEPARTMENT OF UTILITIES
 CONCORD SEWER PROJECT
 SEWERAGE IMPROVEMENT NO. 2348
 CONTRACT C - FORCE MAINS
 LAKE COUNTY, OHIO

DATE: OCT., 1999
 DRAWN BY: R.L.M./C.K.T.
 CHECKED BY: J.M.Z.
 APPROVED BY: R.E.W.
 P.R. No. 1147 PC 99

MENTOR AVENUE
 PLAN AND PROFILE
 STA. 90+00 TO STA. 94+00

SCALE	
HOR.	1"=20'
VERT.	1"=5'
CONTRACT NO. 97303	
SHEET NO.	14
OF	40