



COPYRIGHT - DATE: 11-19-99 11:21 CT CONSULTANTS, INC. H:\C\97303\dwg\FAIRPROF05.dwg

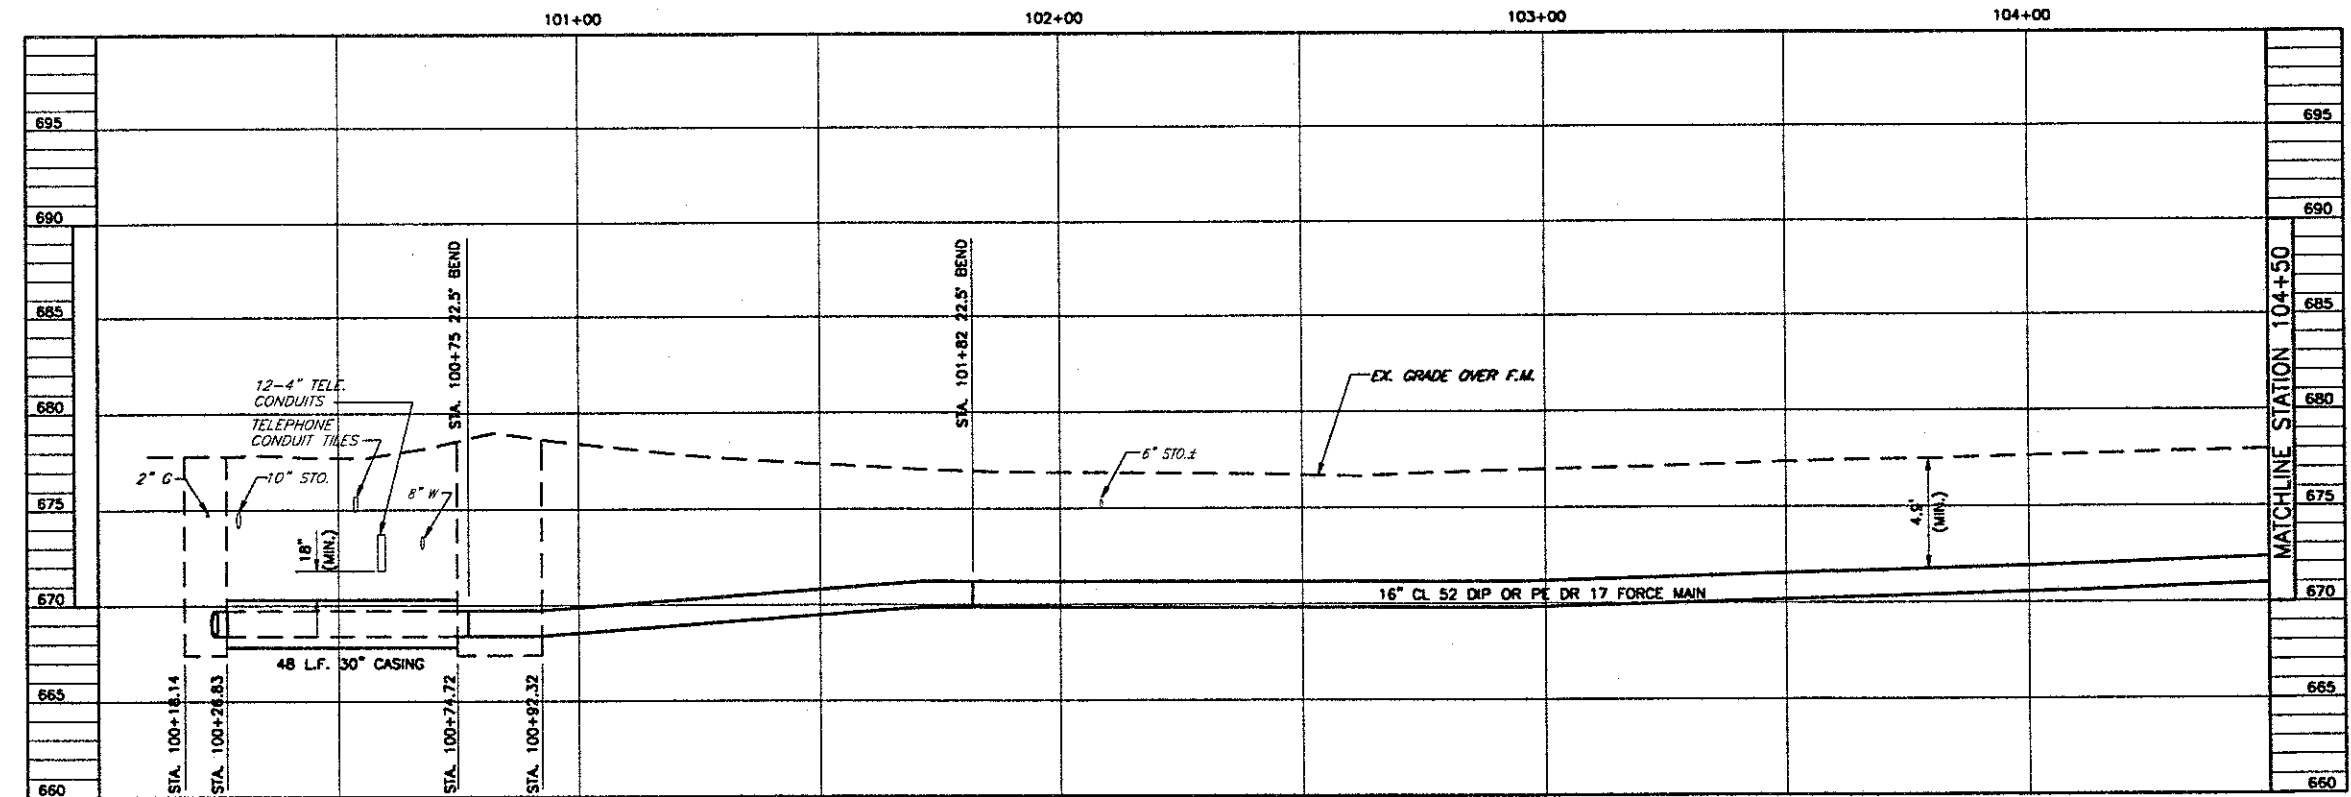

NOTE:
 ◊ CONTRACTOR TO SUPPORT
 OR RELOCATE POWER POLE.

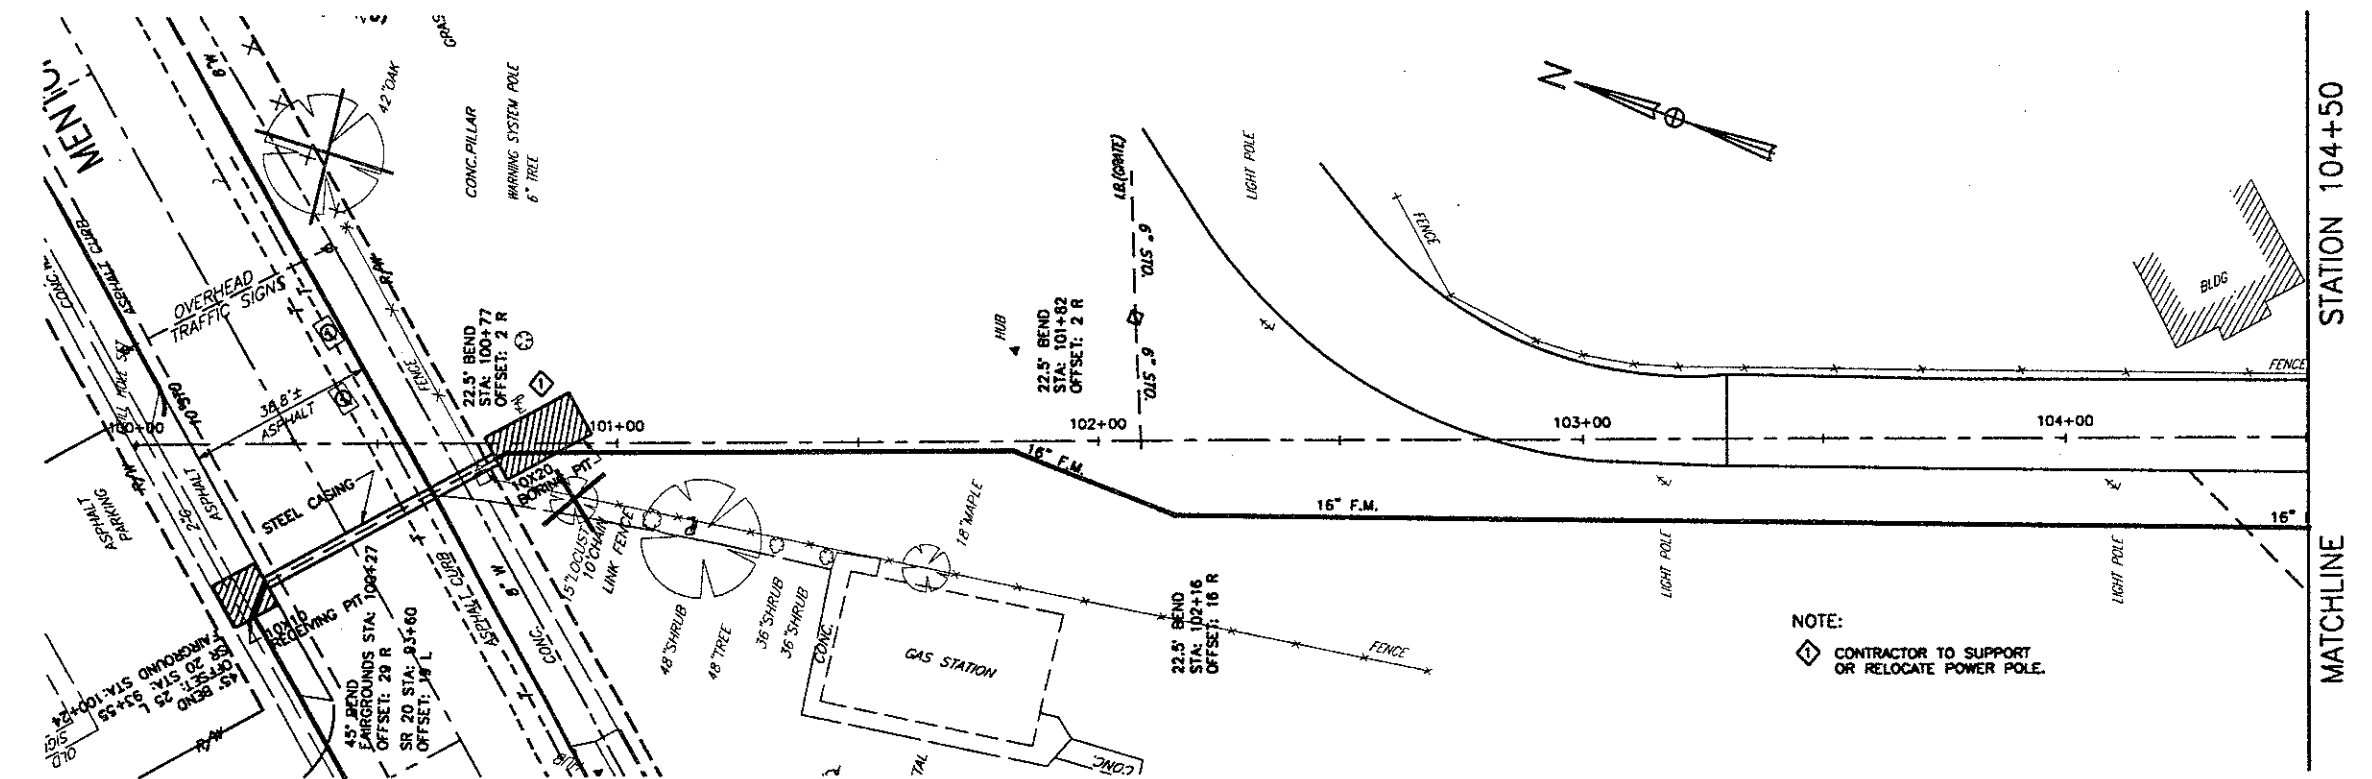

REV.	DESCRIPTION	DATE	BY	CHK'D.

LAKE COUNTY DEPARTMENT OF UTILITIES
 CONCORD SEWER PROJECT
 SEWERAGE IMPROVEMENT NO. 2346
 CONTRACT C - FORCE MAINS
 LAKE COUNTY, OHIO

DATE: OCT., 1999
 DRAWN BY: R.L.M./C.K.I.
 CHECKED BY: J.M.Z.
 APPROVED BY: R.E.W.
 P.E. No. 1147 PC 99

FAIRGROUNDS
 PLAN AND PROFILE
 STA. 100+00 TO STA. 104+50

SCALE	
HOR.	1"=20'
VER.	1"=5'
CONTRACT NO. 97303	
SHEET NO.	OF
15	40