


10 OHIO F.A.G.M-70A(1) 1941
LAKE COUNTY
SH 520-SEC. PAINESVILLE (PT.)
GRADE SEPARATION

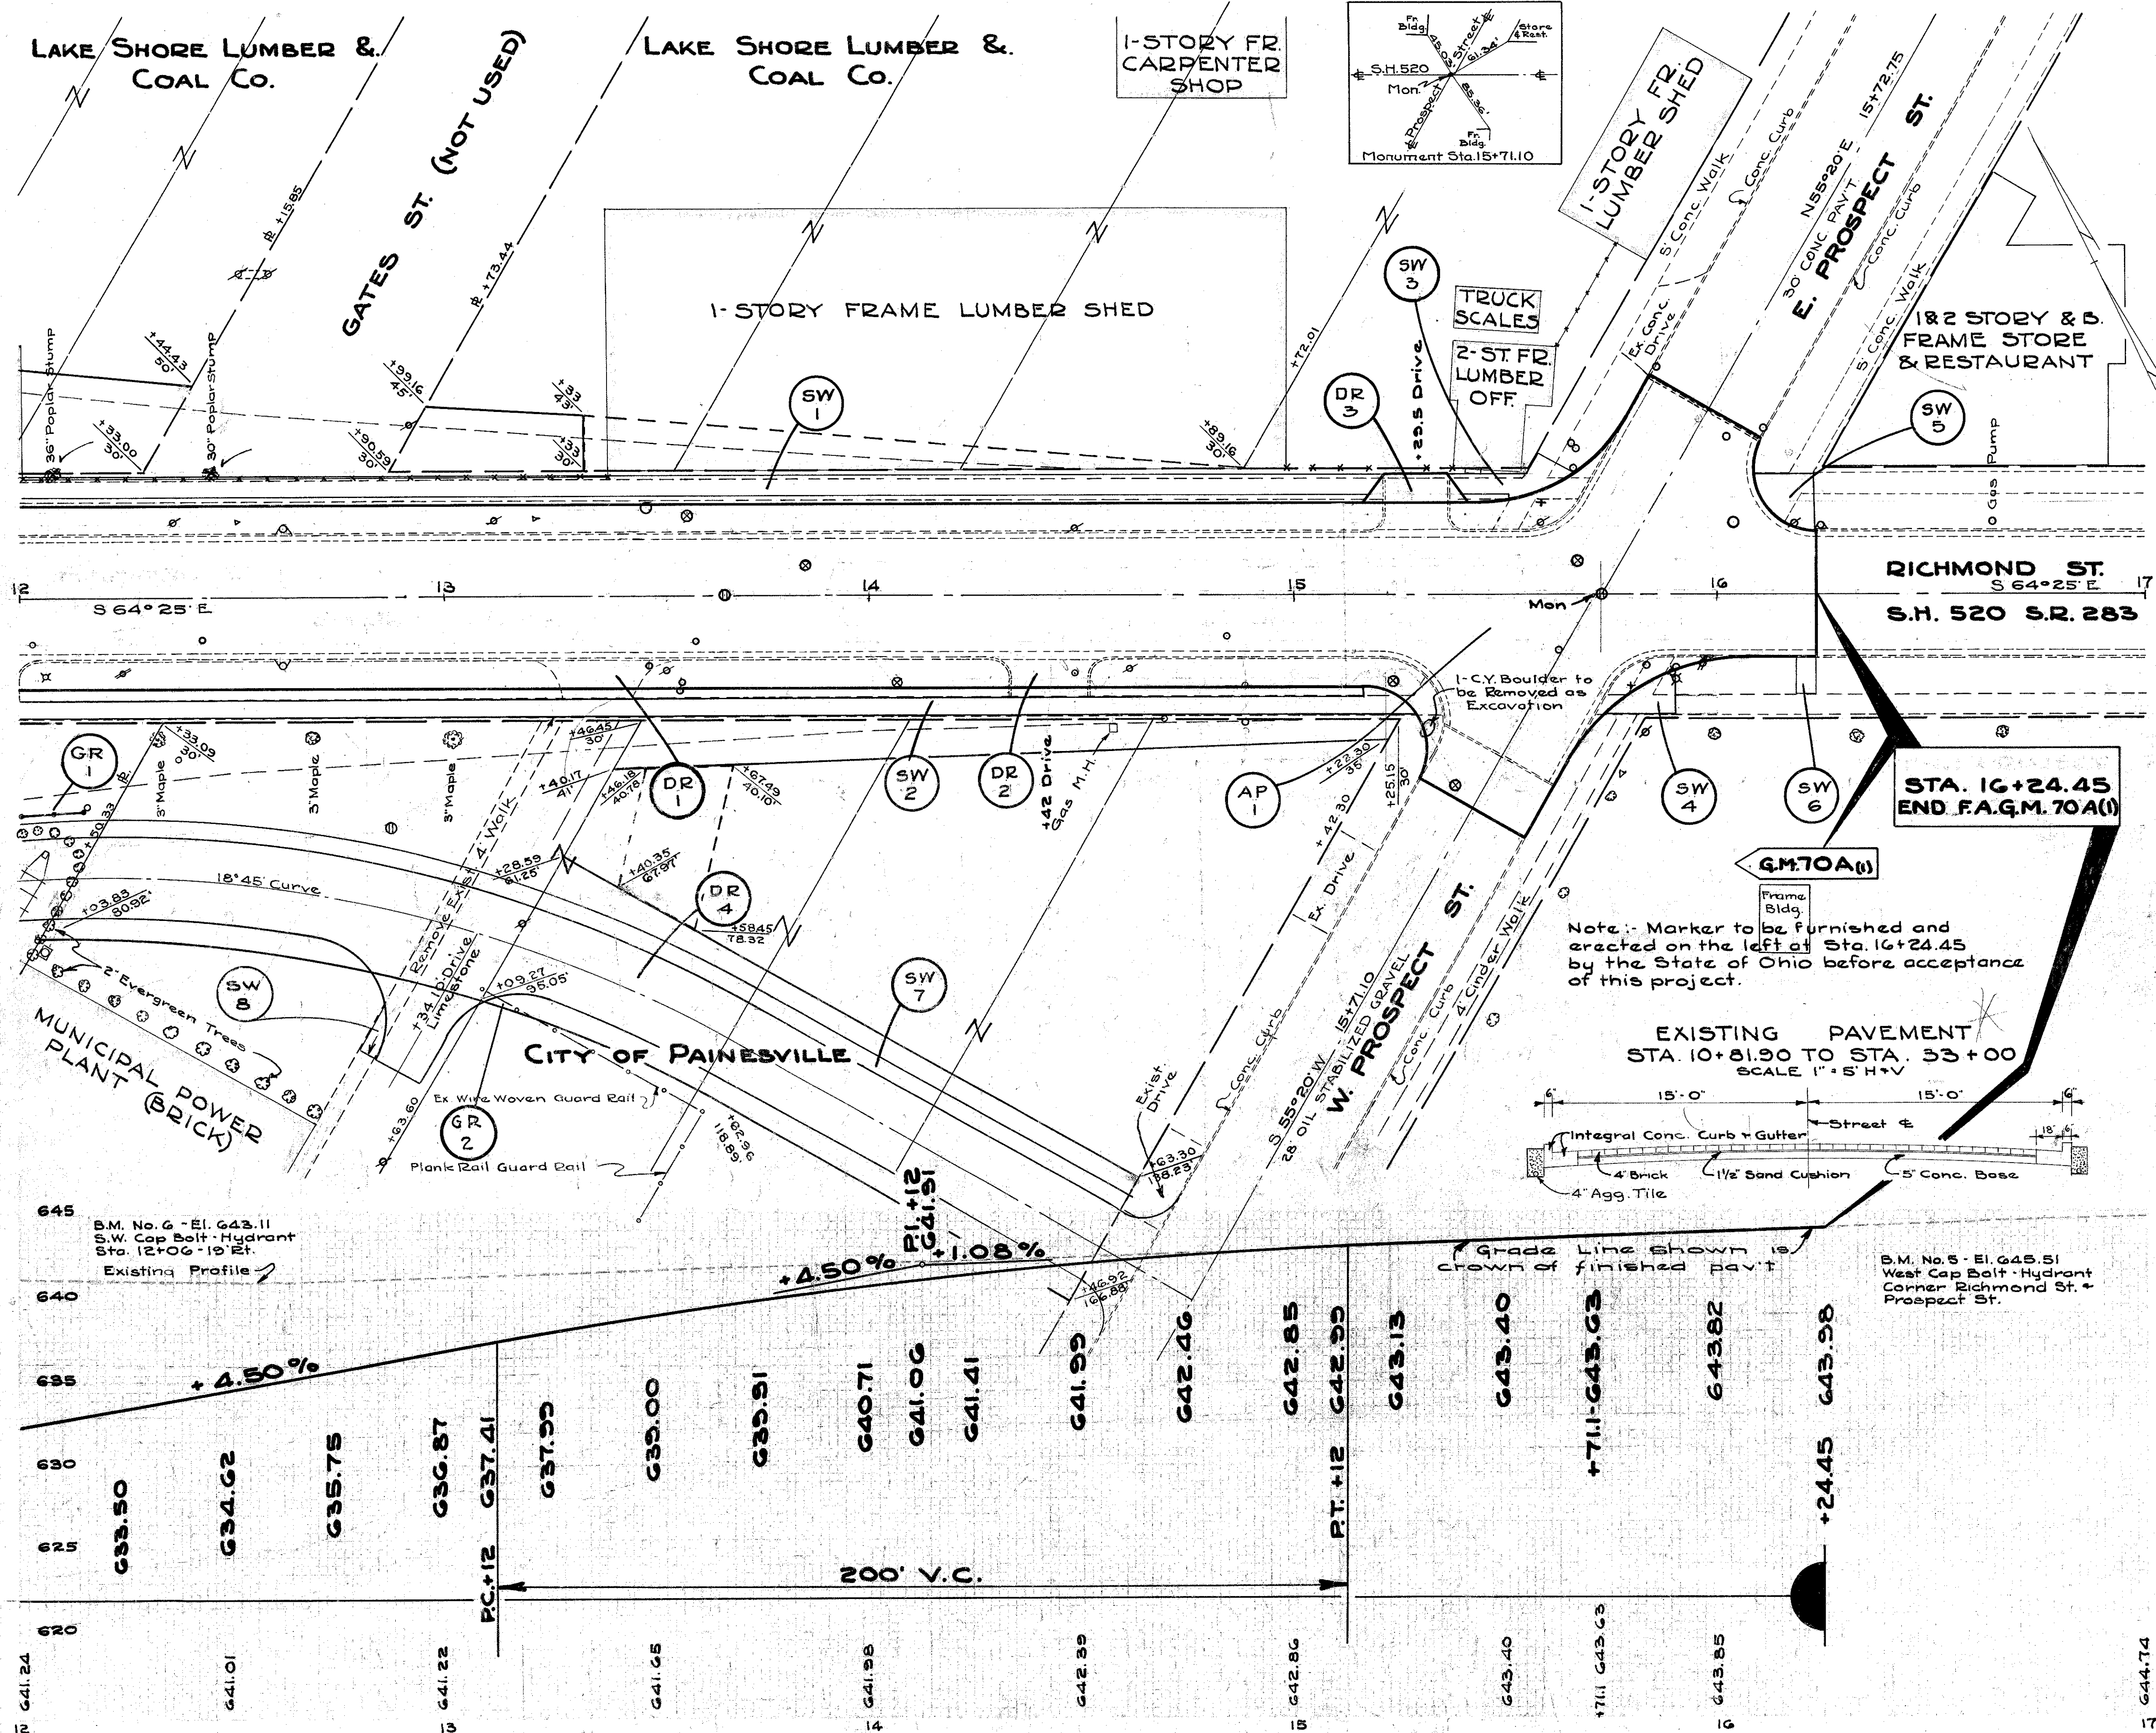

DRIVES

MARK	STATION	SIDE	Rem. & Store Ex. Wears. Course S.Y.	Rem. & Dis. Ex. Base S.Y.	Rem. & Dis. Ex. Curb L.F.	Rem. & Dis. Ex. Pavt. S.Y.	T-70 6" S.Y.	T-70 7" S.Y.	I-12 2A Curb L.F.	DETAIL SHEET NO.
DR-1	13+34	R				20.8				21
DR-2	14+42	R	17.7	17.7	22			14.44		21
DR-3	15+29.5	L	20.8	20.8	30				705	644.1
DR-4	B&O	R			38					23
TOTAL			38.5	38.5	90	20.8	14.44	705	644.1	

APPROACHES

MARK	STATION	SIDE	Rem. & Dis. Ex. Curb L.F.	Rem. & Dis. Ex. Pavt. L.F.	Rem. & Dis. Ex. Wears. Course S.Y.	T-70 6" S.Y.	T-70 7" S.Y.	I-12 2A Curb L.F.	DETAIL SHEET NO.	
AP-1	15+12	L-R	28.6	28	238.4	560.4	560.4	244.1	758.5	22

GUARD RAIL

MARK	STATION	SIDE	BUILD LIN. FT.	Rem. & Store GE. L.F.
GR-1	12+00	R	18.5'	
GR-2	13+00	R		10
TOTAL				18.5'


SIDEWALKS

MARK	STATION	SIDE	Sq Ft
SW-1	12+00	L	1603
SW-2	12+00	R	1633
SW-3	15+38.4	L	150
SW-4	As Shown	R	90
SW-5	As Shown	L	170
SW-6	16+18.3	R	49
SW-7	B & O Drive	R	1124
SW-8	Mun. Power Plant	R	48
TOTAL			4867

TREES TO BE REMOVED

STATION	SIDE	DIST.	SIZE	KIND
12+08	L	28'	36"	FOR STR.
12+45	L	28'	30"	FOR STR.
TOTAL TREES				2 EACH

MARKED THUS

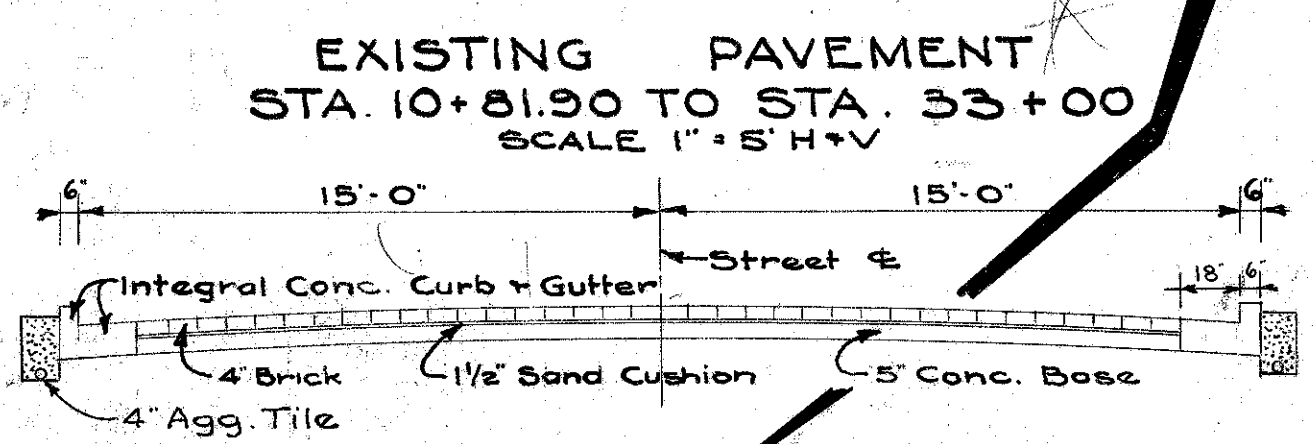

Note: Marker to be furnished and erected on the left at Sta. 16+24.45 by the State of Ohio before acceptance of this project.

B.M. No. 6 - El. 643.11
S.W. Cap Bolt - Hydrant
Sta. 12+06 - 10' Et.
Existing Profile

B.M. No. 5 - El. 645.51
West Cap Bolt - Hydrant
Corner - Richmond St. +
Prospect St.