


CALC. BY HWD
 DATE 10-3-82
 CHKD. BY _____
 DATE _____


OHIO
 FHWA REGION 5

34A
 36

LAKE COUNTY
 LAK-90-11.90

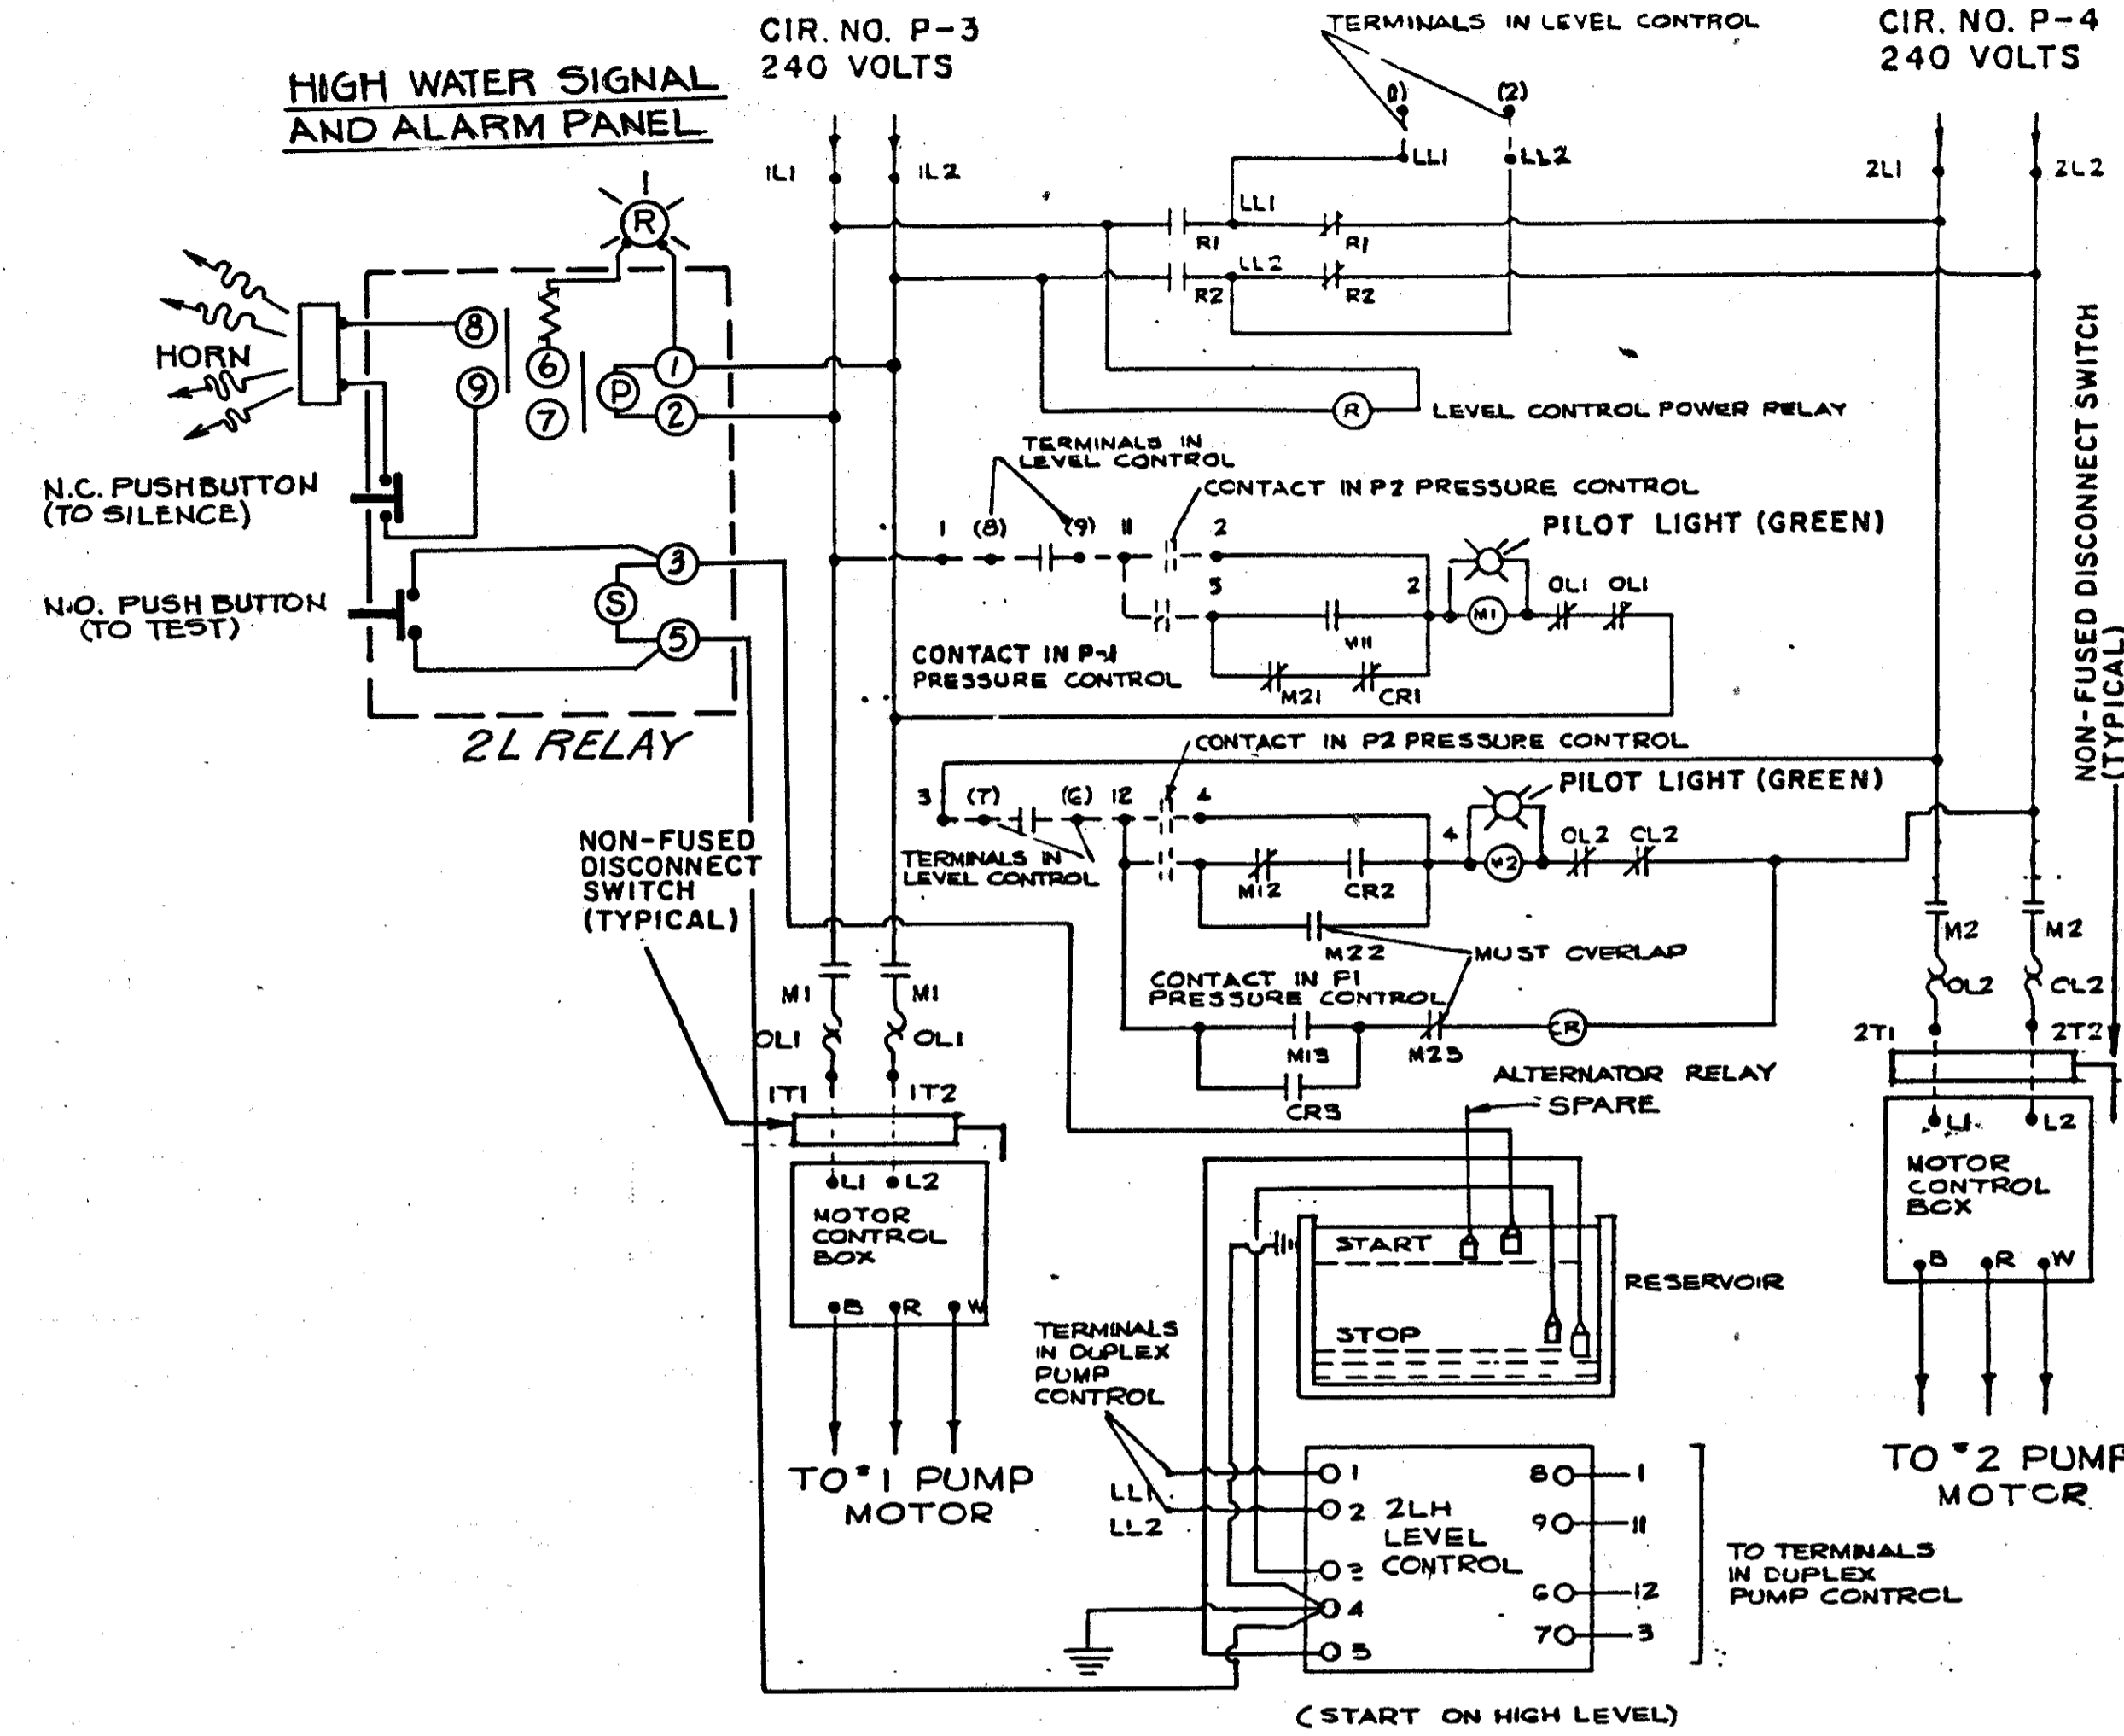

6G-03
 SCHEMATIC FOR RESERVOIR & PRESSURE PUMP CONTROL
 NOT TO SCALE

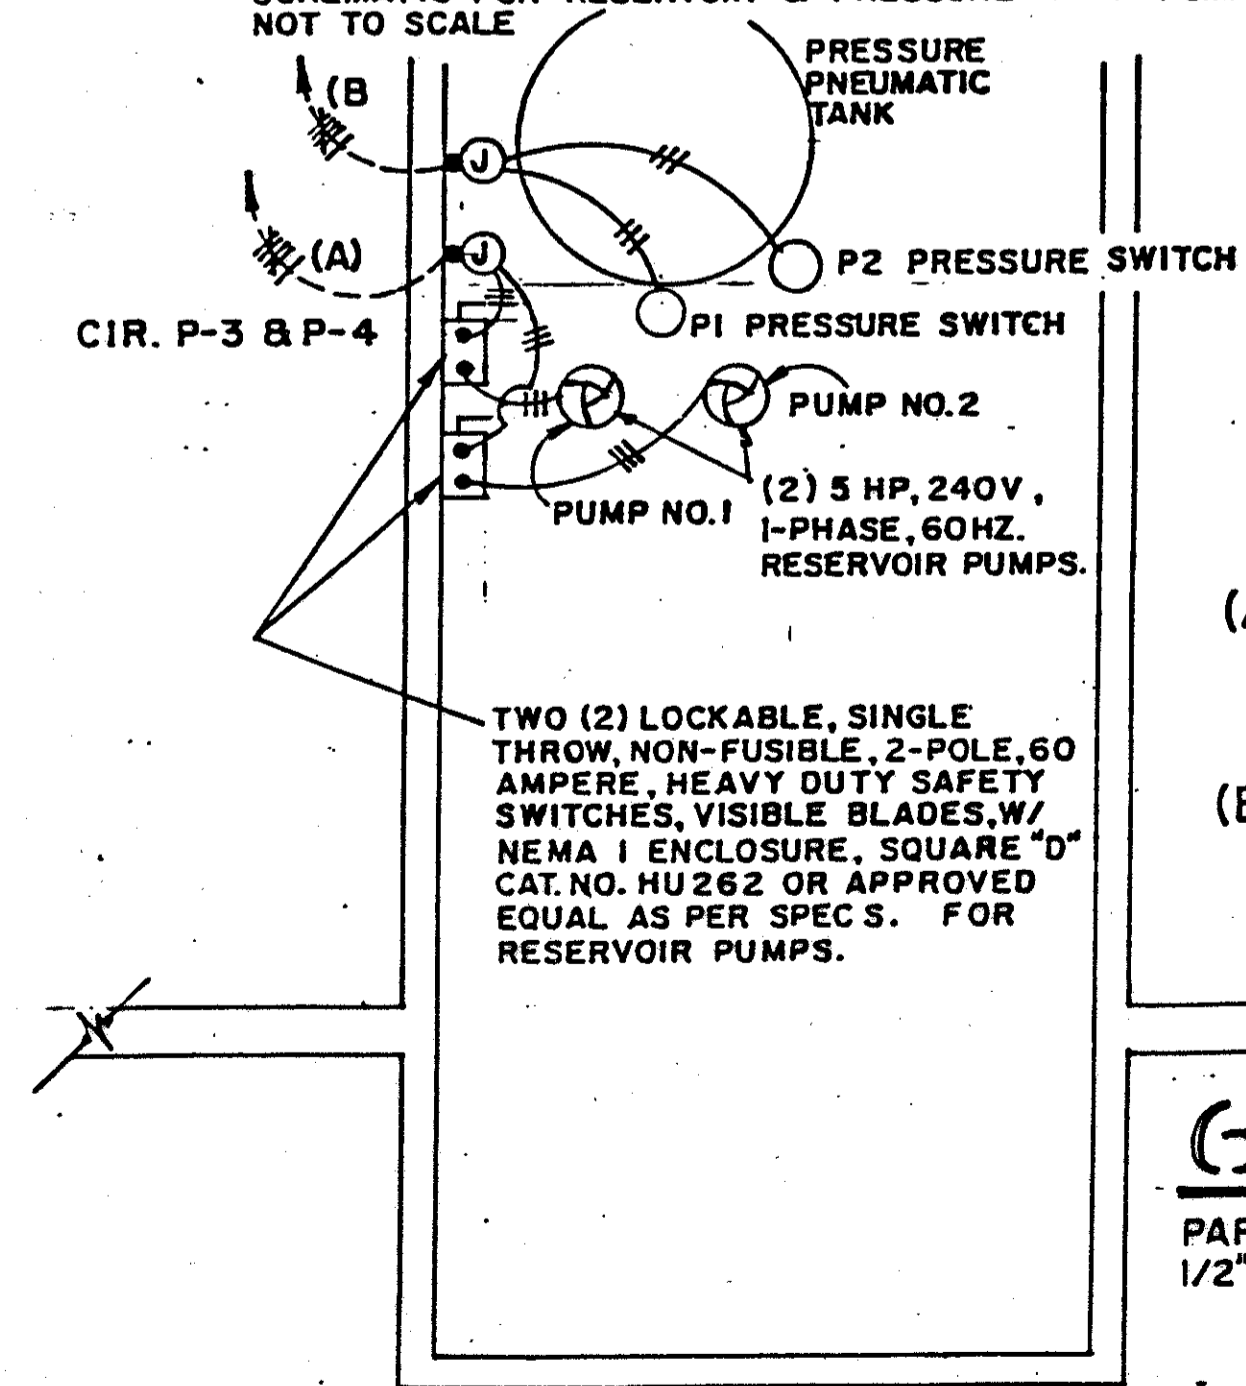

- (A) 4-NO. 6 THW & 2-NO. 6 THW GREEN GRD./ IN 1-1/4" COND. TO DUPLEX PUMP CONTROL IN RESERVOIR. PUMP CONTROL CABINET. (2) 6.7 KW, CKT. P-3 & P-4, RM 105
- (B) 4-NO. 12 THW & 2-NO. 12 THW GREEN GRD./ IN 1" COND. TO P1 & P2 CONTACTS IN RESERVOIR PUMP CONTROL CABINET, RM 105.

6G-02
 PARTIAL FLOOR PLAN RM 103
 1/2" = 1'-0"

BUREAU OF DESIGN SERVICES DIVISION OF HIGHWAYS OHIO DEPARTMENT OF TRANSPORTATION	
ROADSIDE DEVELOPMENT	DATE 9/22/82
RESERVOIR & PRESSURE TANK PUMP CONTROLS	
APPROVED _____ Engr. of Design Services	