

MICROFILMED
APR 5 1969

STATE OF OHIO
DEPARTMENT OF HIGHWAYS
LAK - 1 - 16.55
PAINESVILLE & LEROY TOWNSHIPS
LAKE COUNTY


LIMITED ACCESS
This improvement has been declared a limited access highway or freeway by action of the Director of Highways in accordance with the provisions of Section 5511.02, Revised Code of Ohio and is especially designed for through traffic.

FEDERAL RD DIVISION	STATE	PROJECT
2	OHIO	AC I-1103 (27)

LAKE COUNTY
LAK-1-16.55

LAK-90-19.21


ACI-1103(27)

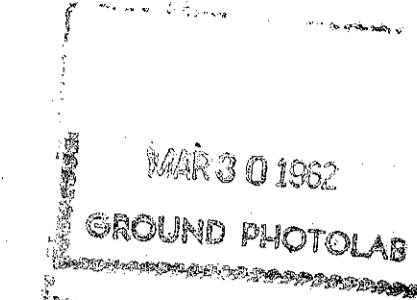

- CONVENTIONAL SIGNS
- State Line.....
 - County Line.....
 - Township Line.....
 - Section Line.....
 - Center Line.....
 - Corporation Line.....
 - Fence Line.....
 - Guard Rail (existing).....
 - Guard Rail (proposed).....
 - Steam Railroad.....
 - Power Poles.....
 - Telephone Poles.....
 - Traces or Stumps (existing).....

INDEX


TITLE SHEET	1
TYPICAL SECTIONS	2 - 4
SUPERELEVATION TABLE	5
GENERAL NOTES	6 & 7
COMPUTATIONS & SUB-SUMMARIES	8
SCHEMATIC LAYOUT	9
GENERAL SUMMARY	10 - 12
PLAN & PROFILE	13 - 33
CROSS-SECTIONS - PAINE CREEK CROSS-SECTIONS	34 - 316
VROOMAN ROAD LIGHTING PLAN	317
VROOMAN ROAD INTERCHANGE	318 - 325
VROOMAN ROAD PLAN & PROFILE	326 - 328
RAMPS & VROOMAN ROAD DRAINAGE	328A
DRIVES PROFILE	329
VROOMAN ROAD CROSS-SECTIONS	330 - 367
STRUCTURES 20' SPAN & UNDER	368 - 373
SKewed HEADWALL DETAILS	374
I-2 & I-4 DRAINAGE DETAIL	375
MODIFIED # 5 CATCH BASIN DETAILS	376
PAVED MEDIAN CROSSOVER	377
STRIPING & PAINTING DETAIL	378
DELINEATOR DETAIL & APPROACH SLAB EROSION CONTROL DETAIL	378A, 378B
STRUCTURES 20' SPAN & OVER	379 - 400
RIGHT-OF-WAY PLANS	401 - 413
SOILS PROFILE	
UTILITY FORCE ACCOUNT WORK - CLEVELAND ELECTRIC ILLUMINATING	405 - 408

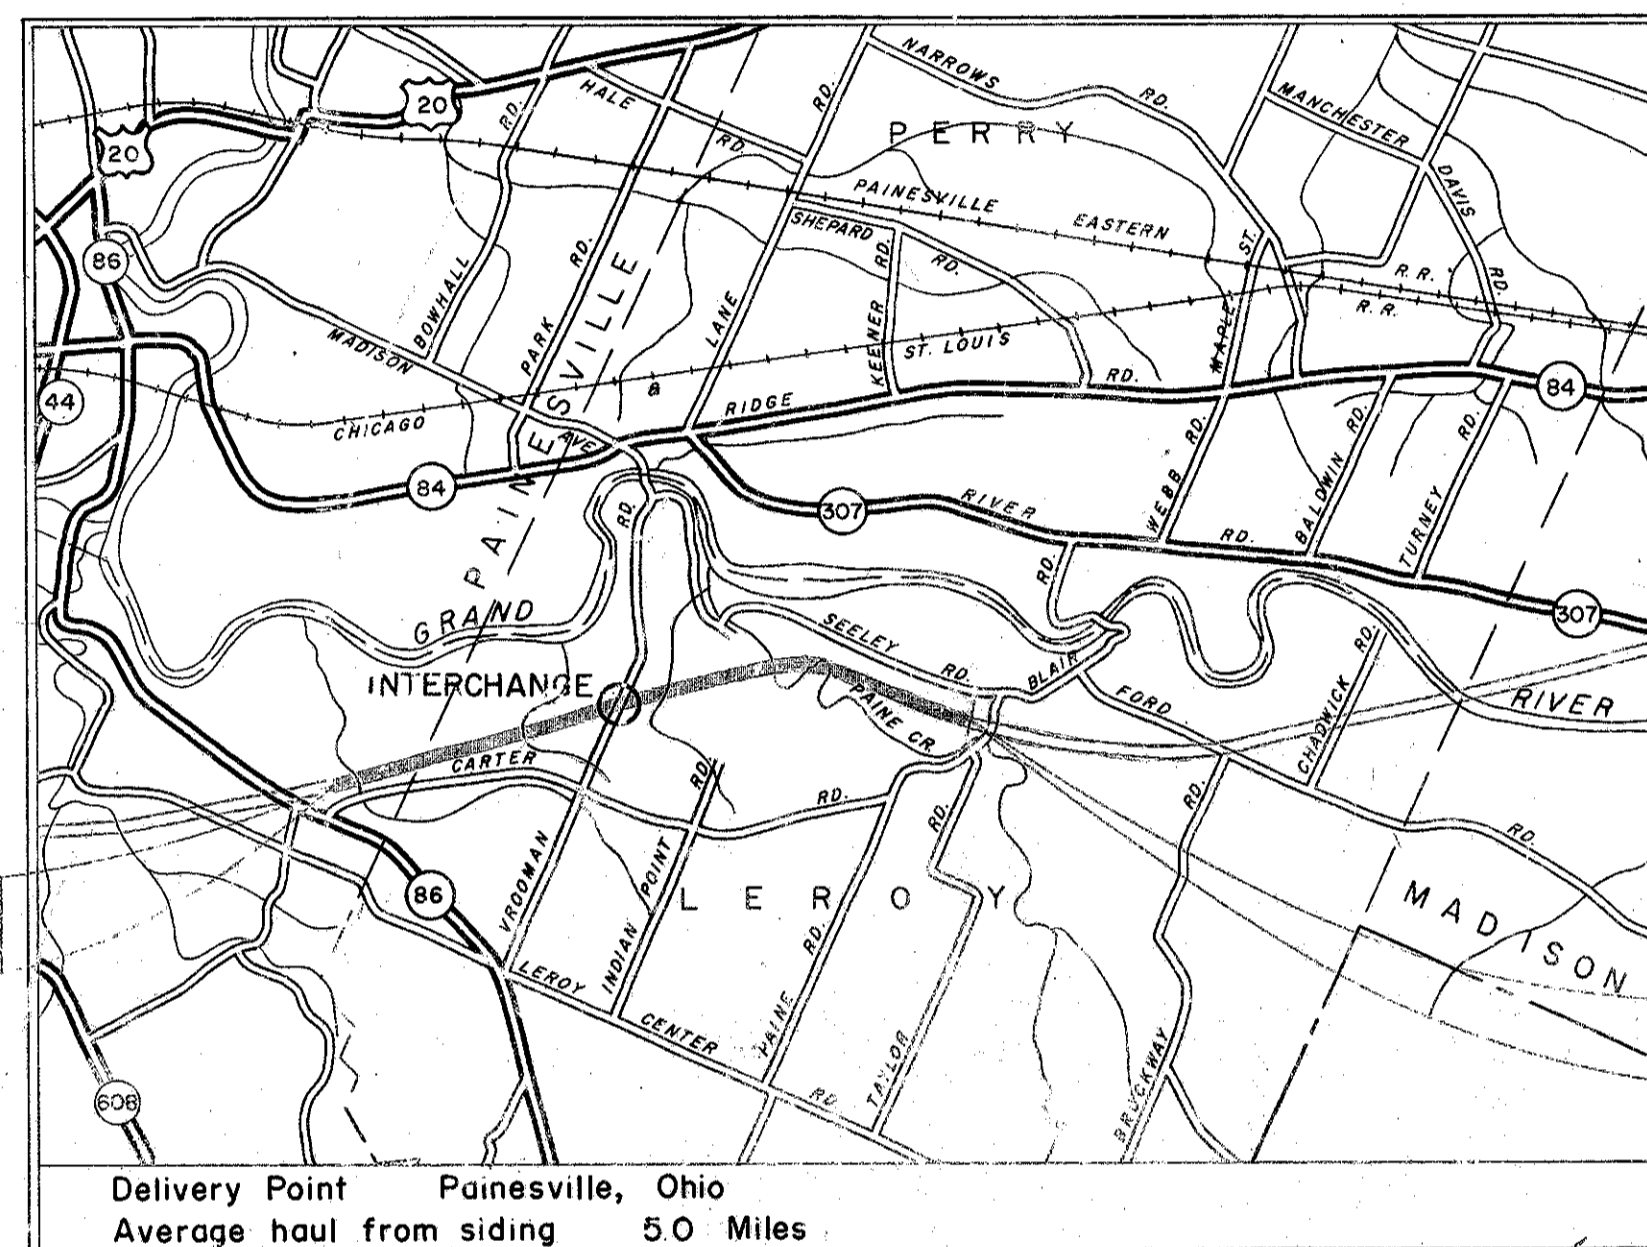

BEGIN PROJECT
STA. 520 + 00

END PROJECT
STA. 703 + 50

 LOCATION MAP



LEGEND

- Portion to be improved.....
- State Roads.....
- Other Roads.....

SCALE

- Plan..... 1" = 50'
- Profile: Horizontal..... 1" = 50'
- Profile: Vertical..... 1" = 10'

SUPPLEMENTAL PRINTS OF STANDARD CONSTRUCTION DRAWING

I-15 No.5	12-9-57	T-35	1-2-56	I-14G	1-22-52
I-15 No.2	6-1-57	S-T-71R	3-2-53	G-7.07	6-1-56
I-15 No.6	12-9-57	L. J. No.1	7-1-55	B. T. 50.70-71E No.110-147	
I-15 No.2B	6-1-57	T. J.	5-1-56	AR-1-57	3-1-58
I-15 No.1	8-1-55	S-27 PC 3	2-20-45	CSB-2-56 Sht.2	3-1-58
HW-C	7-15-57	S-27 PC.4	1-4-54	CSB-2-56 Sht.3	3-1-58
HW-A&B	7-15-57	I-1,2,3,4,8,5	2-20-45	RB-1-55	3-1-55
F-1	4-1-57	I-8 CB#4	6-1-57	AS-1-54	12-1-54
L-1	4-1-50	I-8 CB#5	6-1-57	I-21-23	8-1-56
L-3	4-1-50	I-8 CB 2-3&2-4	5-1-52		
L-3A	4-1-50	I-8 CB 6	5-1-52		
RI-1	1-3-55	I-8 M.H. No.1	5-1-52		
DR-1	1-3-55	I-8 M.H. No.1A	3-55		

SUPPLEMENTAL SPECIFICATIONS

I-127	11-16-57
E-101	1-1-57
I-125	11-6-57
5	6-8-55
18	2-6-57
B-119	8-11-57
S-114	8-1-57
M-206.14	7-15-49

The standard specifications of the State of Ohio, Department of Highways, including changes and supplemental specifications listed in the proposal shall govern this improvement.

The right of way for this improvement will be provided by the State of Ohio.

I hereby approve these plans and declare that the making of this improvement will not require the closing of the highway to traffic and that provisions for the maintenance and safety of traffic will be as set forth on the plans and estimates.

Approved: *R. J. Schuman*
Date 5-2-58 Chief Engineer, Interstate Projects

Approved: *D. H. Mahoney*
Date 5/23/58 Deputy Director, Planning & Programming

Approved: *P. E. Mactico*
Date 5-5-58 Deputy Director, Design & Construction

Approved: *George J. Flanagan*
Date 5-23-58 First Assistant Director

Approved: _____
Date _____ Acting Director of Highways


Sheet No. 383 superseded by Sheet No. 383 Revised 7-8-58.

Sheet No. 1 Revised 7-11-58 Sheet No. 378B added 7-11-58
Sheets 386, 387 & 395 Revised 8-12-58.

Sheets 383 (Revised), 386, 394 and 396 Revised 8-26-58.
Sheets 386, 389, 389, 393, 394, 397, 398 and 400 Revised 9-17-58.
Sheet 388 Revised 11-19-58.

Sheets 389, 395 & 396 Revised 12-31-58.

Prepared and Recommended By
Capital Engineering Associates
Consulting Engineers, Dillsburg, Pa.

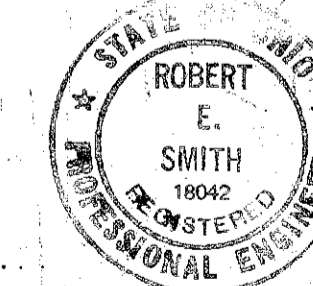


Partner

DEPARTMENT OF COMMERCE
BUREAU OF PUBLIC ROADS

APPROVED: _____

DIVISION ENGINEER DATE

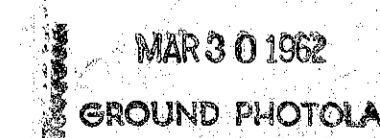

Approved: *H. H. Hart*
Date 5-2-1958 Engineer of Traffic

LAKE COUNTY
Date of Printing
LAK-1-16.55
19